



Existing First Floor Lighting Plan

1:50

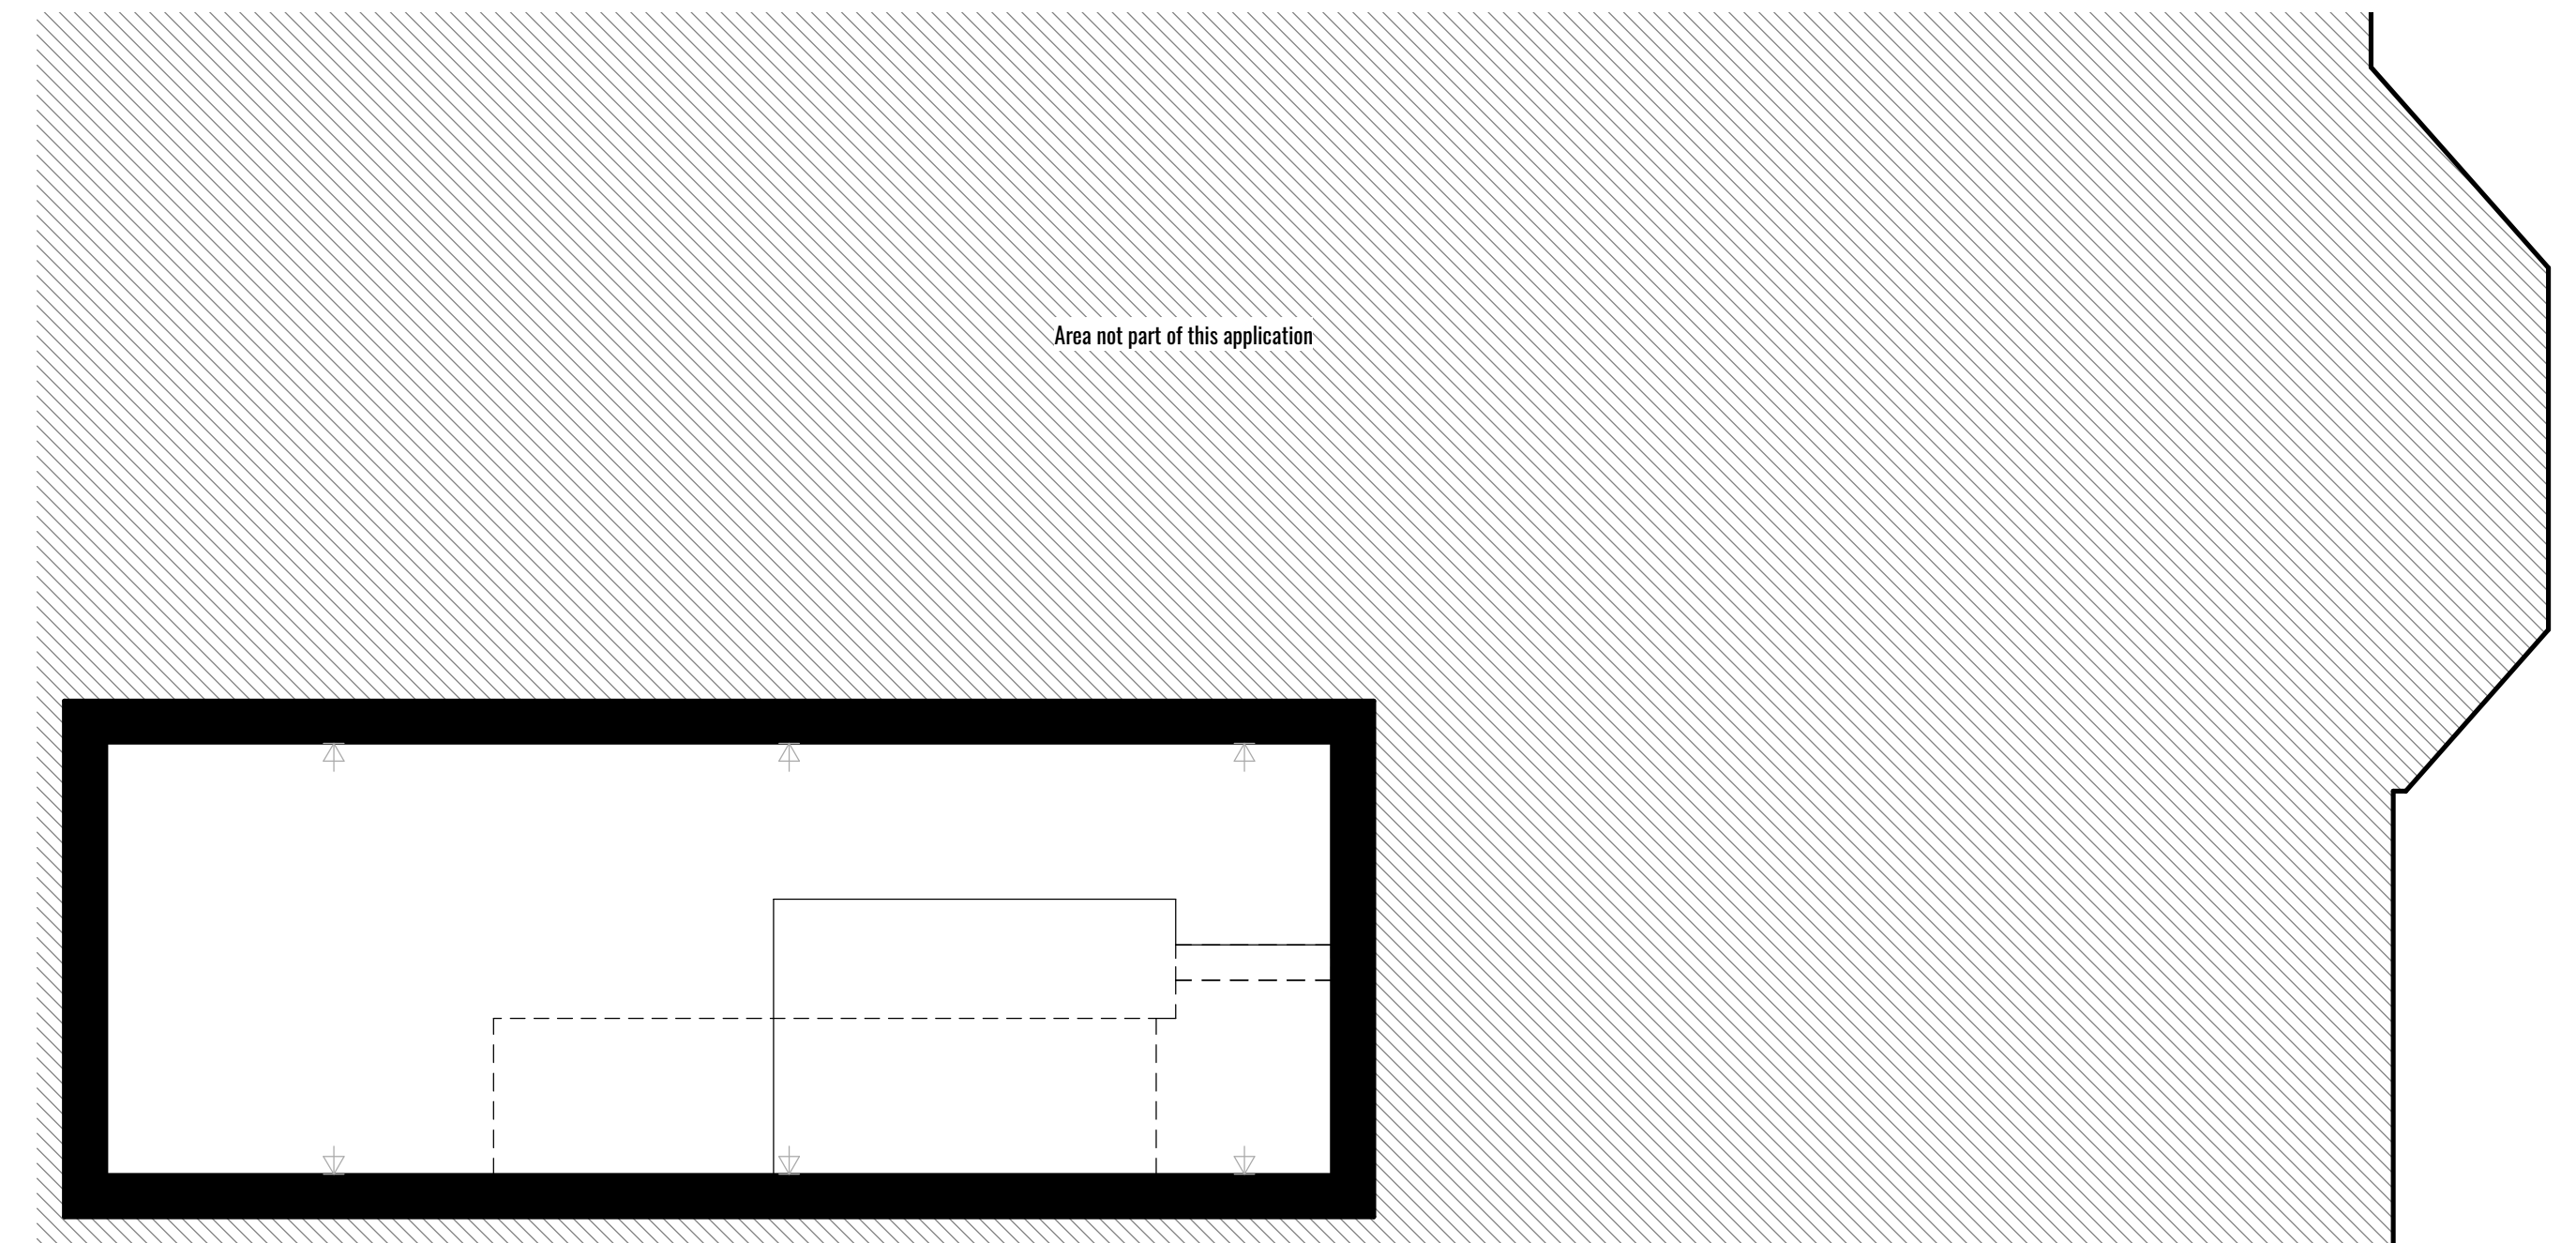

Existing Second Floor Lighting Plan

1:50

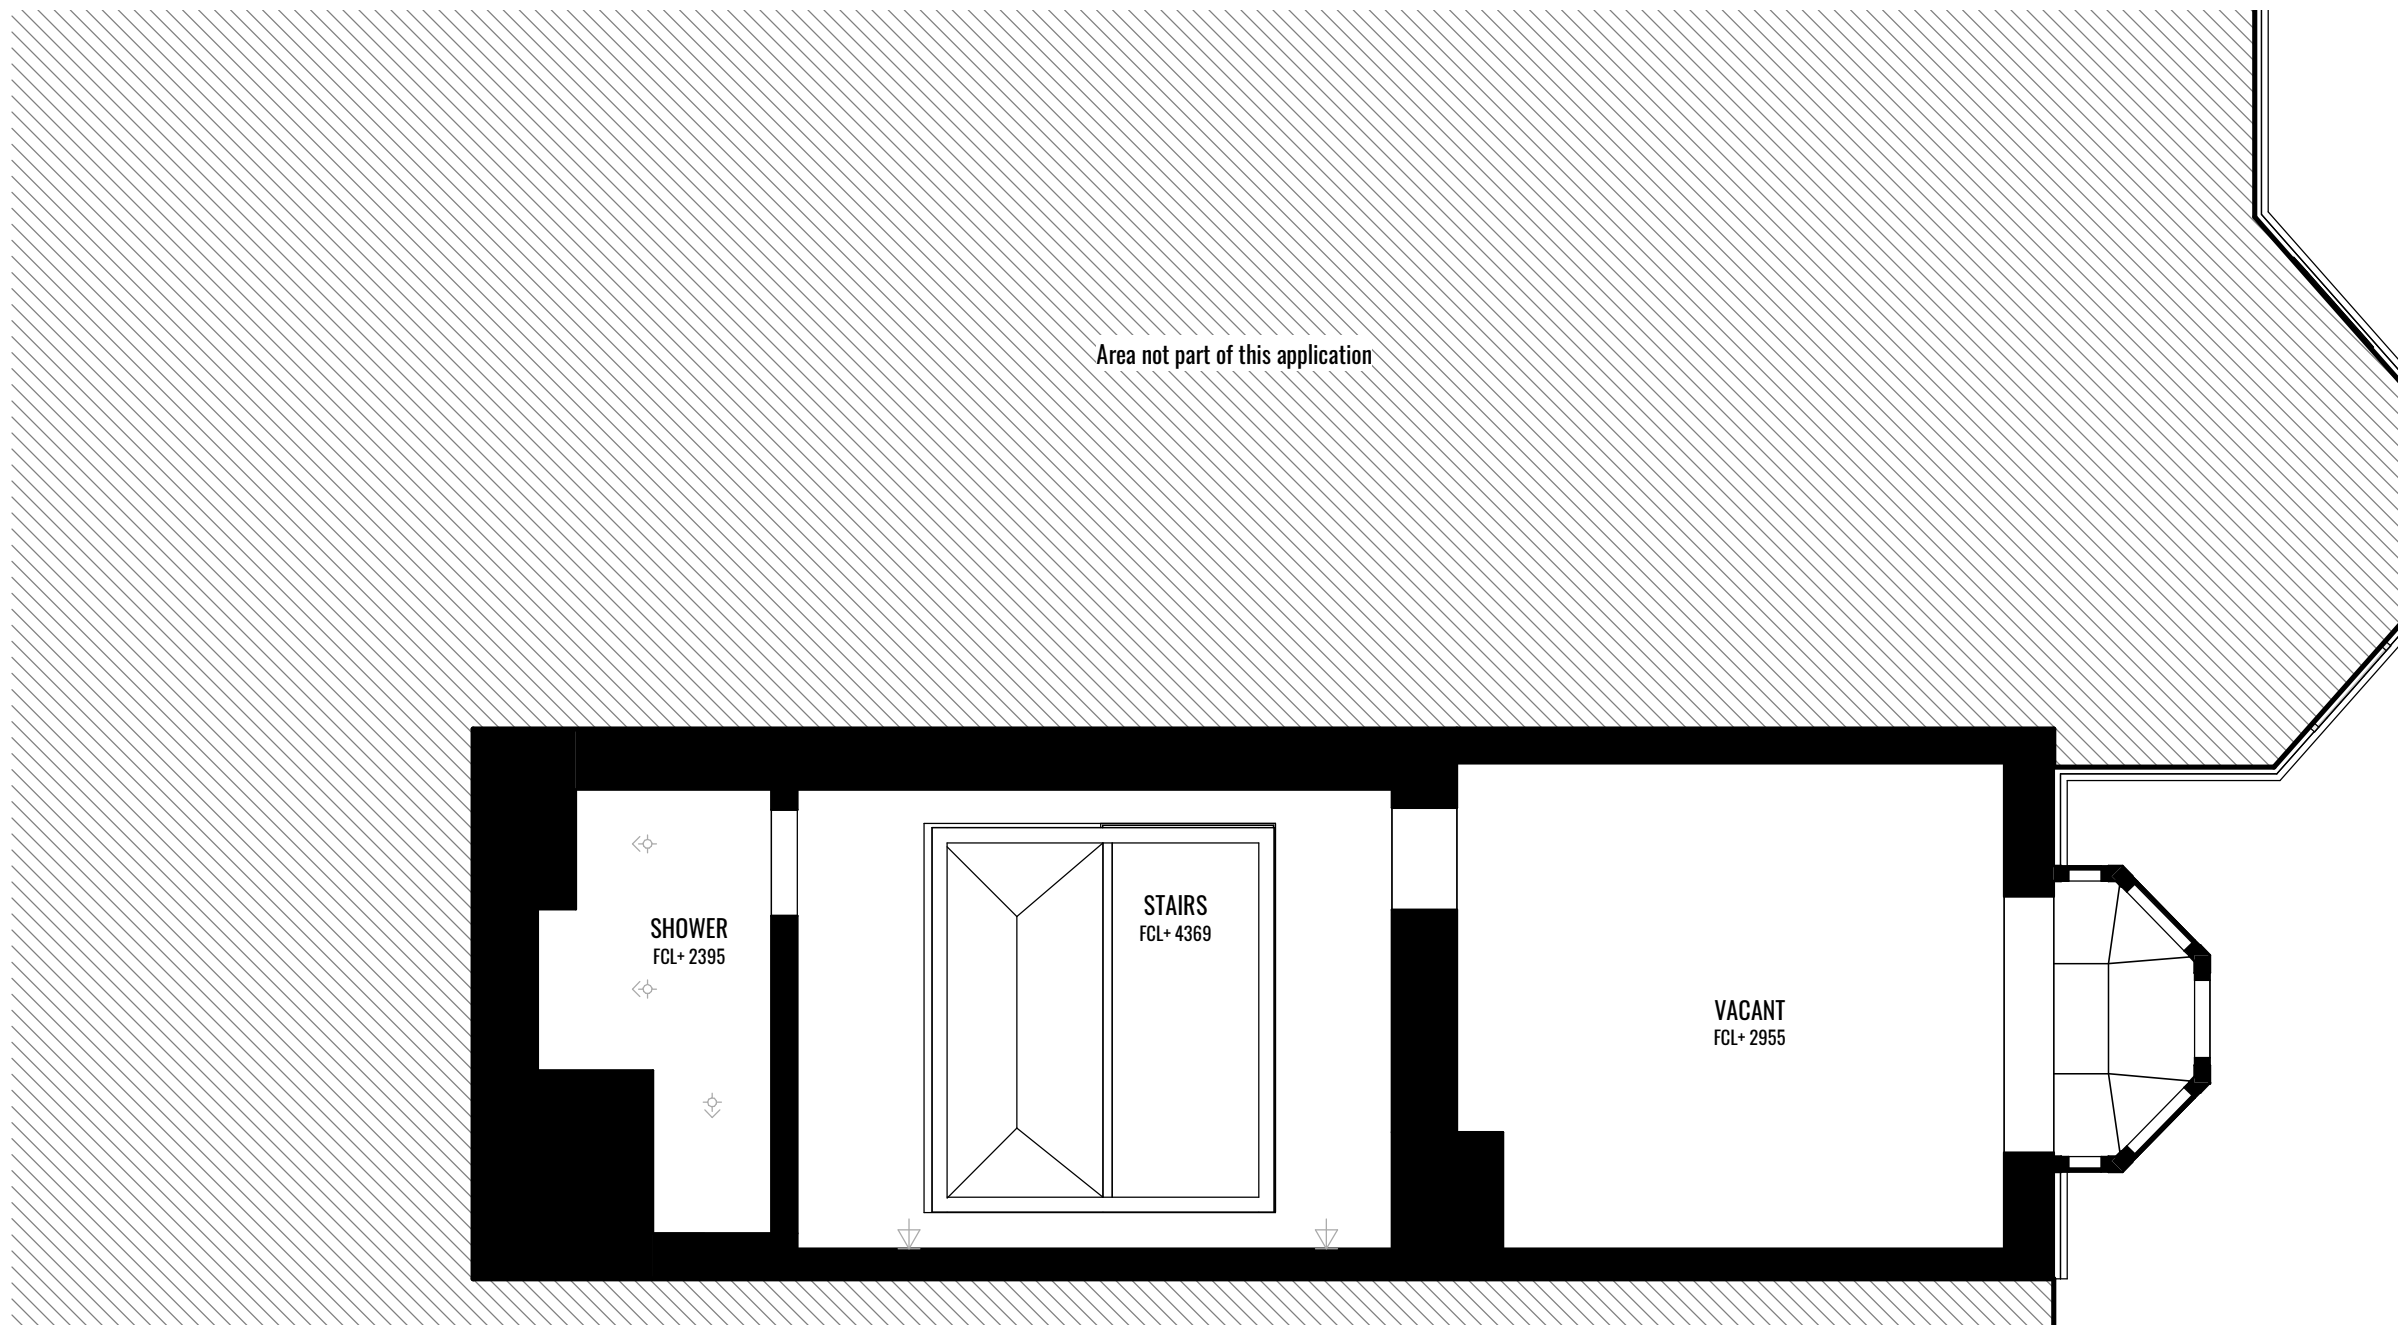

Existing Third Floor Lighting Plan

1:50

DOWEN FARMER ARCHITECTS

Unit 601, Level 6,
Peckham Levels,
95A Rye Ln,
London
SE15 4ST

T: 020 8058 7997
W: www.dowenfarmer.com

Project
4 CAMBRIDGE GATE

Project address
4 Cambridge Gate, Regents Park, NW1 4JX

Client
PRIVATE

Sheet number
1089 -GA - 1303


Sheet name
Existing First, Second & Third Floor Lighting Plan

Sheet scale
1:50 @ A1


Date/time
06/09/2022 12:06:54

Rev	Description	Date	Issued	Checked
1	Planning Issue	06/09/2022	PB	TF

 - KEY
- Spotlight
 - Directional Spotlight
 - Wall Light
 - Pendant
 - Bulkhead Light
 - Strip Light



Scale Bar: 1:50 @ A1 (Metres)

 

Project status Planning

GENERAL NOTES:

This drawing is not for construction and is for information purposes only. Contractor to provide detailed design and construction information. This drawing is to be read in conjunction with all relevant architects' and engineers' drawings and specifications. Drawings to be read in line with the approved inspectors plan check and all dimensions to be checked on site with any discrepancies reported to the architect.

OS information not accurate and not to be used for measurements.

Dowen Farmer Architects Ltd is incorporated in England & Wales. Company registration number 10861309.