



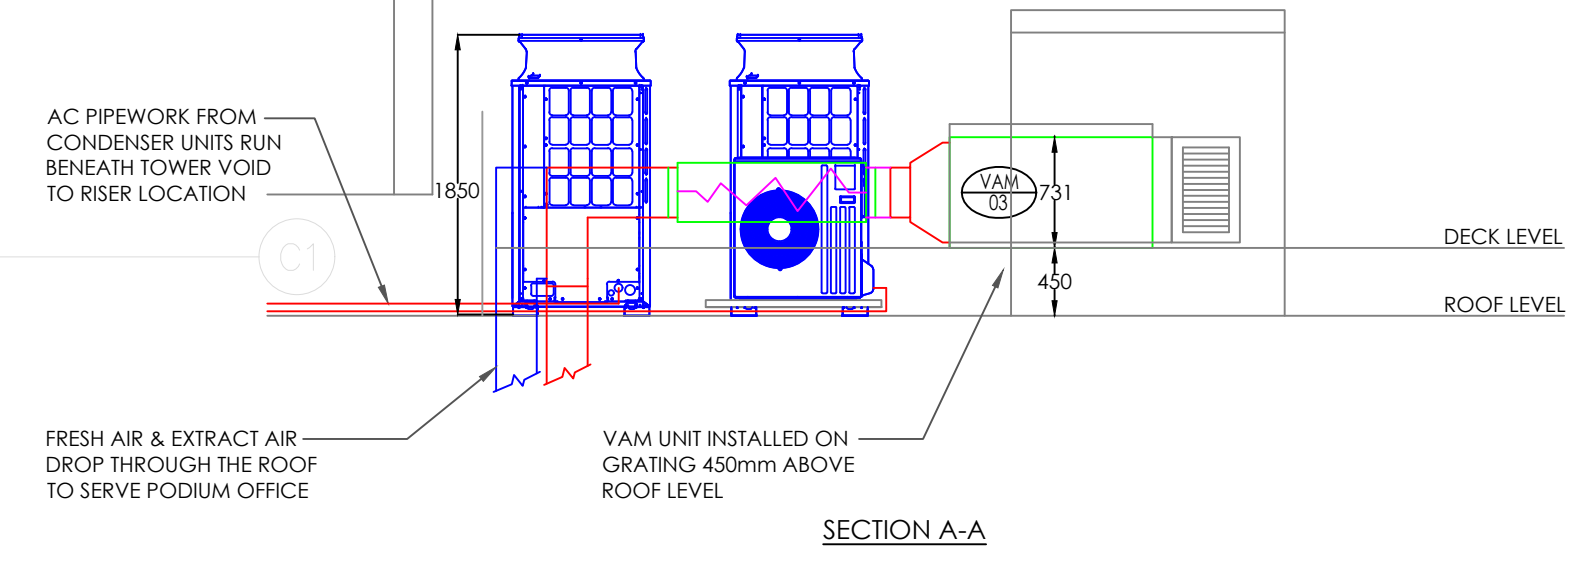

C2	CONSTRUCTION ISSUE - DIMENSIONS ADDED TO NETWEST MECHANICAL PLANT SPACE	TT	DEC 2021
C1	CONSTRUCTION ISSUE	WHG	NOV 2021
T4	TENDER ISSUE - SECTION A-A ADDED TO DRAWING	TT	SEPT 2021
T3	TENDER ISSUE - AHU AMENDED AND HSBG EQUIPMENT HIGHLIGHTED	TT	SEPT 2021
T2	TENDER ISSUE - FUTURE PODIUM TENANTS PLANT & RISER SPACE IDENTIFIED	TT	JUN 2021
T1	TENDER ISSUE	WHG	JUN 2021

Revisions	Description	Ref	Eng	Date
-----------	-------------	-----	-----	------

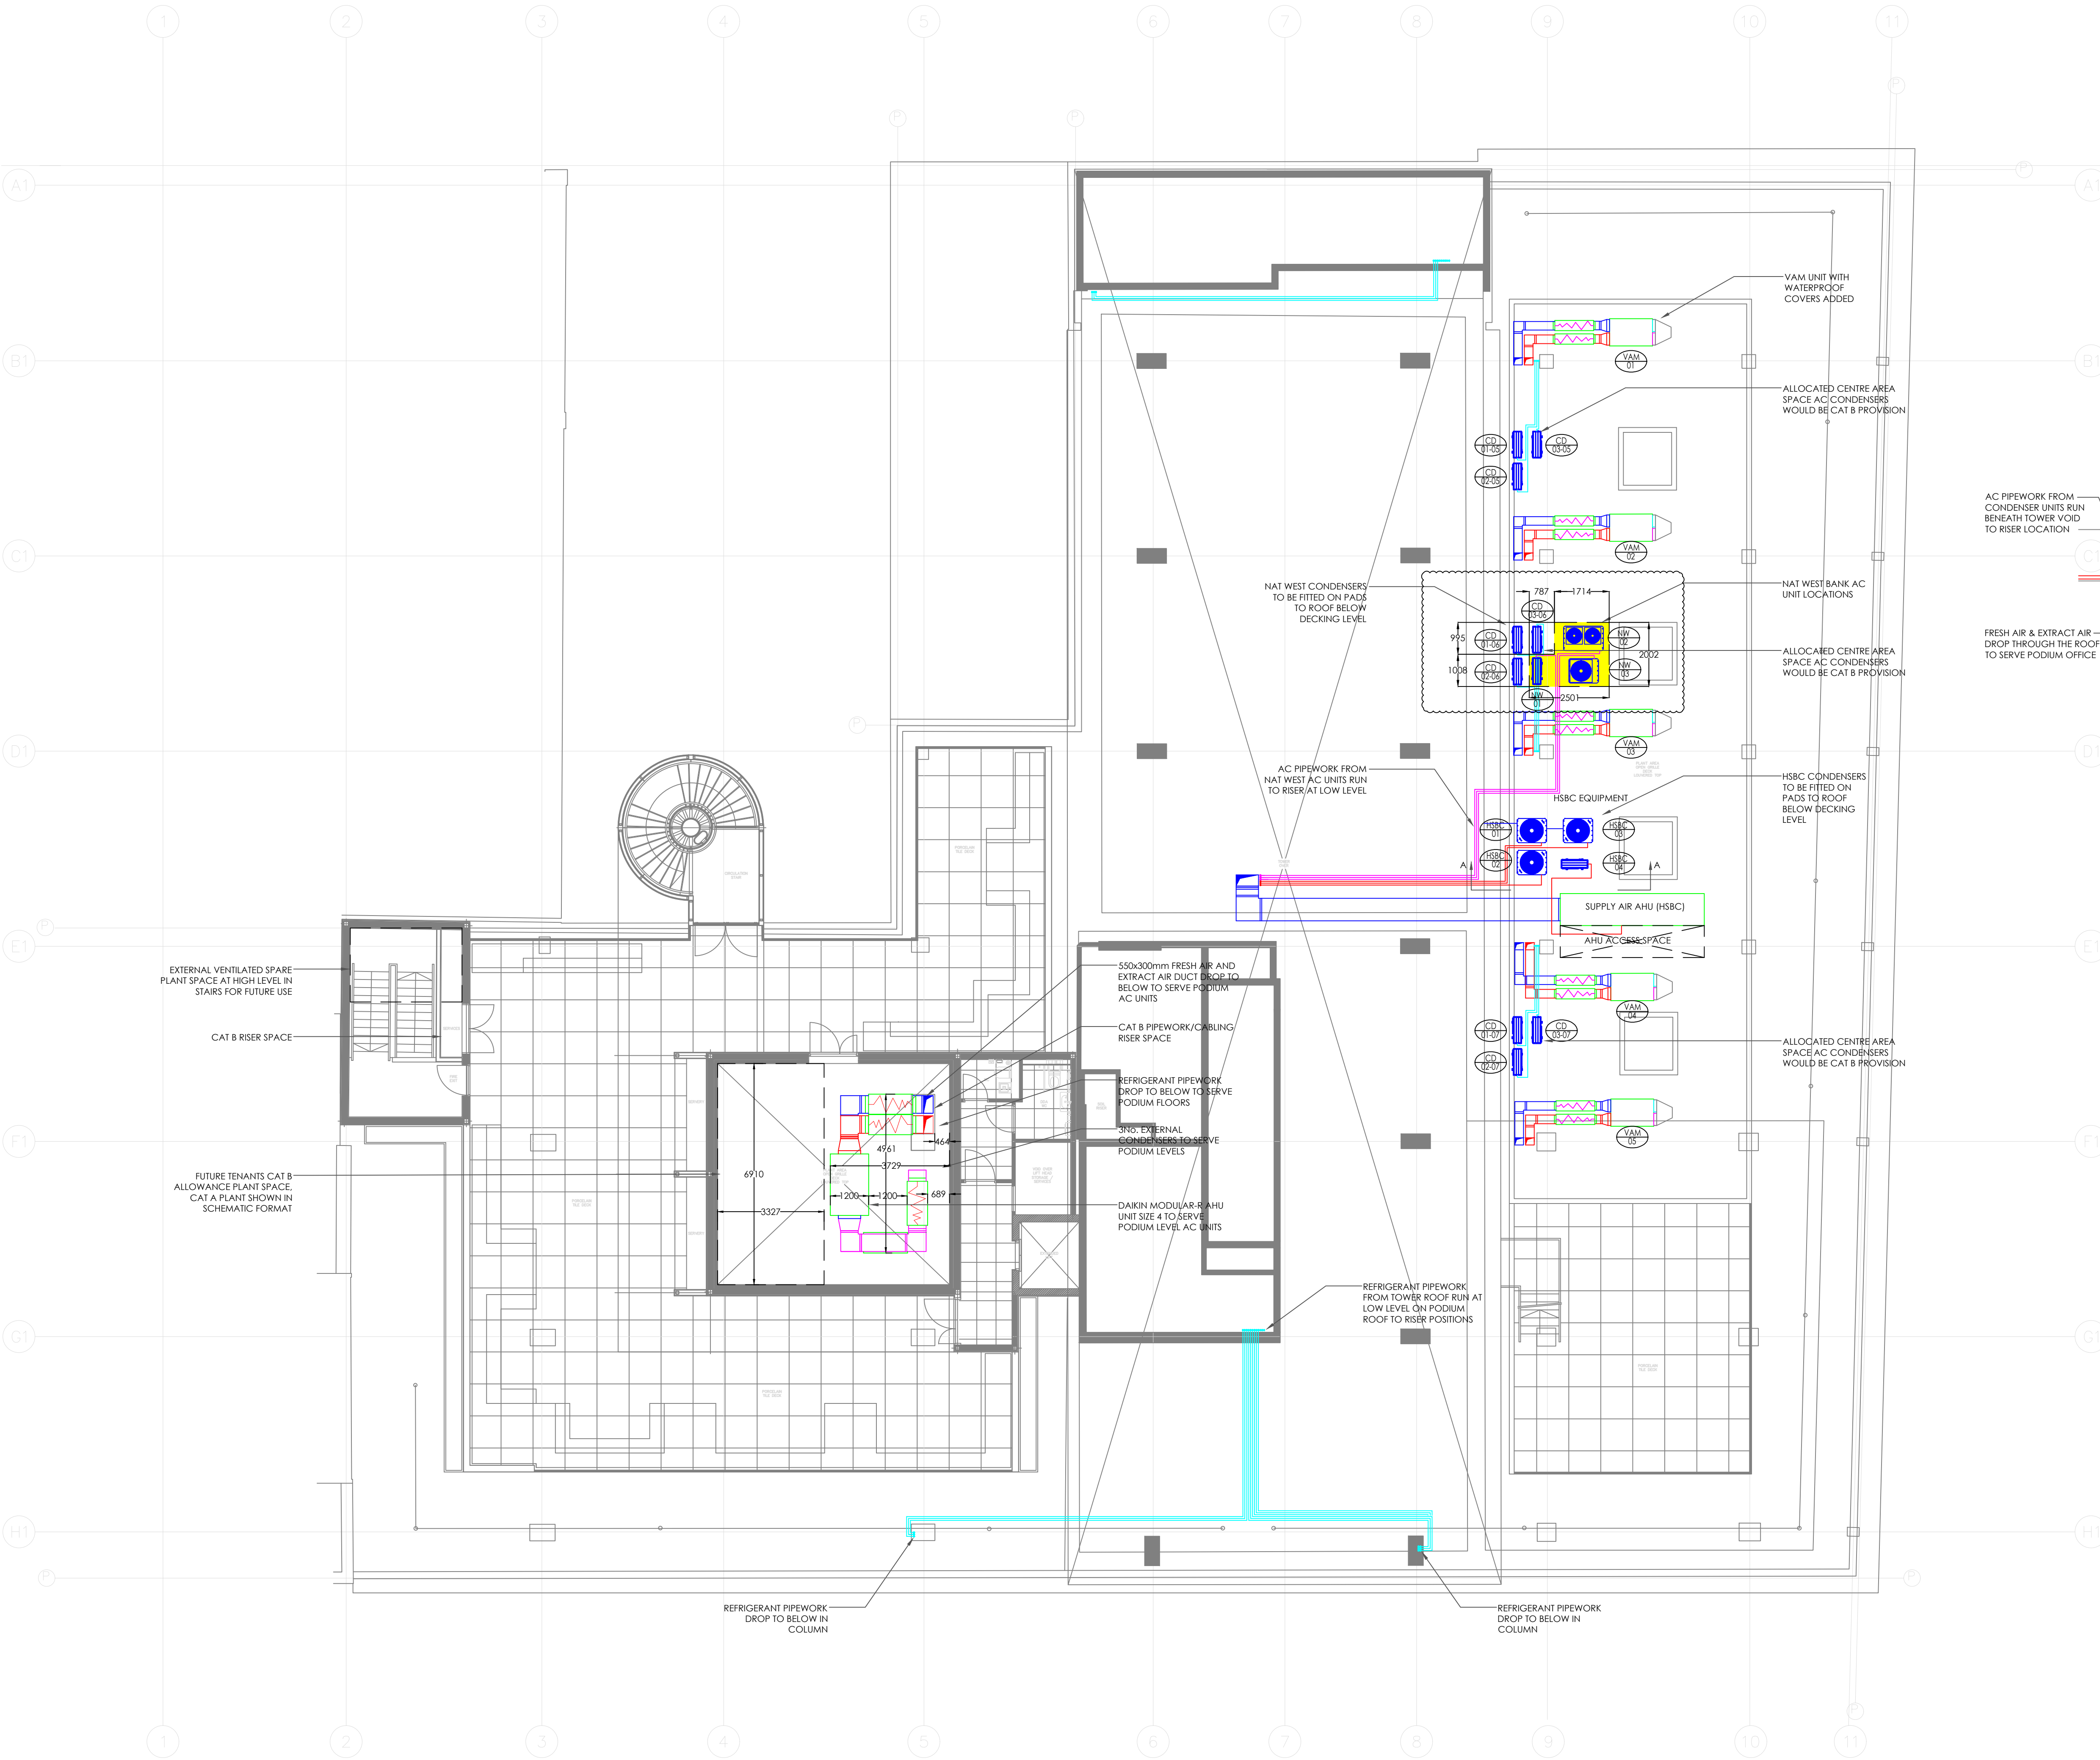

UNIT 5 HOWARTH COURT, GATEWAY CRESCENT, OLDHAM BROADWAY BUSINESS PARK, CHADDERTON, OL9 9XB
Tel: 0161 681 7070
Email: mail@glpartnership.co.uk

Client LAZARI INVESTMENTS LIMITED

Project Title THE MET BUILDING LONDON

Drawing Title THIRD FLOOR ROOF LEVEL MECHANICAL SERVICES LAYOUT

In Association with

Drawn by WHG
Checked by PTK
Date FEBRUARY 2021
Scales 1:100@A1
(work to figured dimensions)

DRG No. 1462-400-09
Rev. C2