


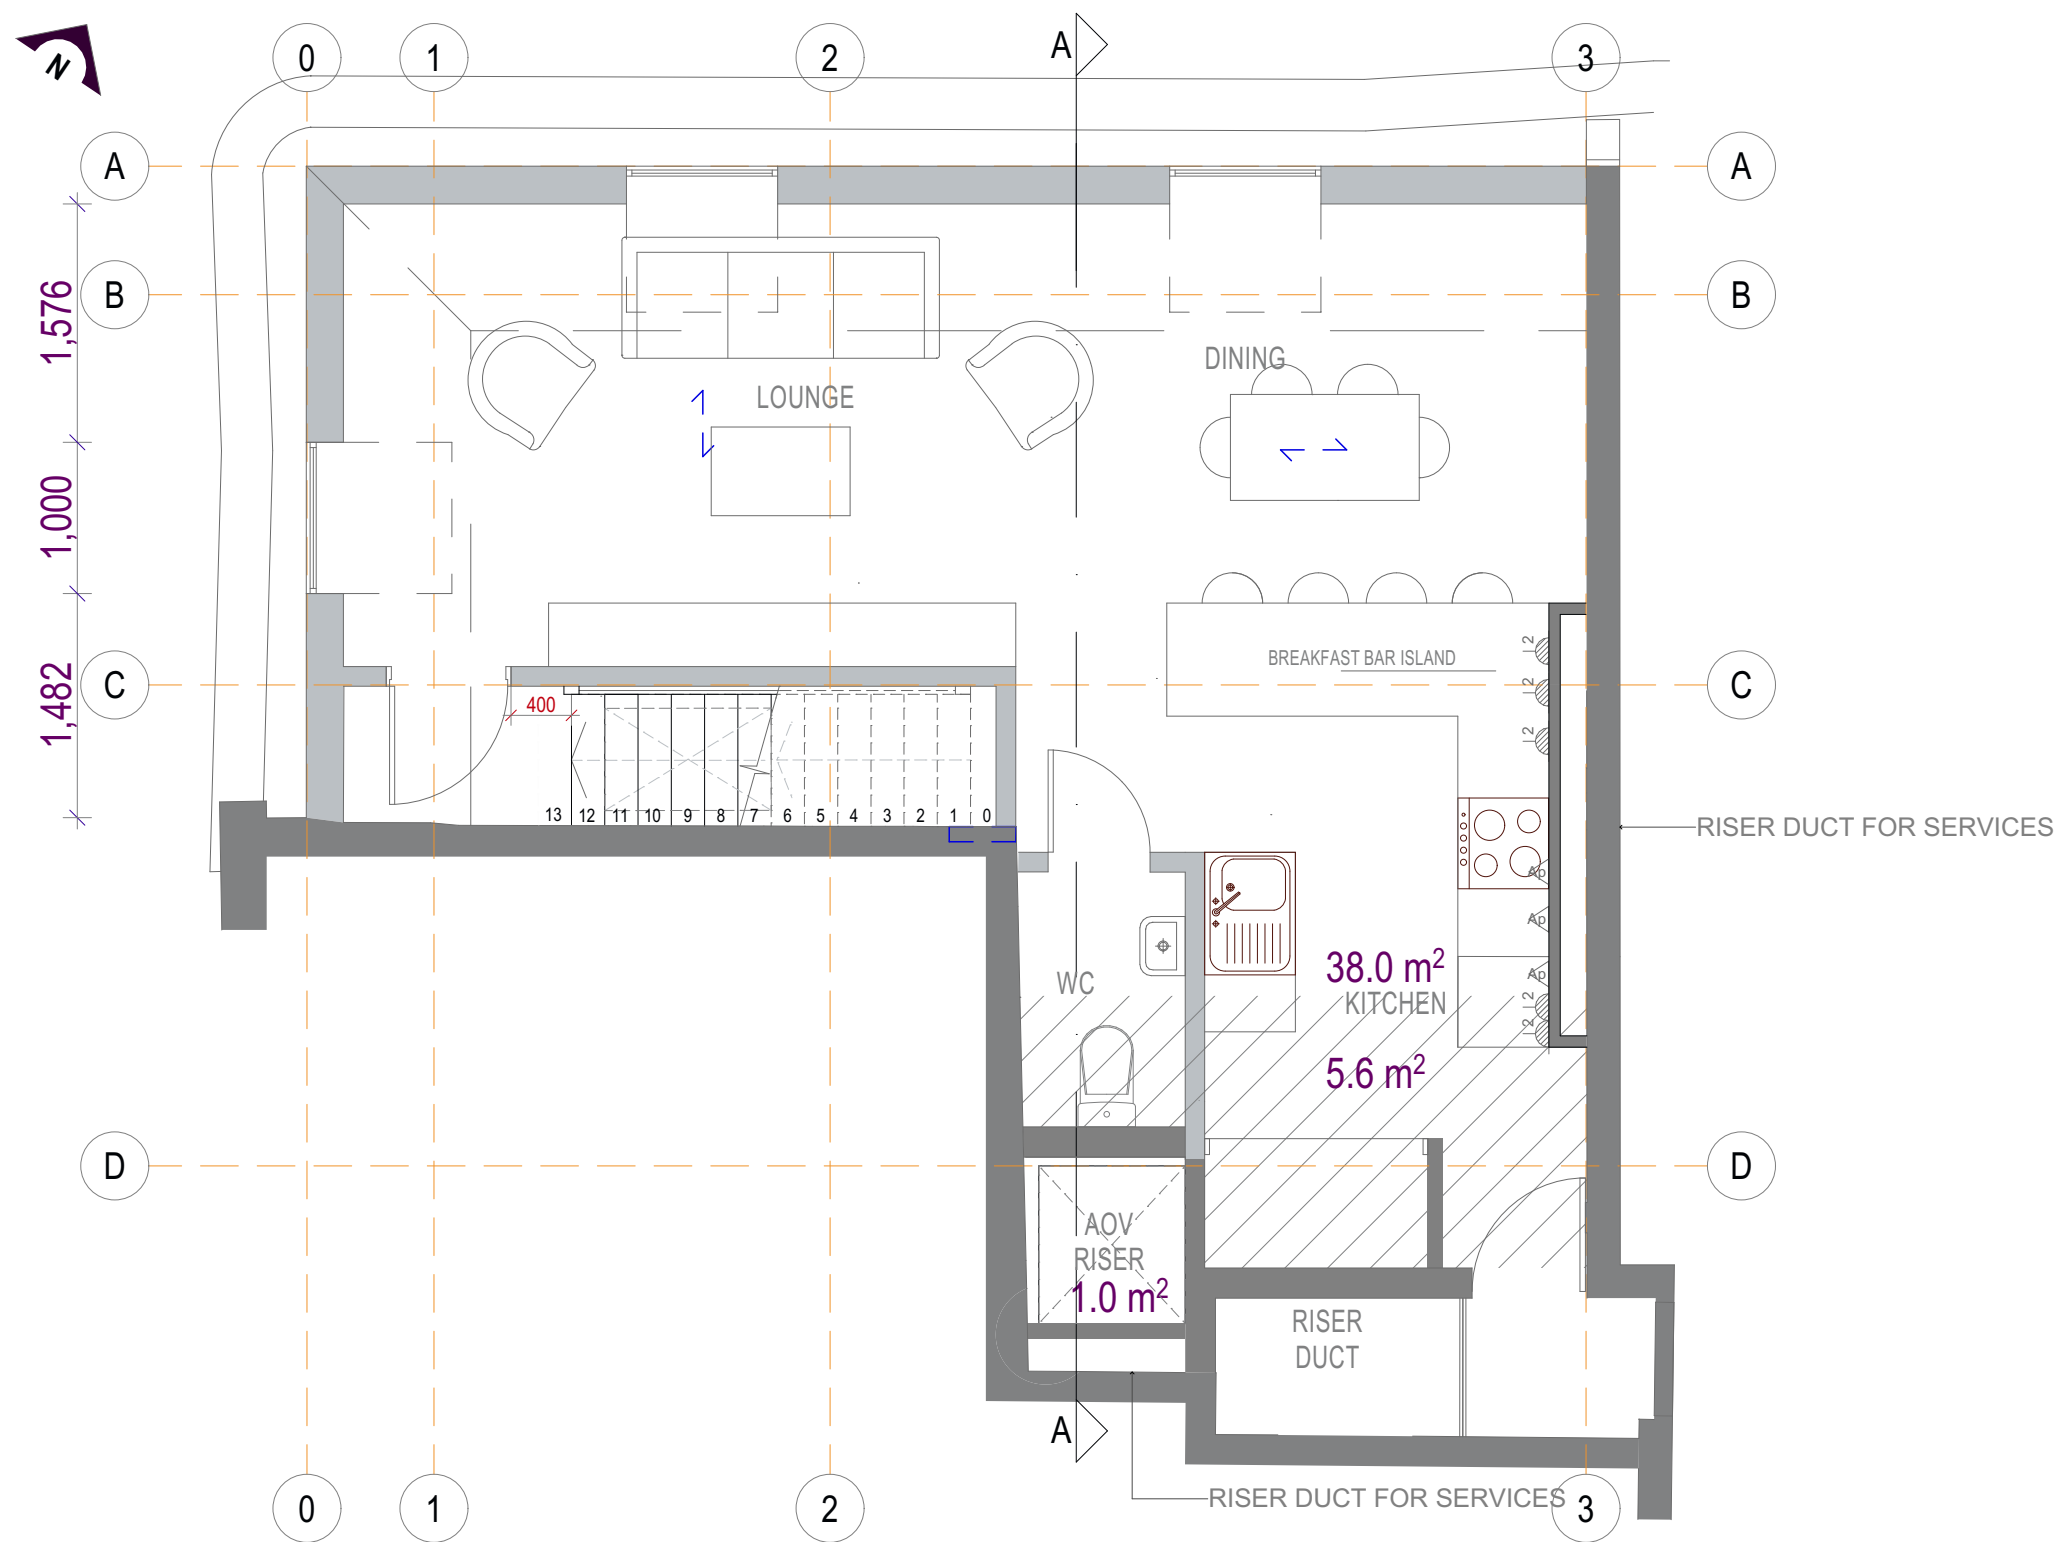

PROPOSED FOURTH FLOOR PLAN

SCALE 1:100/A3

DR NO: 2WS 104

DATE: 09 DECEMBER 2021

REV:G (2022 07 08)



RAIDARCHITECTURE
36 Waterways House
Bentinck Road
West Drayton
UB7 7SG
Website: raidarchitecture.co.uk
info@raidarchitecture.co.uk