



EAGLE STREET TO REAR

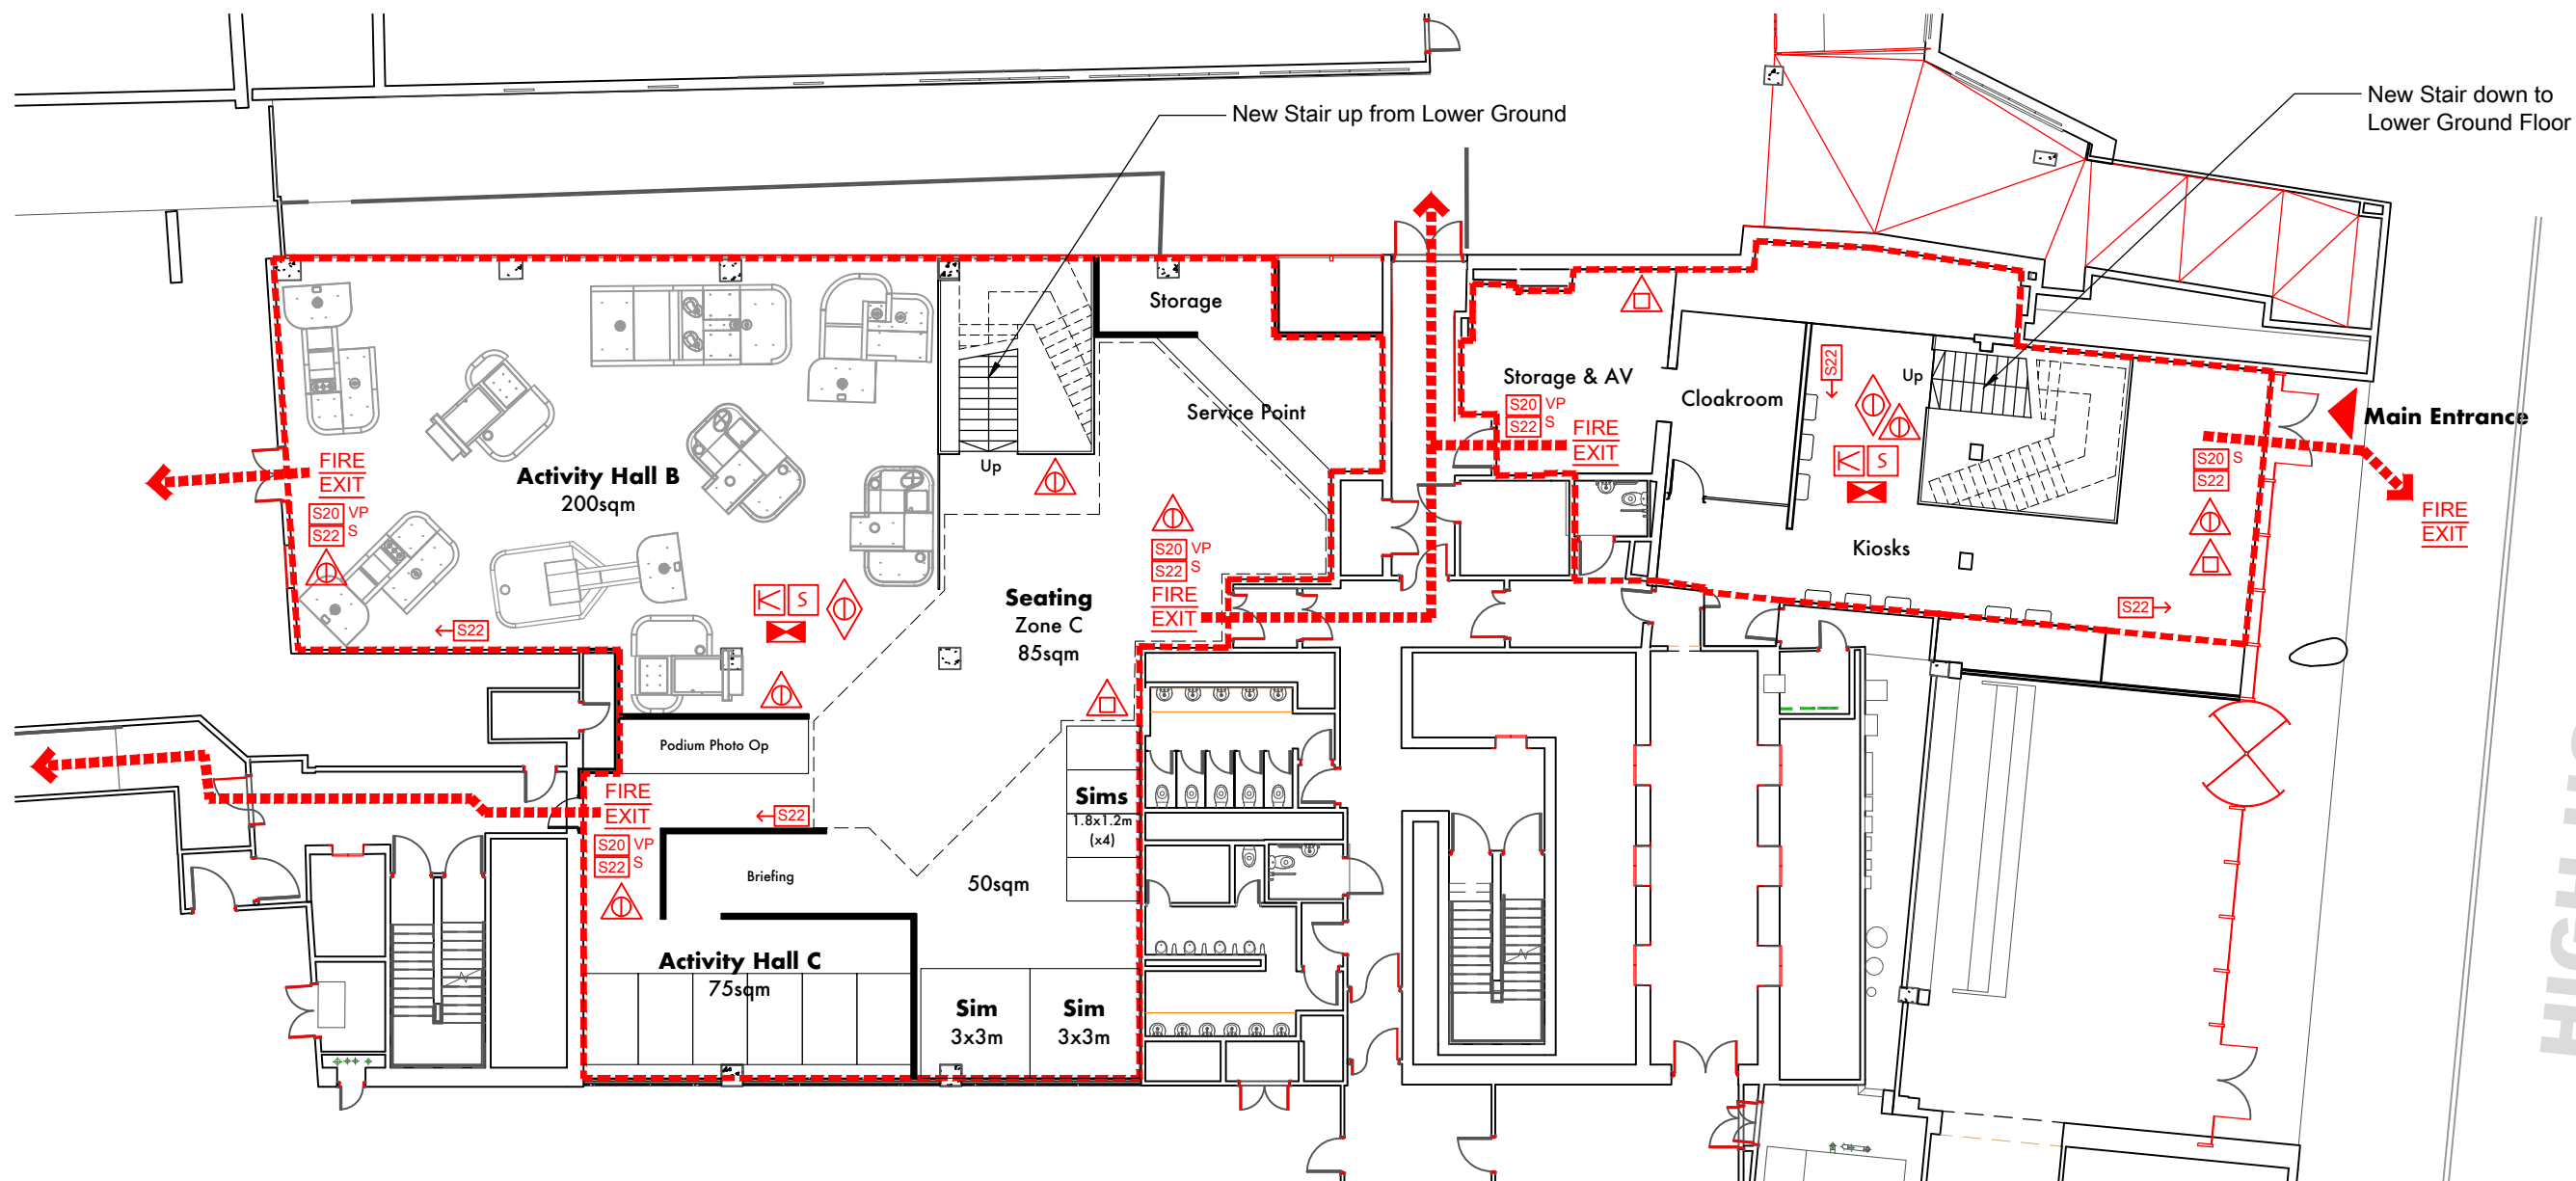

HIGH HOLBORN

Proposed Ground Floor Plan

Scale 1:200@A3

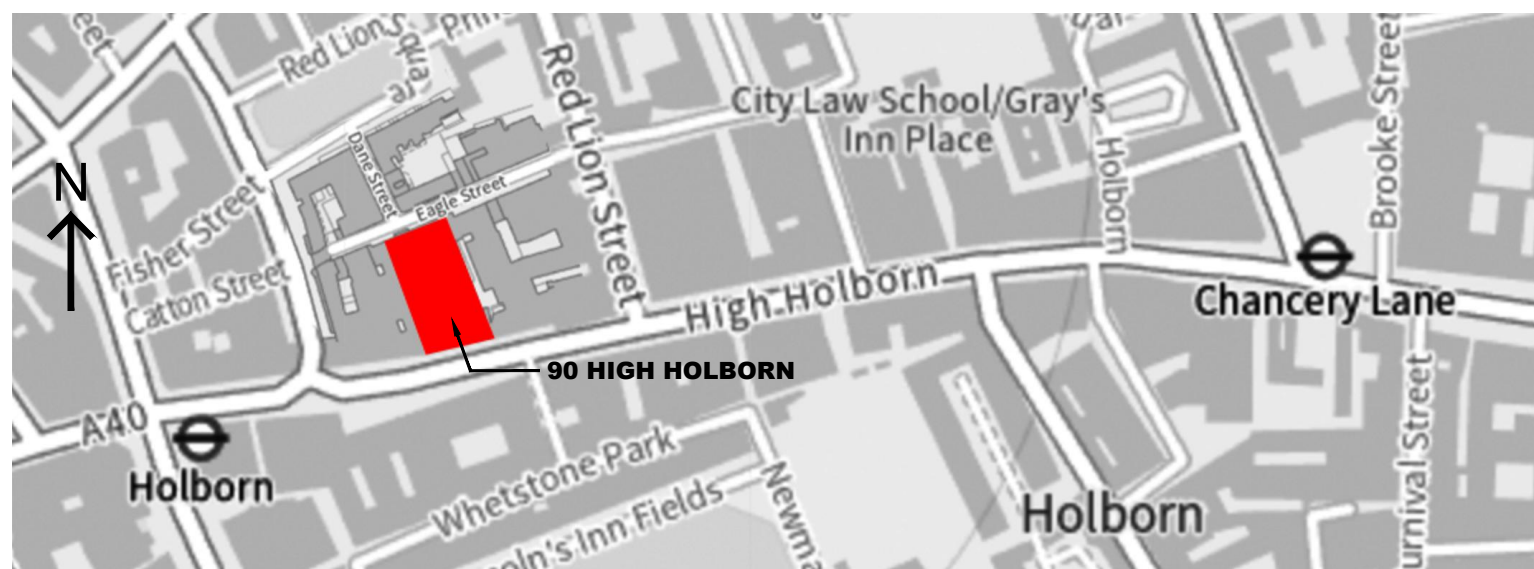

Location Plan

LEGEND	
	Escape Lighting
	Auto Heat Detectors
	Auto Smoke Detectors
	Auto Sprinklers
	Vision Panel
	Smoke Door Assembly
Fire Signage	
	Fire Escape Keep Clear
	Fire Sign
	Directional Arrow
	Aqueous Foam Extinguisher
	Water Fire Extinguisher
	Dry Powder Extinguisher
	Fire Blanket

Rev.	Date	Description
A	10.09.22	General layout update - hall locations and circulation
B	18.10.22	General layout update - hall locations and circulation
C	27.10.22	General layout update, location plan added

Issue		
Preliminary		
Project Name		
90 High Holborn, London		
Drawing Title		
Proposed Ground Floor Plan		
Scale@A3		
As shown		
Drawing No.	Drawn By.	Rev.
QX_HH_22_001	AL	C