



Knightsbridge GRP Planter in Faux Lead




Grosvenor GRP Planter in Faux Lead




RAL 100 60 10




RAL 7002 Olive Grey

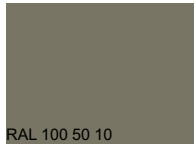

RAL 100 50 10

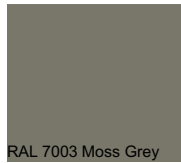

RAL 7003 Moss Grey

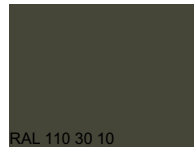

RAL 110 30 10

Alternative Finishes for Planters




Diamond Trellis Panels Set Between Brick Pillars



Vande Moortel Clay Pavers Laid on edge in a 45° Herringbone Pattern with an edging course in Soldier Bond.




Bespoke Slatted Wheelie Bin Store in Cedar

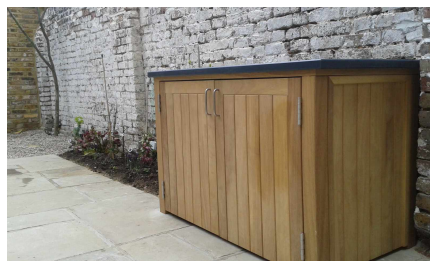

Bespoke Wheelie Bin Store in Iroko


OR Possibly Painted to Match Planters

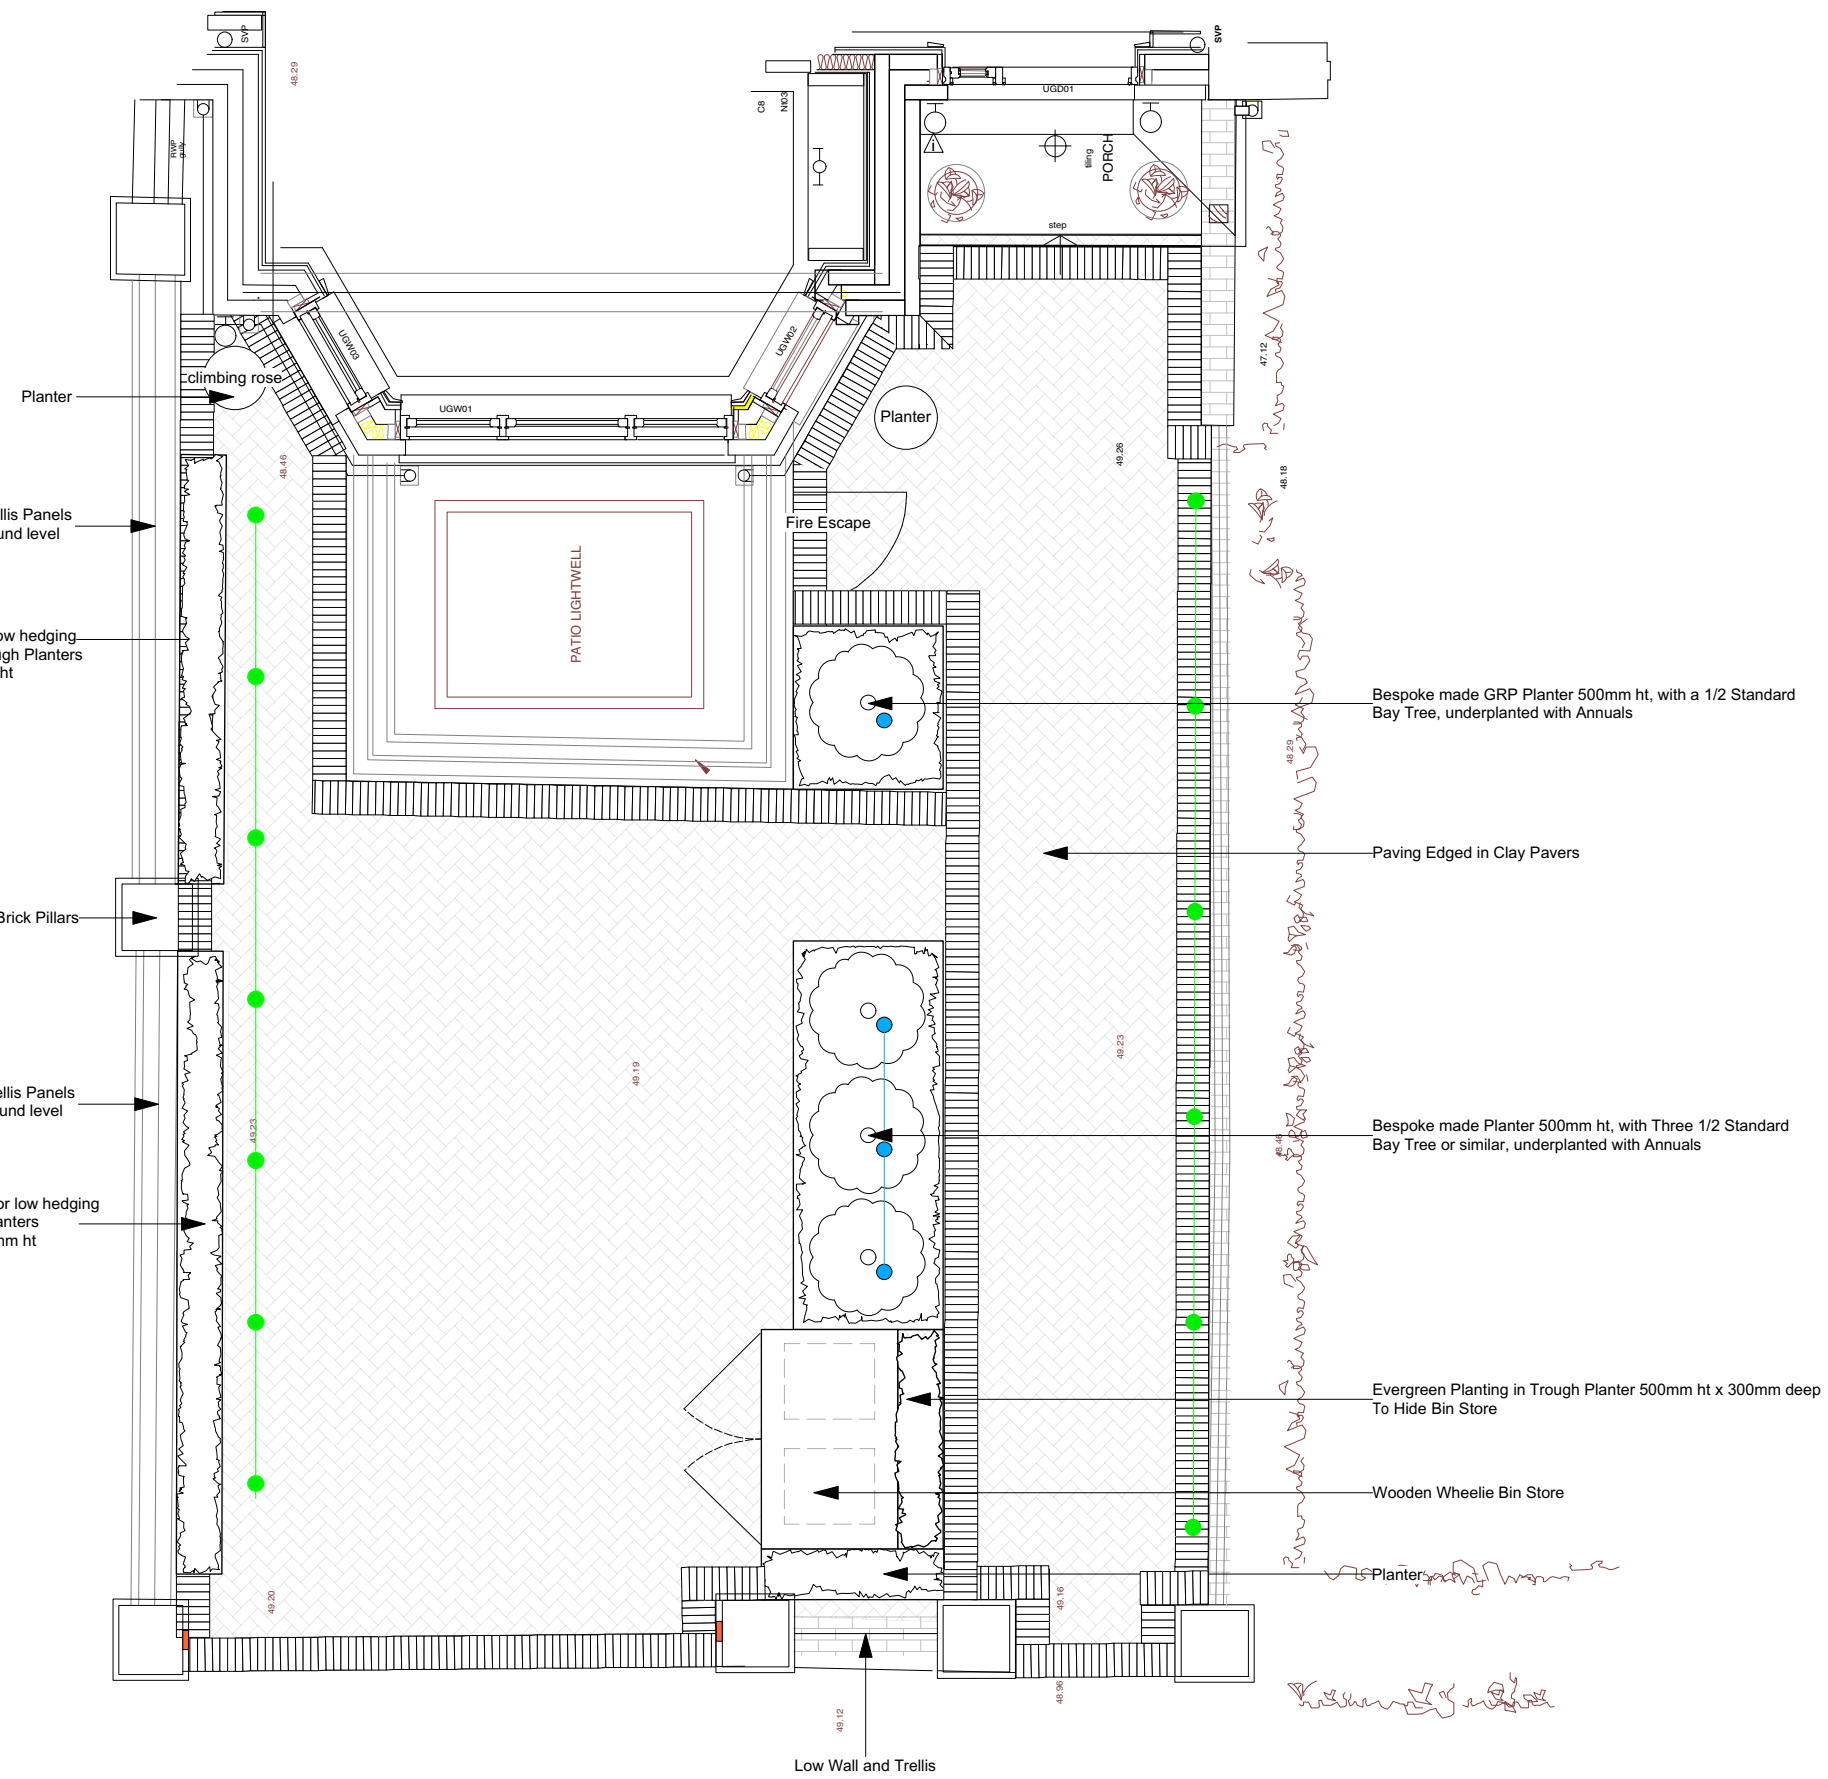

LIGHT FITTINGS




Light Visuals LV-CU802 Spike Light - Solid Copper Warm White Lamp with 32° Beam Angle

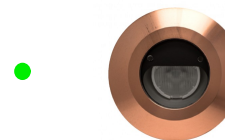


LuxR Modux Two Wall Washer in Copper Positioned 150mm centres from wall and planters



LED Hardscape Landscape Light 2700K- 100L- 178mm long x 20mm deep- Part Number: HRD1W527KW1-6002 To sit hidden beneath stone pillar cap. TBC

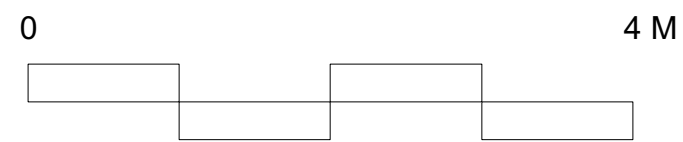

Scale @ 1:50

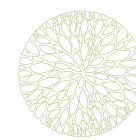

AMANDA BROUGHTON
GARDEN DESIGN

Tel: 020 8449 5781 • Mobile: 07899 828370
info@abroughtondesign.com • www.abroughtondesign.com

CLIENT NAME	MR & MRS MC DOUGAL
JOB TITLE	FRONT GARDEN
TITLE	LANDSCAPING & LIGHTING PLAN
SCALE	1:50 @ A2
DATE	20.7.21
DRAWING NO	3067/F/LAND/2

All Measurements To Be Checked On Site by Contractors Prior to Construction