
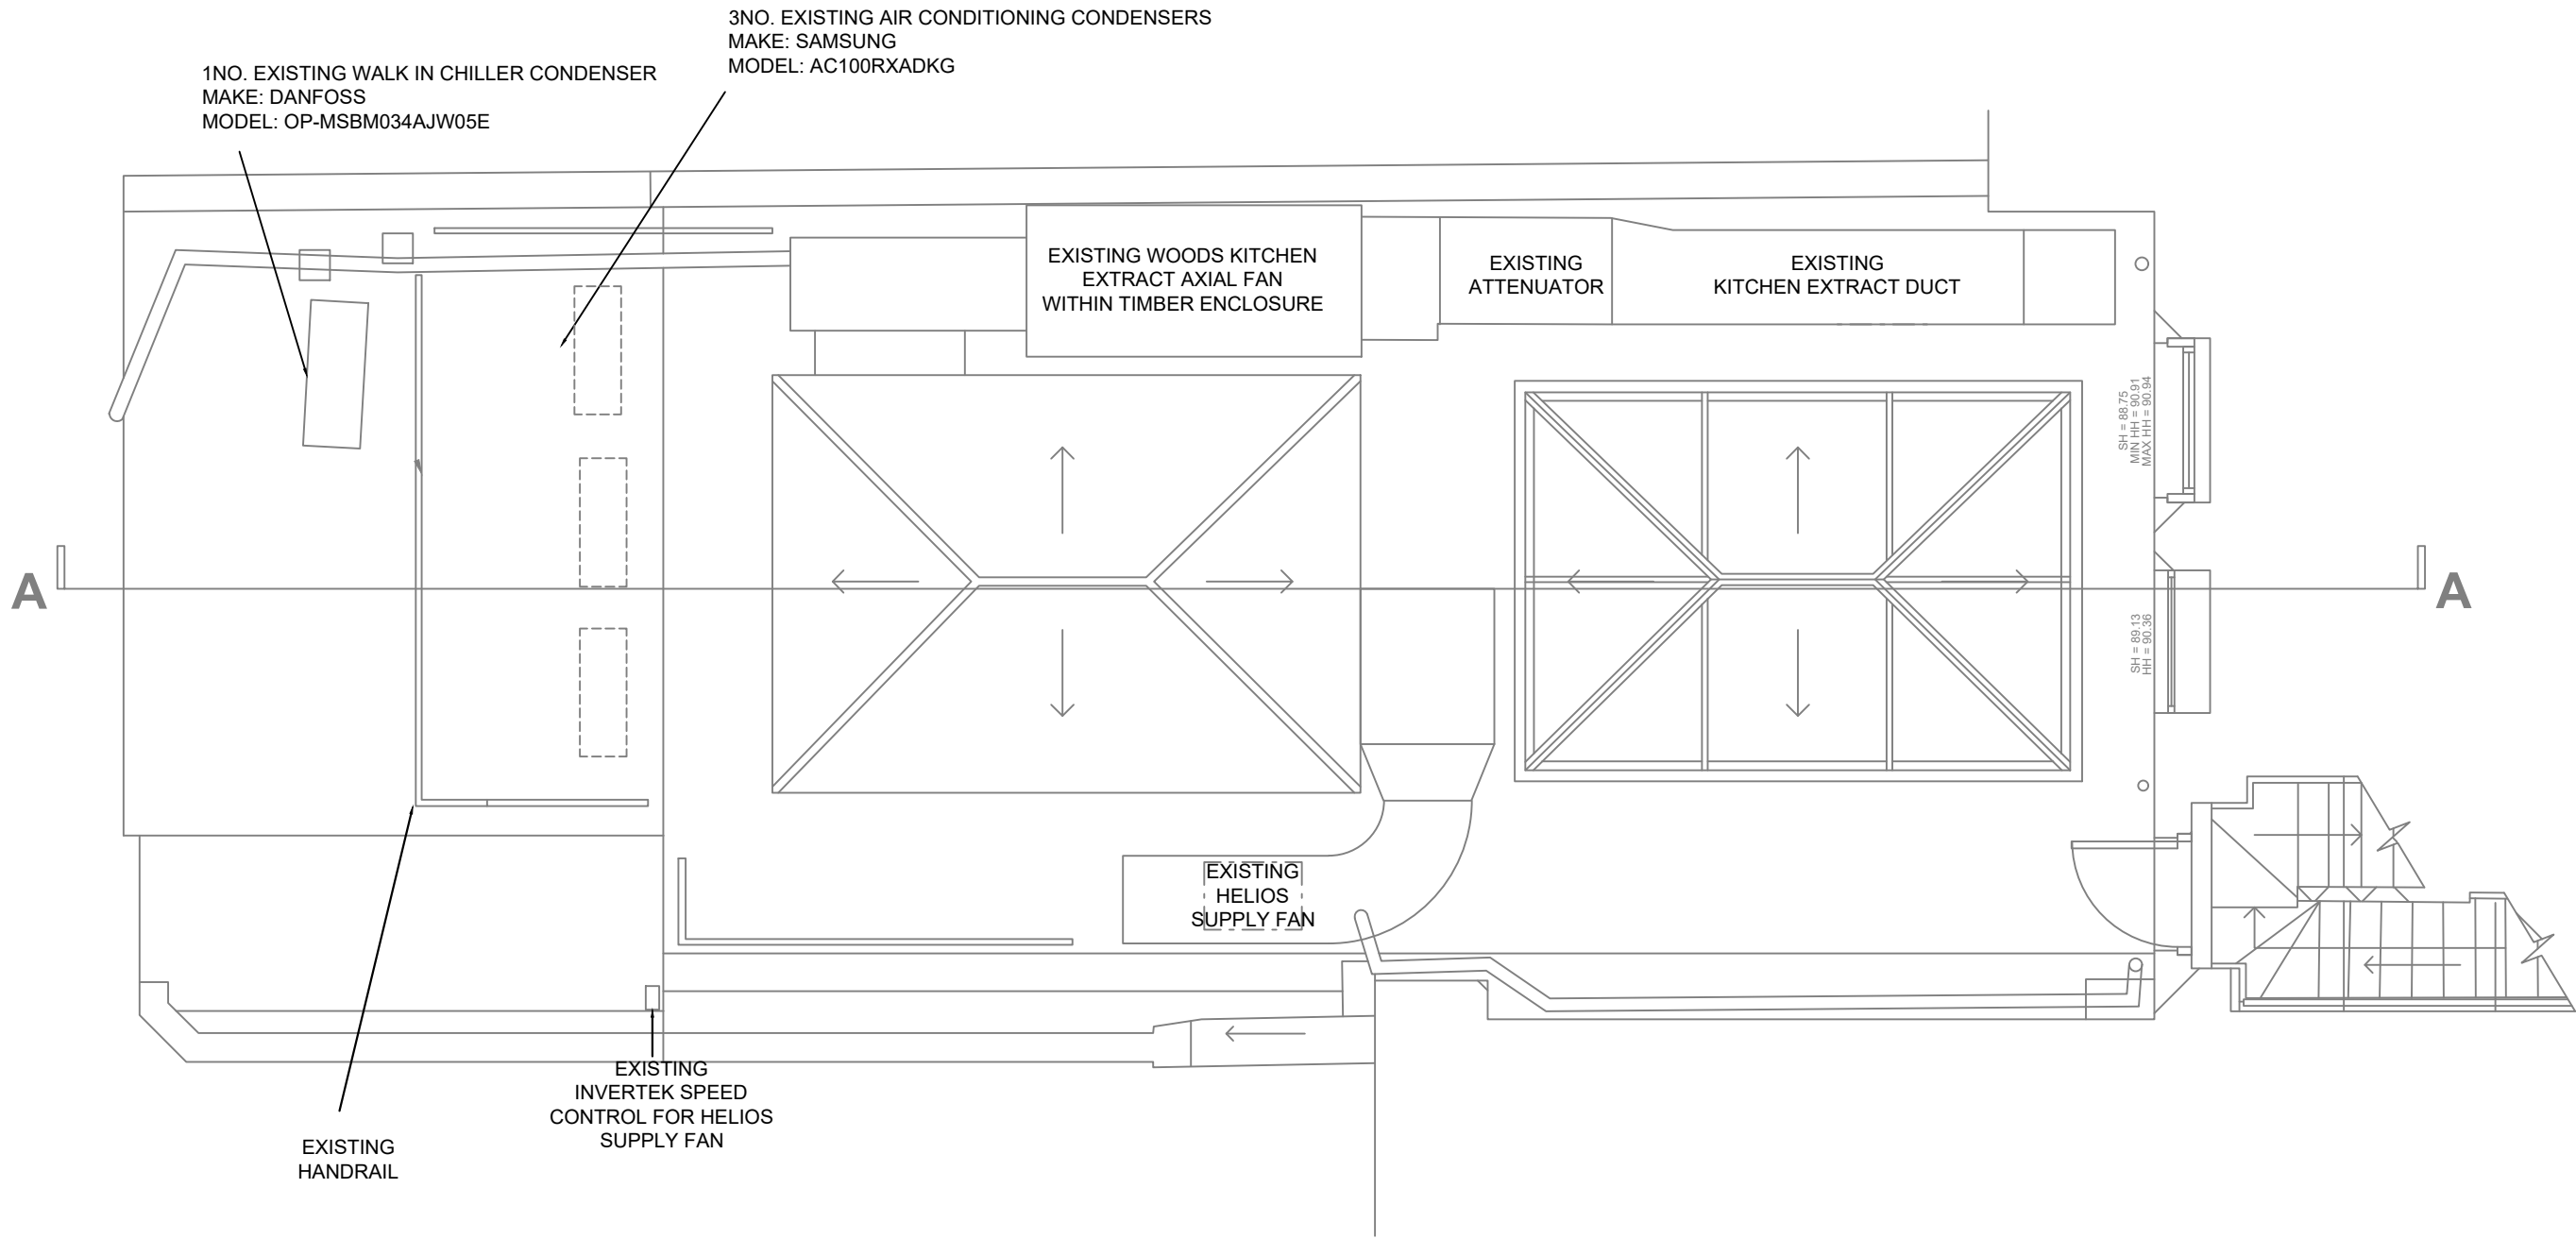


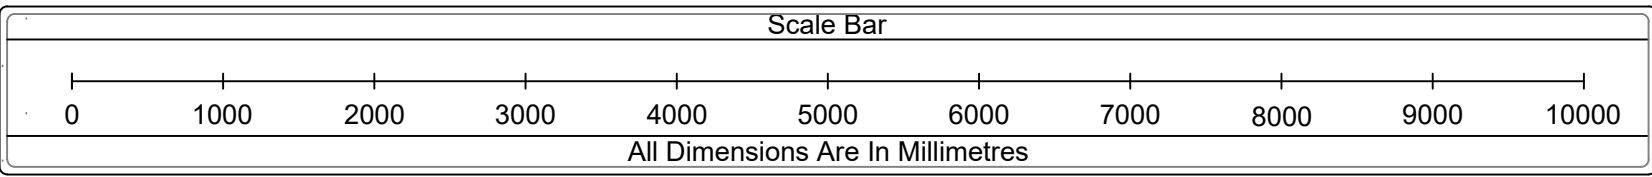

EXISTING REAR ROOF PLAN
WITH KOJO HVAC PLANT

NOTES

DUCTWORK COLOUR KEY

- EXTRACT EXHAUST AIR
- EXTRACT RETURN AIR
- FRESH AIR SUPPLY (PRIMARY)
- FRESH AIR INLET
- AC SUPPLY AIR (SECONDARY)
- TOILET EXTRACT

REV	REVISION DESCRIPTION	REV DATE

Spiritus
Technical Services Ltd

1 BRADDOCK COURT
BASINGSTOKE
HAMPSHIRE
RG21 6AS



M:07889 605592
E: CRAIG@SPIRITUSTECHNICALSERVICES.CO.UK

CLIENT:
OTTOLENGHI

SITE:
32-34 ROSSLYN HILL
HAMPSTEAD
LONDON
NW3 1NH

DRAWING TITLE:
EXISTING ROOF PLAN
WITH KOJO HVAC PLANT

DRAWN BY: CB	DATE: 01.10.2022	SCALE: 1:50 @ A1
DRAWING NUMBER: STS0870-M01		REVISION: -
DRAWING STATUS: FOR APPROVAL		

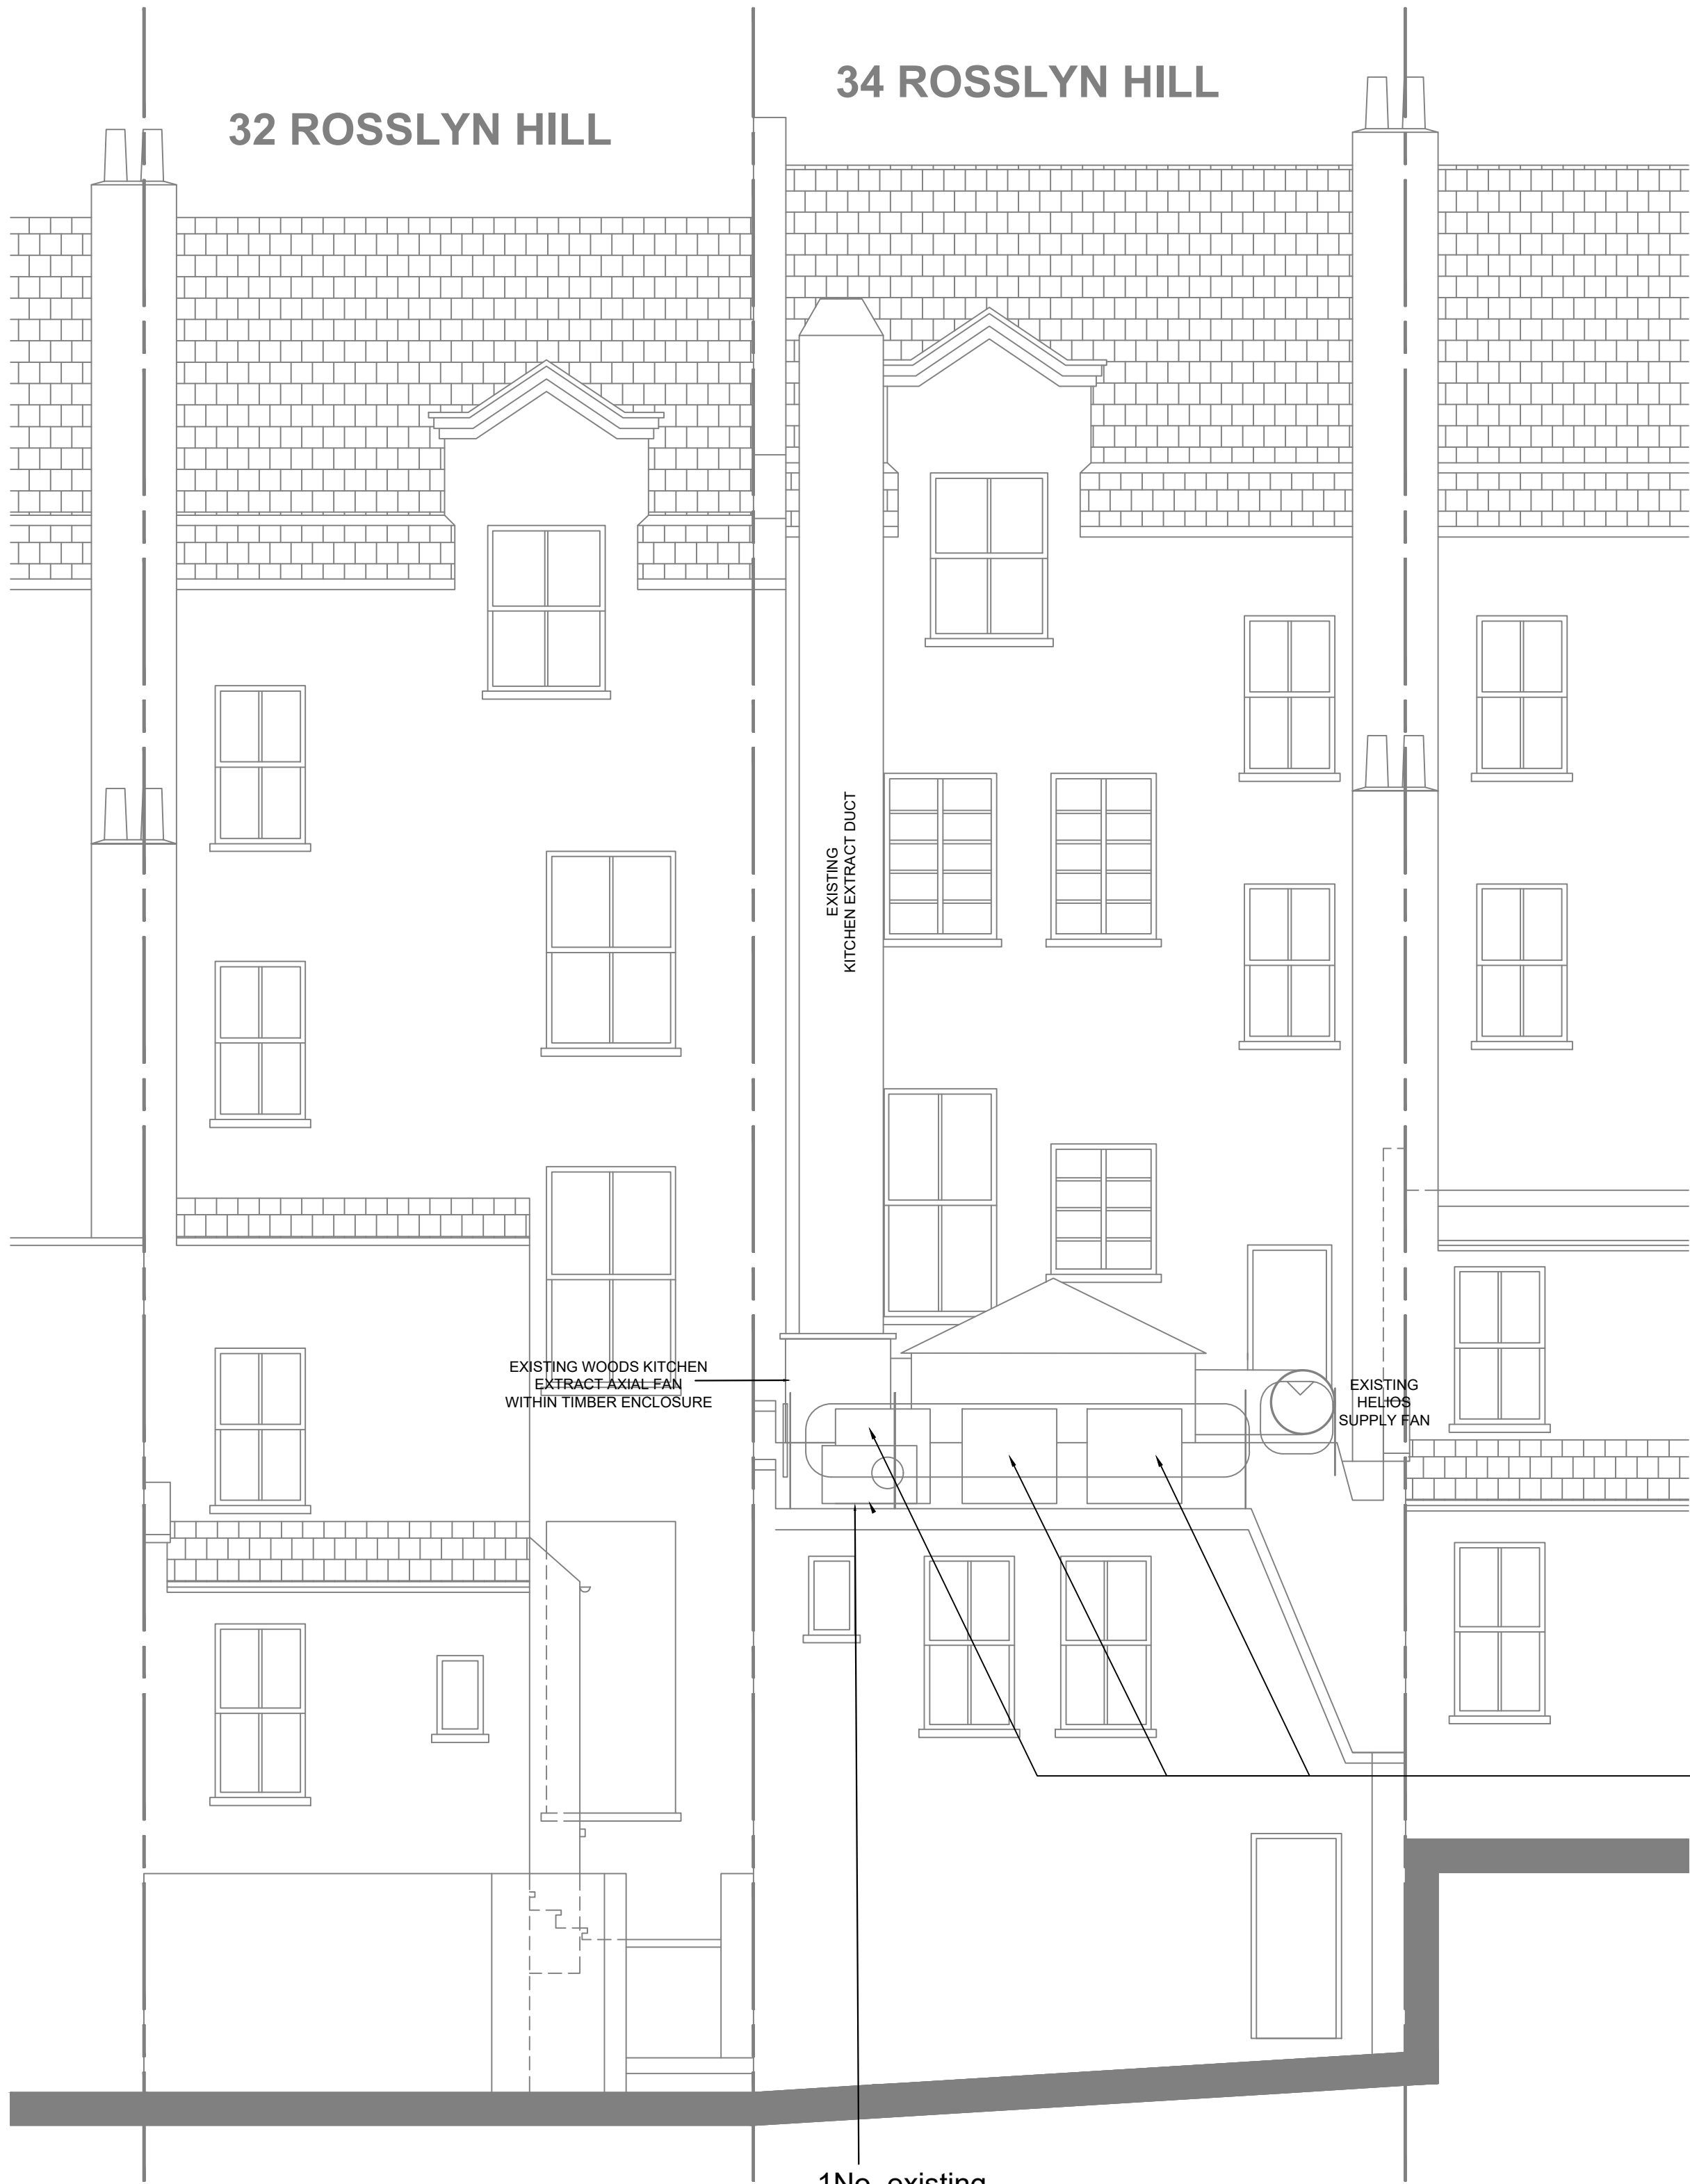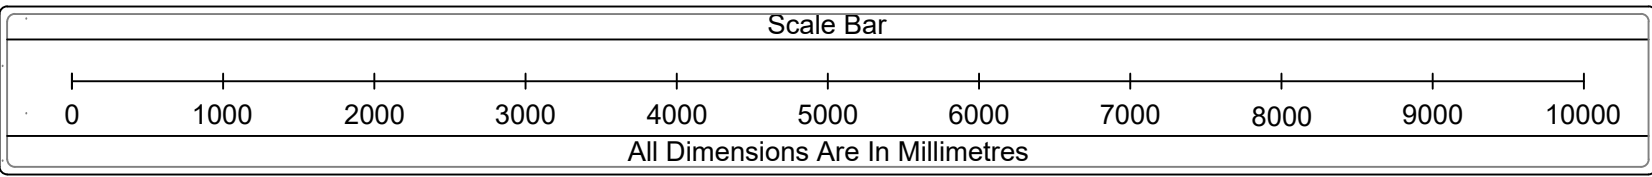

EXISTING REAR ELEVATION
WITH KOJO HVAC PLANT

NOTES

DUCTWORK COLOUR KEY

- EXTRACT EXHAUST AIR
- EXTRACT RETURN AIR
- FRESH AIR SUPPLY (PRIMARY)
- FRESH AIR INLET
- AC SUPPLY AIR (SECONDARY)
- TOILET EXTRACT

REV	REVISION DESCRIPTION	REV DATE

Spiritus
Technical Services Ltd

1 BRADDOCK COURT
BASINGSTOKE
HAMPSHIRE
RG21 6AS



M:07889 605592
E: CRAIG@SPIRITUSTECHNICALSERVICES.CO.UK

CLIENT:
OTTOLENGHI

SITE:
32-34 ROSSLYN HILL
HAMPSTEAD
LONDON
NW3 1NH

DRAWING TITLE:
EXISTING REAR ELEVATION
WITH KOJO HVAC PLANT

DRAWN BY: CB	DATE: 01.10.2022	SCALE: 1:50 @ A1
DRAWING NUMBER: STS0870-M03	REVISION: -	
DRAWING STATUS: FOR APPROVAL		

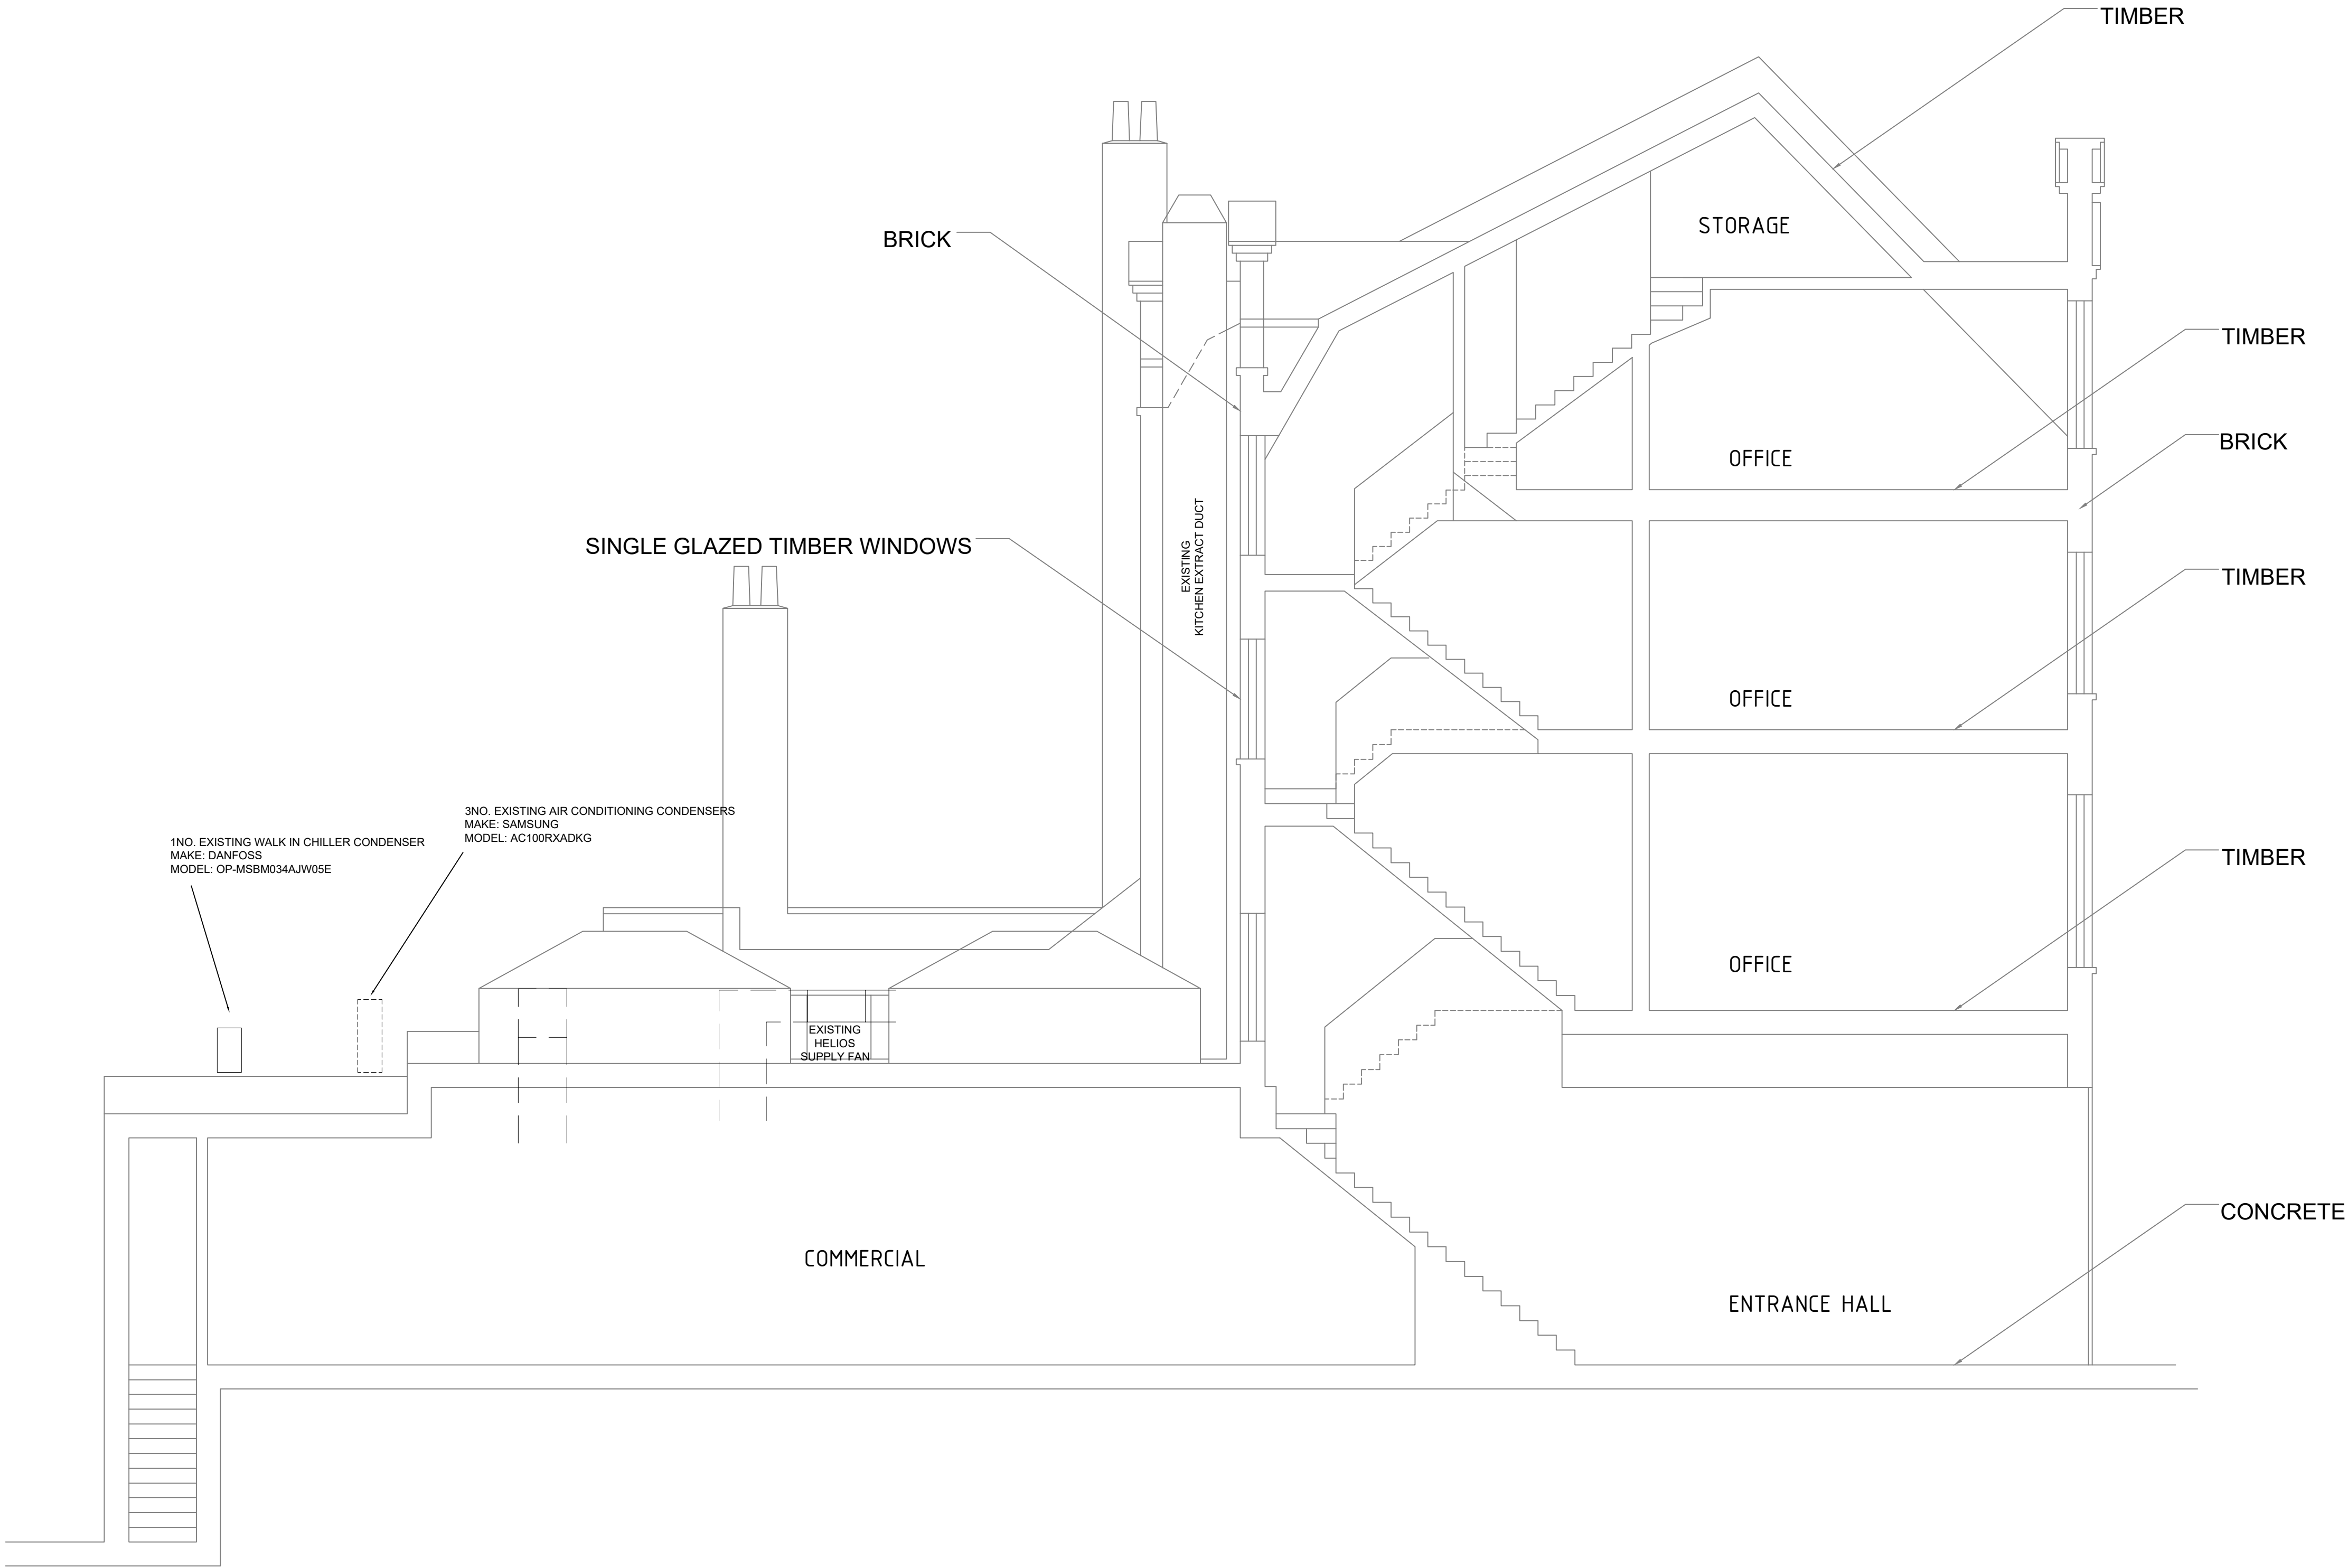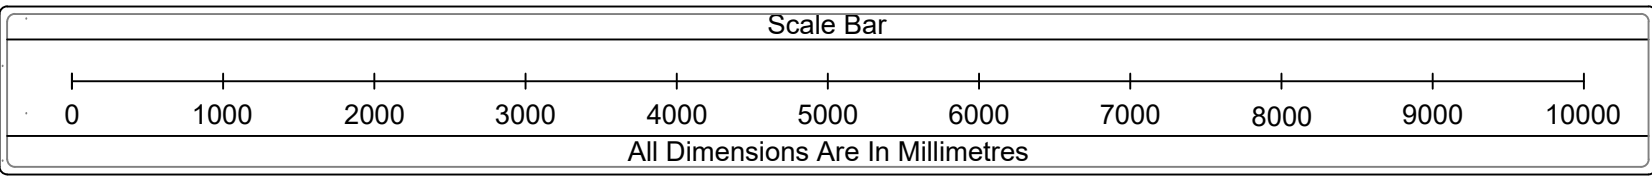

EXISTING SECTION A-A
WITH KOJO HVAC PLANT

NOTES

DUCTWORK COLOUR KEY

- EXTRACT EXHAUST AIR
- EXTRACT RETURN AIR
- FRESH AIR SUPPLY (PRIMARY)
- FRESH AIR INLET
- AC SUPPLY AIR (SECONDARY)
- TOILET EXTRACT

REV	REVISION DESCRIPTION	REV DATE

Spiritus
Technical Services Ltd

1 BRADDOCK COURT
BASINGSTOKE
HAMPSHIRE
RG21 6AS

M:07889 605592
E: CRAIG@SPIRITUSTECHNICALSERVICES.CO.UK

CLIENT:
OTTOLENGHI

SITE:
32-34 ROSSLYN HILL
HAMPSTEAD
LONDON
NW3 1NH

DRAWING TITLE:
EXISTING SECTION A-A
WITH KOJO HVAC PLANT

DRAWN BY: CB	DATE: 01.10.2022	SCALE: 1:50 @ A1
DRAWING NUMBER: STS0870-M04		REVISION: -
DRAWING STATUS: FOR APPROVAL		