
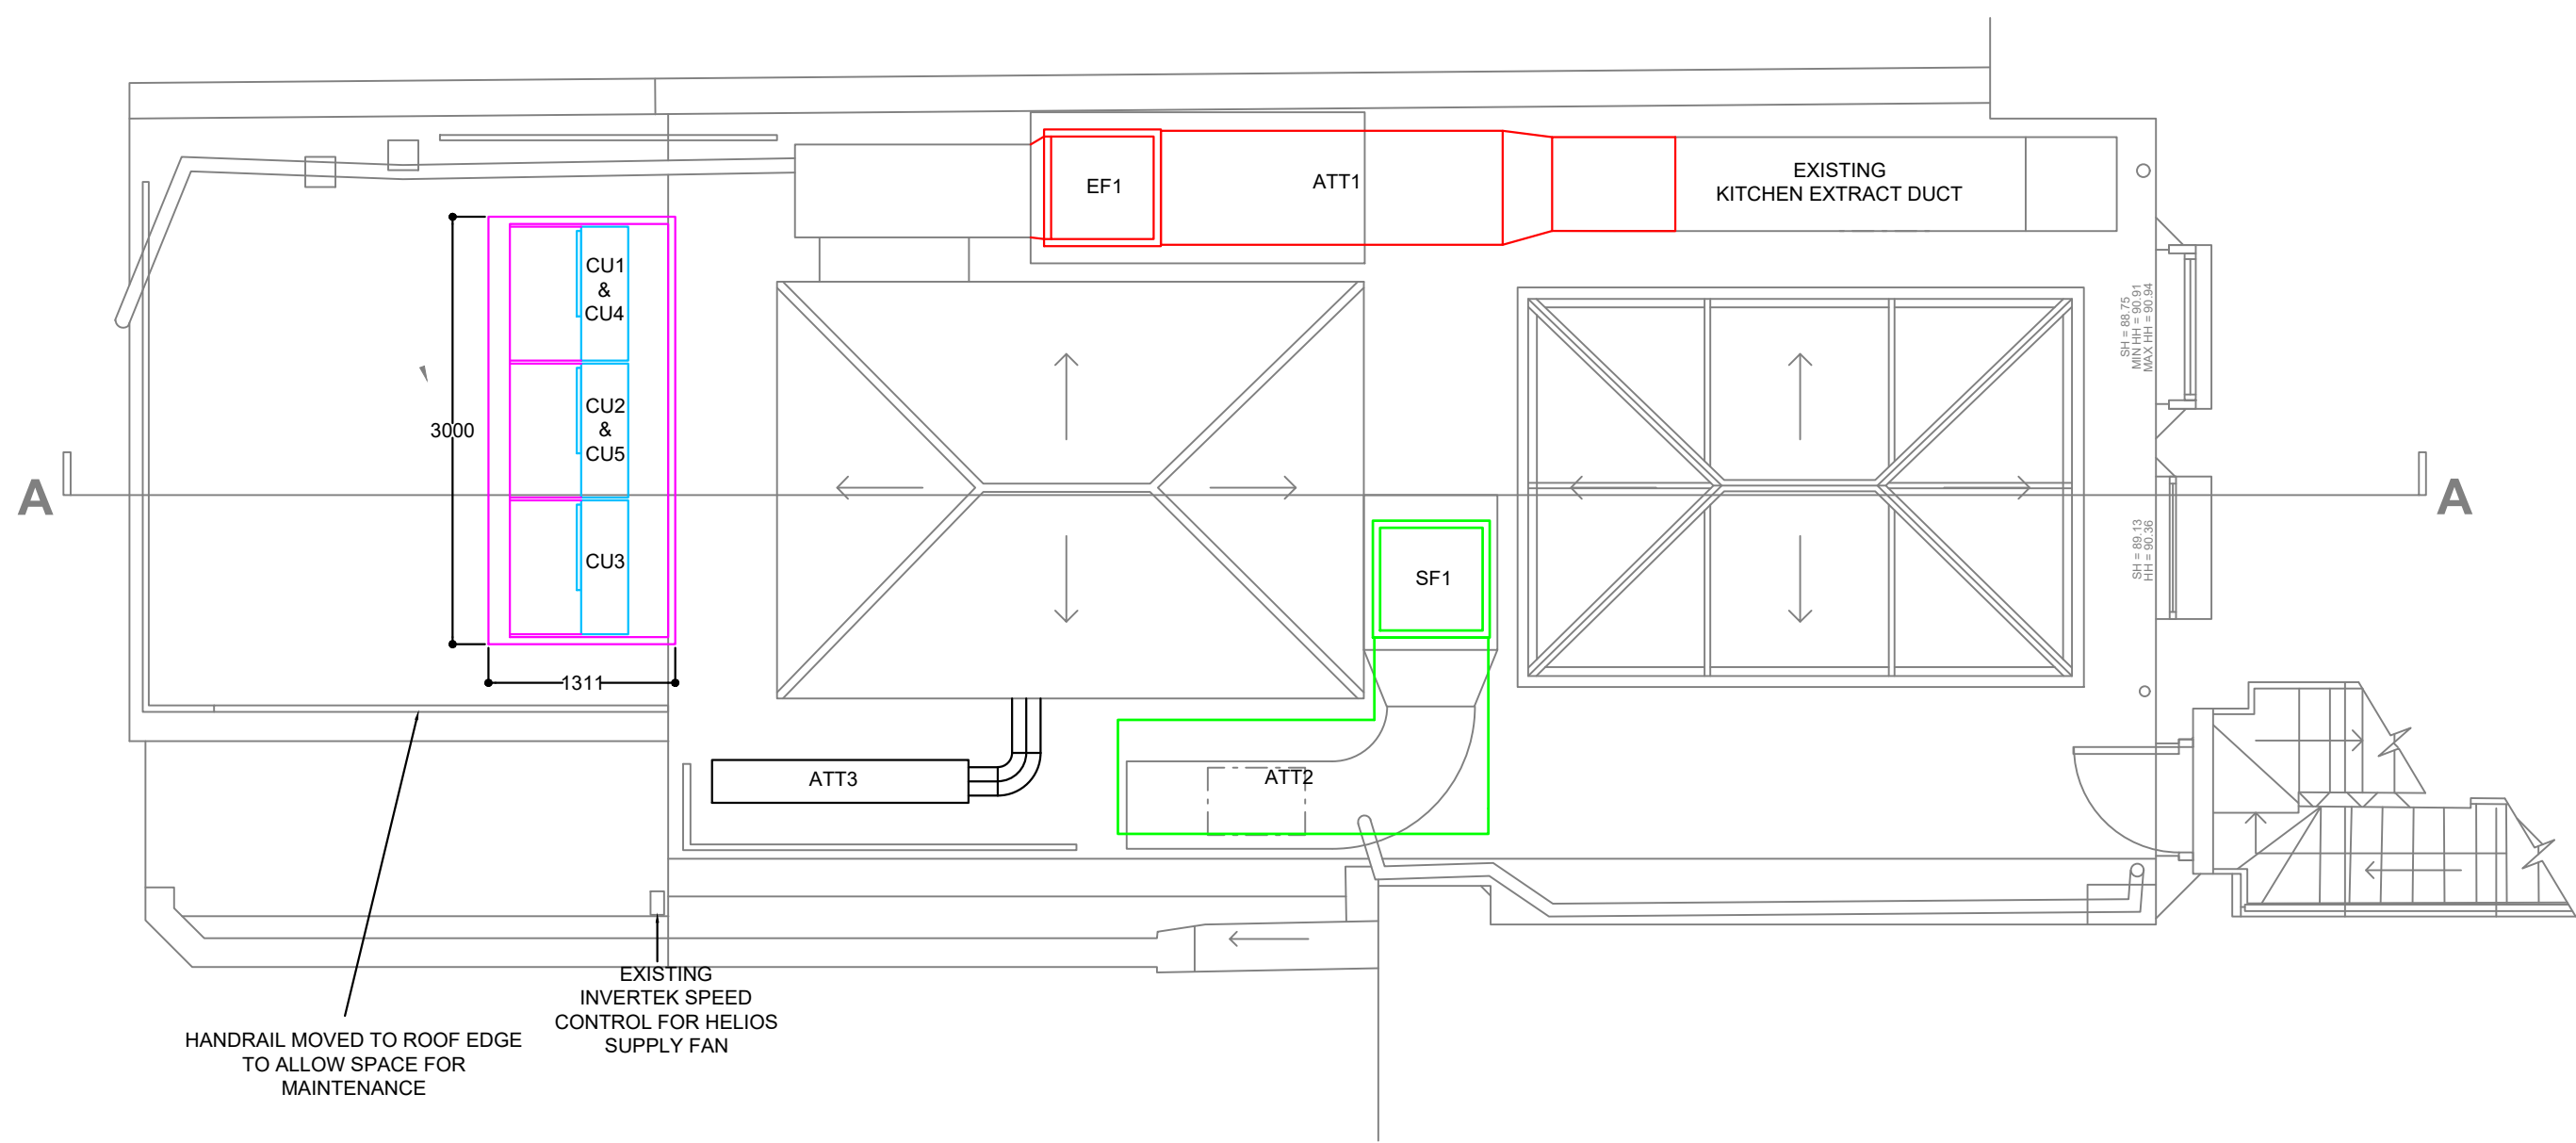


[illegible]

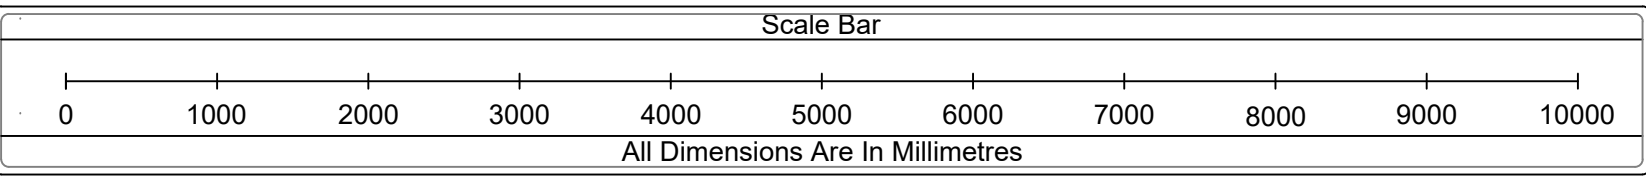

PROPOSED REAR ELEVATION

NOTES

DUCTWORK COLOUR KEY

- EXTRACT EXHAUST AIR
- KITCHRN EXTRACT
- FRESH AIR SUPPLY (PRIMARY)
- FRESH AIR INLET
- AC SUPPLY AIR (SECONDARY)
- TOILET EXTRACT

REV	REVISION DESCRIPTION	REV DATE

Spiritus
Technical Services Ltd

1 BRADDOCK COURT
BASINGSTOKE
HAMPSHIRE
RG21 6AS



M:07889 605592
E: CRAIG@SPIRITUSTECHNICALSERVICES.CO.UK

CLIENT:
OTTOLENGHI

SITE:
32-34 ROSSLYN HILL
HAMPSTEAD
LONDON
NW3 1NH

DRAWING TITLE:
PROPOSED REAR ELEVATION
WITH OTTOLENGHI HVAC PLANT

DRAWN BY: CB	DATE: 01.10.2022	SCALE: 1:50 @ A1
DRAWING NUMBER: STS0870-M08		REVISION: -
DRAWING STATUS: FOR APPROVAL		

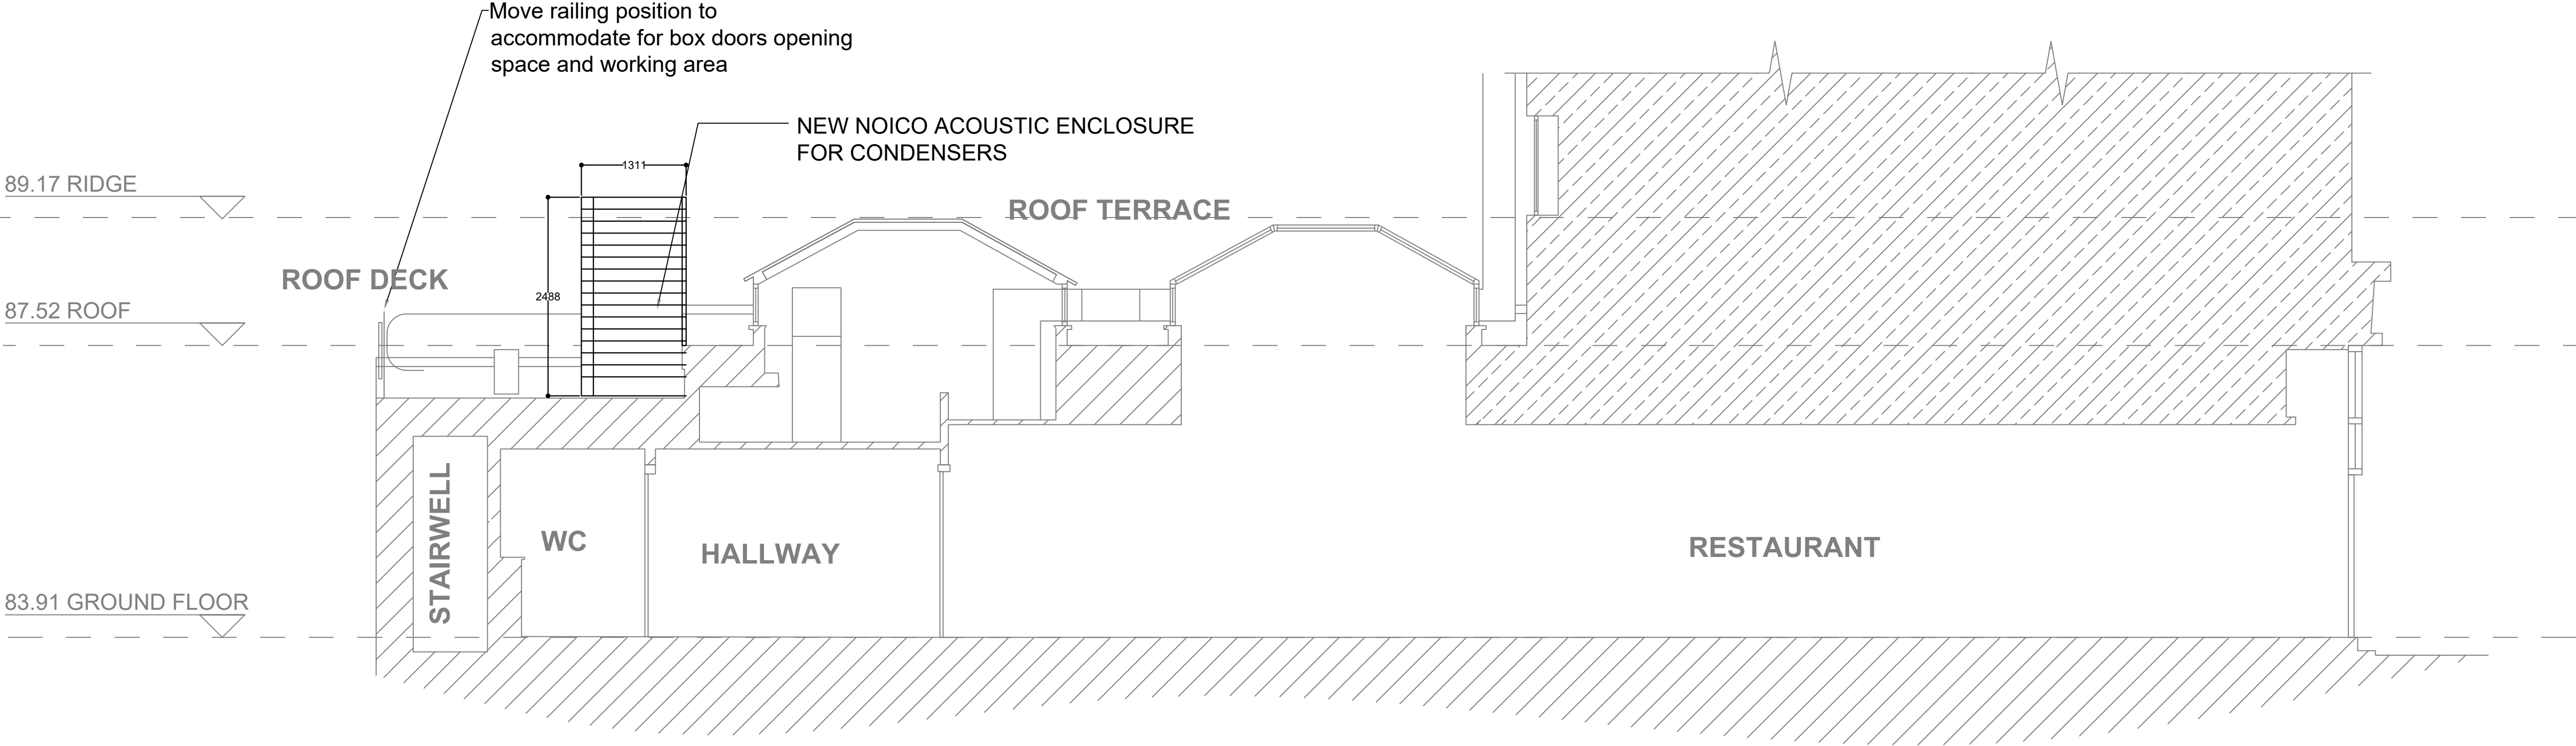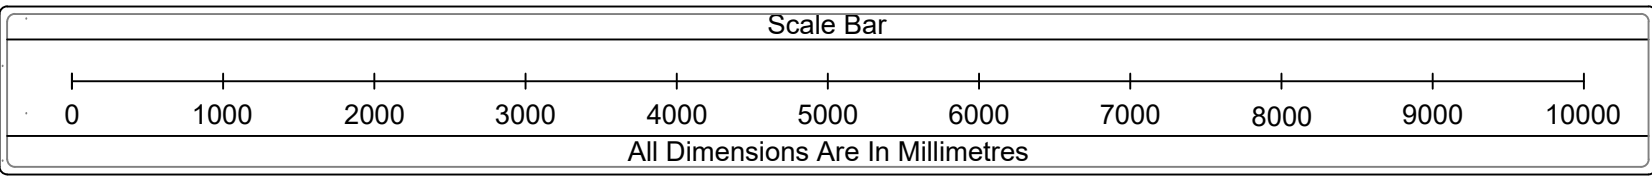

PROPOSED SECTION A-A

NOTES

DUCTWORK COLOUR KEY		
	EXTRACT EXHAUST AIR	
	KITCHRN EXTRACT	
	FRESH AIR SUPPLY (PRIMARY)	
	FRESH AIR INLET	
	AC SUPPLY AIR (SECONDARY)	
	TOILET EXTRACT	

REV	REVISION DESCRIPTION	REV DATE



1 BRADDOCK COURT
BASINGSTOKE
HAMPSHIRE
RG21 6AS

M:07889 605592
E: CRAIG@SPIRITUSTECHNICALSERVICES.CO.UK

CLIENT:
OTTOLENGHI

SITE:
32-34 ROSSLYN HILL
HAMPSTEAD
LONDON
NW3 1NH

DRAWING TITLE:
PROPOSED SECTION A-A
WITH OTTOLENGHI HVAC PLANT

DRAWN BY: CB	DATE: 01.10.2022	SCALE: 1:50 @ A1
-----------------	---------------------	---------------------

DRAWING NUMBER: STS0870-M09	REVISION: -
--------------------------------	----------------

DRAWING STATUS:
FOR APPROVAL