

32


33

34

35


36

37

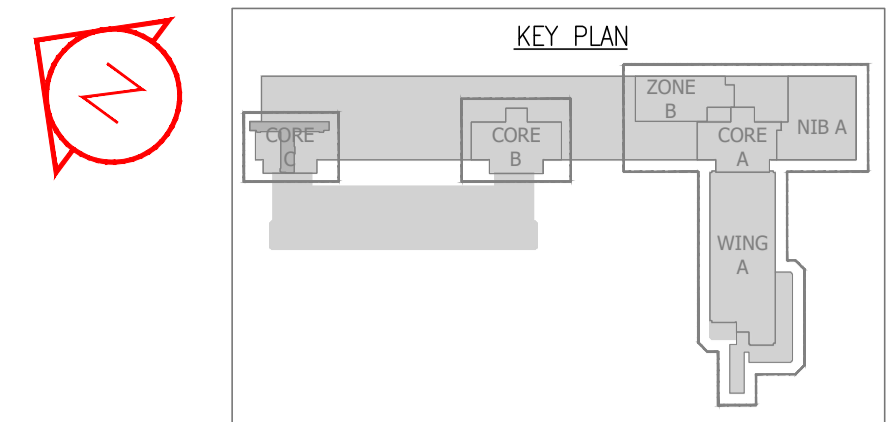

FOR CONTINUATION REFER TO DRAWING 20BW-LP-CA-06-DR-E-3006

R690D STORE

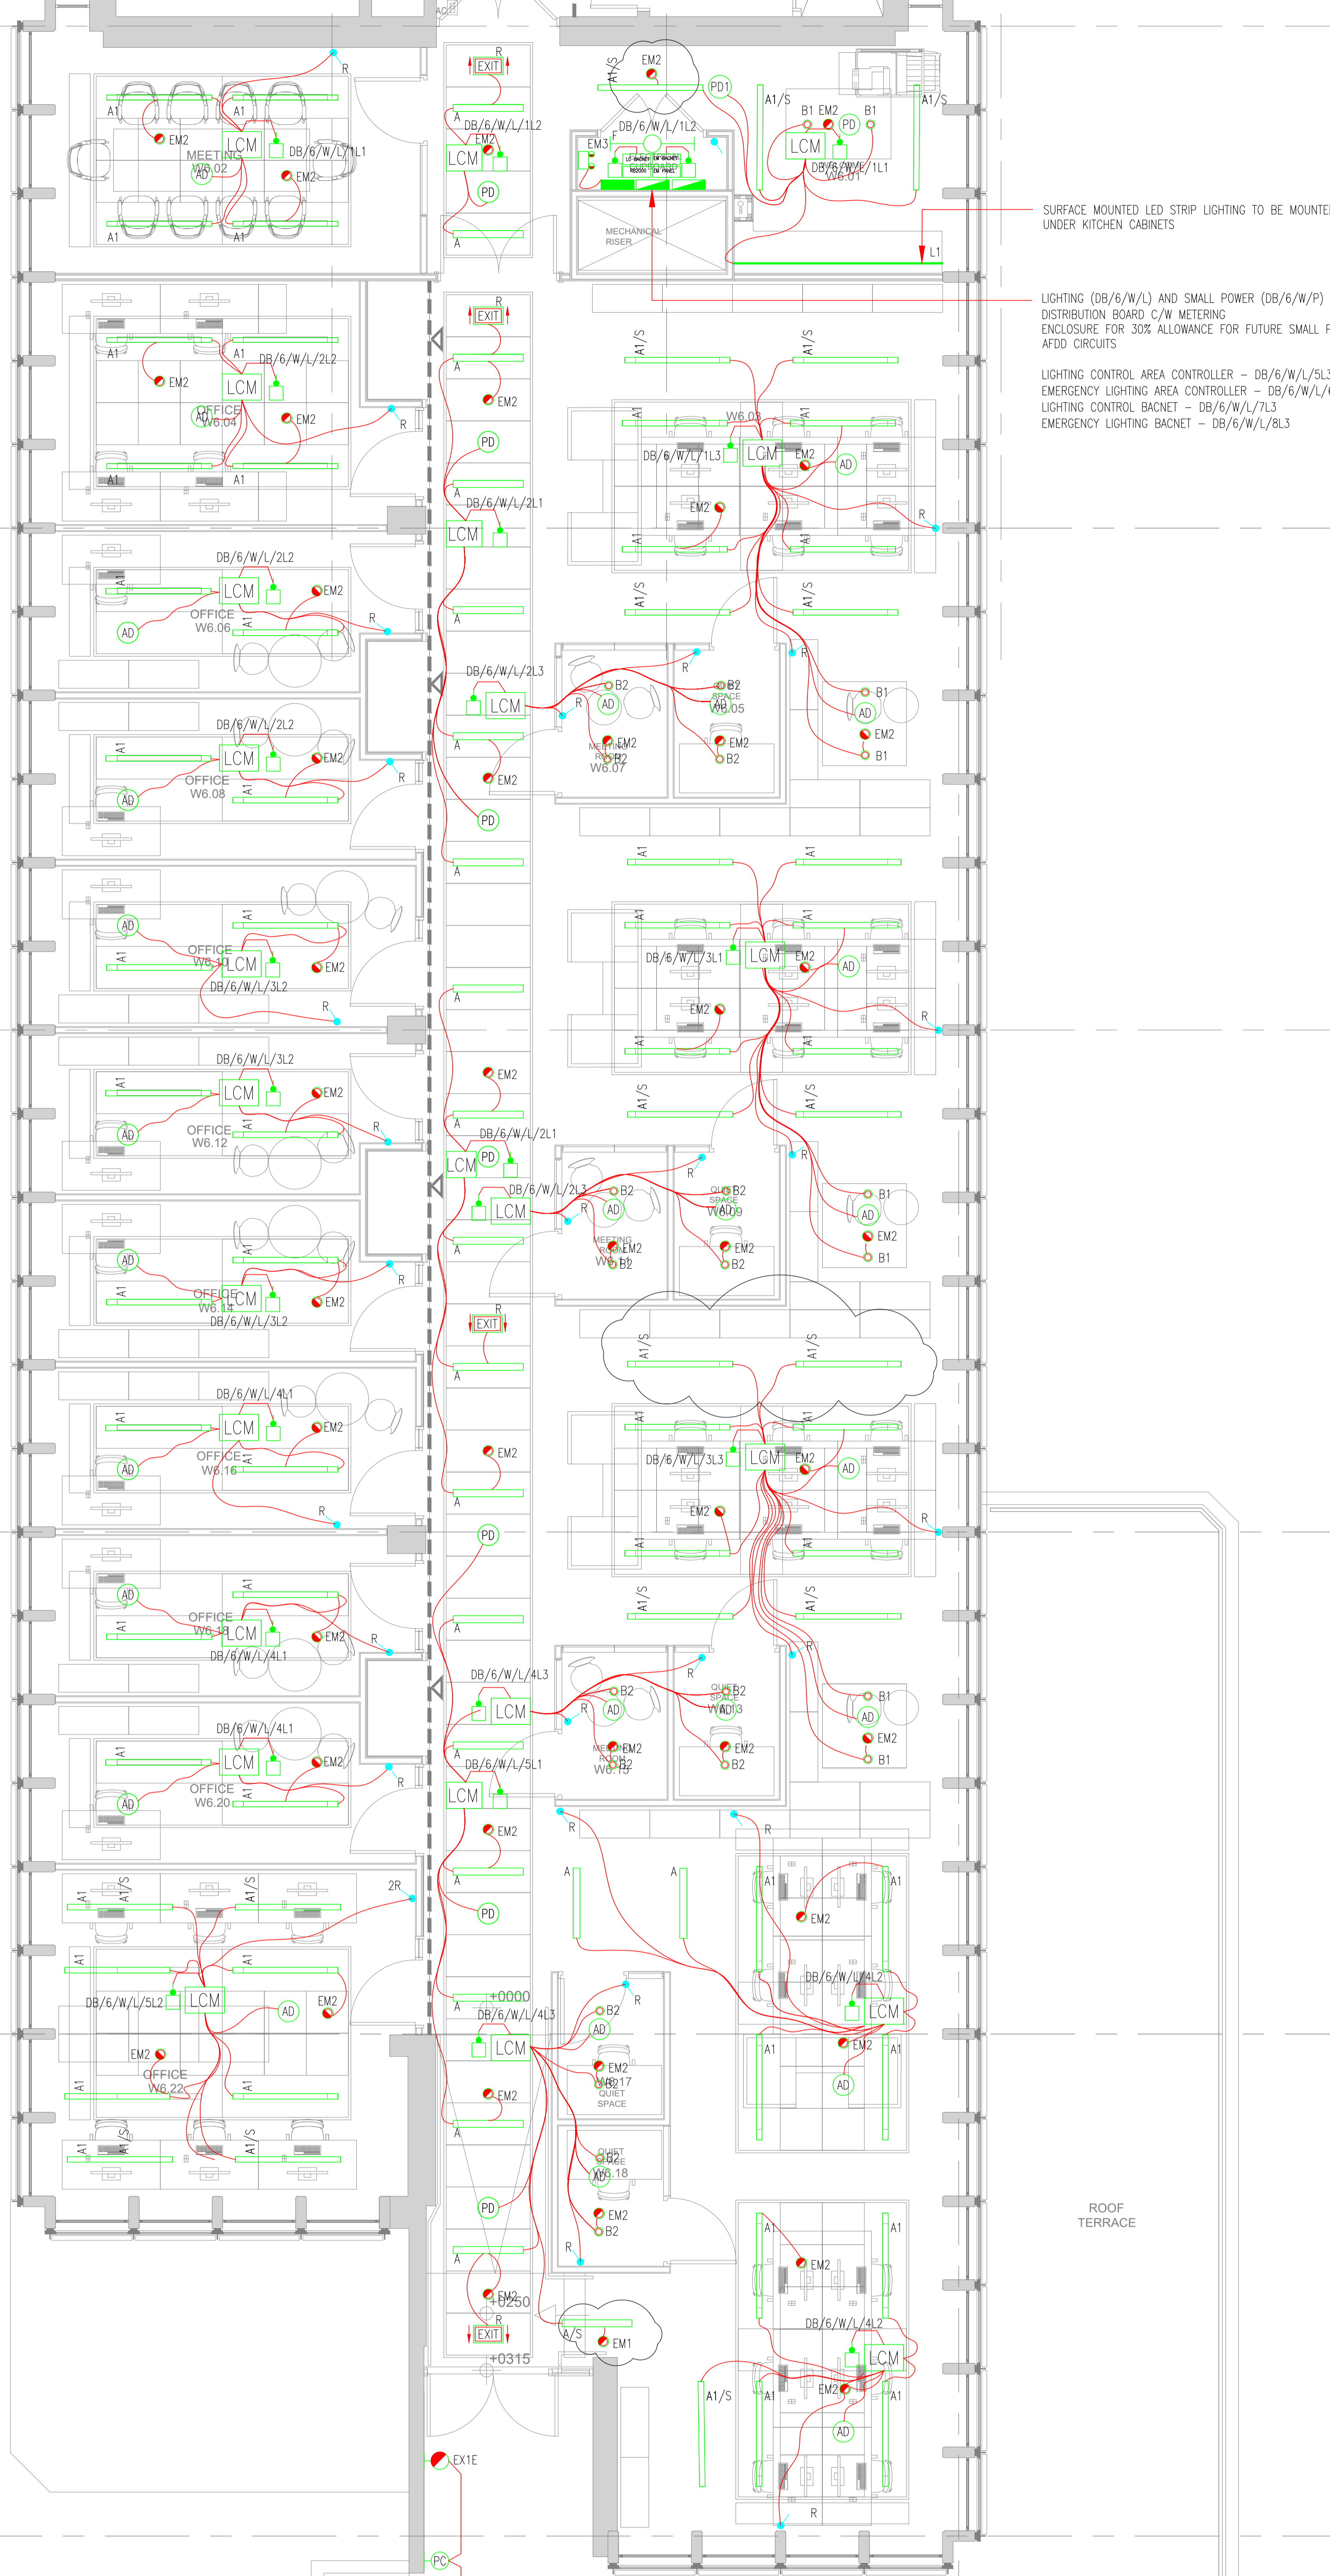

SURFACE MOUNTED LED STRIP LIGHTING TO BE MOUNTED UNDER KITCHEN CABINETS

LIGHTING (DB/6/W/L) AND SMALL POWER (DB/6/W/P) DISTRIBUTION BOARD C/W METERING ENCLOSURE FOR 30% ALLOWANCE FOR FUTURE SMALL POWER AFFD CIRCUITS

LIGHTING CONTROL AREA CONTROLLER - DB/6/W/L/SL3
EMERGENCY LIGHTING AREA CONTROLLER - DB/6/W/L/BL3
LIGHTING CONTROL BACNET - DB/6/W/L/7L3
EMERGENCY LIGHTING BACNET - DB/6/W/L/BL3

NOTES

1. ALL DRAWINGS SHALL BE READ IN CONJUNCTION WITH LONG & PARTNER'S DRAWINGS, SCHEDULES & SPECIFICATION.
2. FOR DETAILS, ELEVATIONS & EXACT SETTING OUT OF WALL MOUNTED ACCESSORIES, REFER TO THE ARCHITECTS LAYOUT.
3. THE ELECTRICAL SERVICES WORKS SHALL BE CARRIED OUT IN ACCORDANCE WITH THE LONG & PARTNER'S SPECIFICATION.
4. ALL EMERGENCY LUMINAIRES TO BE CONNECTED TO KLIK MODULE LOCATED WITHIN THE CEILING VOID. THE CIRCUIT TO BE DERIVED FROM THE LOCAL LIGHTING CIRCUIT.
5. ALL LIGHTING CONTROL LOCATIONS ARE INDICATIVE AND THE MANUFACTURER'S INSTALLATION INSTRUCTIONS SHOULD ALWAYS BE CHECKED

LEGEND

- A 1000mm LINEAR RECESSED LED LUMINAIRE
- A1 1500mm LINEAR RECESSED LED LUMINAIRE
- A1/S 1500mm SUSPENDED LINEAR LED LUMINAIRE
- A2 2000mm LINEAR RECESSED LED LUMINAIRE
- A2/S 3000mm LINEAR SURFACE MOUNTED LED LUMINAIRE
- A3 1200mm SUSPENDED MOUNTED LED LUMINAIRE
- A4 2274mm SUSPENDED MOUNTED LED LUMINAIRE TUNABLE BALLAST
- OB RECESSED CIRCULAR LED DOWNLIGHT
- OB1 RECESSED CIRCULAR LED DOWNLIGHT
- OB2 RECESSED CIRCULAR LED DOWNLIGHT
- OB3 RECESSED CIRCULAR LED DOWNLIGHT
- OB4 RECESSED CIRCULAR LED DOWNLIGHT
- OC RECESSED CIRCULAR LED DOWNLIGHT
- OC1 SUSPENDED CIRCULAR LED DOWNLIGHT
- OC2 SUSPENDED LED PENDANT
- OC3 SUSPENDED LED PENDANT
- OD IP65 RATED WALL MOUNTED LUMINAIRE
- LI & L2 IP65 LINEAR SURFACE MOUNTED LED LUMINAIRE
- EM1 SURFACE MOUNTED NON MAINTAINED EMERGENCY DOWNLIGHT (EXTG DENOTES EXISTING)
- EM2 RECESSED CIRCULAR NON MAINTAINED EMERGENCY DOWNLIGHT
- EM3 WALL MOUNTED NON MAINTAINED TWIN SPOTLIGHT EMERGENCY LUMINAIRE
- EXIT R RECESSED MAINTAINED ILLUMINATED LED EMERGENCY EXIT SIGN C/W RUNNING MAN PICTOGRAM
- EXIT SS SURFACE MOUNTED MAINTAINED ILLUMINATED LED EMERGENCY EXIT SIGN C/W RUNNING MAN PICTOGRAM
- EXIT S IP RATED SURFACE MOUNTED MAINTAINED ILLUMINATED LED EMERGENCY EXIT SIGN C/W RUNNING MAN PICTOGRAM
- E IP65 RATED SURFACE MOUNTED LINEAR LED LUMINAIRE
- OH RECESSED CIRCULAR LED DOWNLIGHT
- EX1 IP65 EXTERNAL WALL MOUNTED LUMINAIRE
- AD RECESSED MOUNTED ABSENCE DETECTOR COMBINED WITH DAYLIGHT LINK
- PD RECESSED MOUNTED PRESENCE DETECTOR COMBINED WITH DAYLIGHT LINK
- PO1 SURFACE MOUNTED PRESENCE DETECTOR
- PD2 SURFACE MOUNTED HIGH BAY PRESENCE DETECTOR COMBINED WITH DAYLIGHT LINK
- PD3 WALL MOUNTED MICROWAVE PRESENCE DETECTOR
- IP65 EXTERNAL WALL MOUNTED PHOTOCELL SENSOR
- LCM PLUGGABLE DALI LIGHTING CONTROL MODULE WITH FUSED CONNECTION UNIT MOUNTED ADJACENT
- HR2000 EXOR LIGHTING CONTROL POWER SUPPLY UNIT
- EM PANEL ZUMTOBEL EMERGENCY LIGHTING CONTROL PANEL
- LS LIGHT SWITCH
- R RETRACTABLE LIGHT SWITCH ('X' DENOTES NO. OF GANGS)
- INT INTERMEDIATE LIGHT SWITCH
- SS WALL MOUNTED LIGHTING CONTROL SCENE SELECT PLATE
- 'CV' DENOTES ITEM LOCATED WITHIN CEILING VOID
- 'WP' DENOTES WEATHERPROOF ITEMS
- LIGHTING CIRCUIT

E

F

G

H

I

J

ROOF TERRACE

EXTERNAL LIGHTING SHALL BE CONTROLLED VIA PHOTOCELL AND OVERRIDE SWITCH

Rev.	Date	Description	Drawn
C1	04.10.22	MINOR AMENDMENTS INCORPORATED	CAD
C0	06.05.22	CONTRACT ISSUE	CAD
6	06.04.22	STAGE 4 RE-START	CAD
5	01.07.2020	STAGE 4 FINAL ISSUE	CAD
		INCORPORATING COMMENTS	
4	15.05.2020	STAGE 4 ISSUE COMMENTS	CAD
3	08.04.2020	STAGE 4 ISSUE	CAD
2	27.03.2020	DRAFT STAGE 4 ISSUE	CAD
1	13.12.19	STAGE 3 ISSUE	CAD
0	22.11.19	DRAFT STAGE 3 ISSUE	CAD


Based on architects drawing
20BW-ALLP-22-06-DR-A-2605-L6 PLAN

CONTRACT ISSUE

Project UCL IOE, 20 BEDFORD WAY
PHASE 2

Title LEVEL 6 WING LIGHTING LAYOUT

Scale 1:50@A0
Designed by SN
Checked by PEC
Date NOV'19

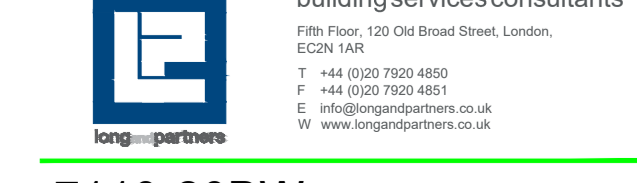

7110-20BW-LP-CA-06-DR-E-3006-2 C1

