


31 32 33 34 35 36 37 38 39

ROOF TERRACE

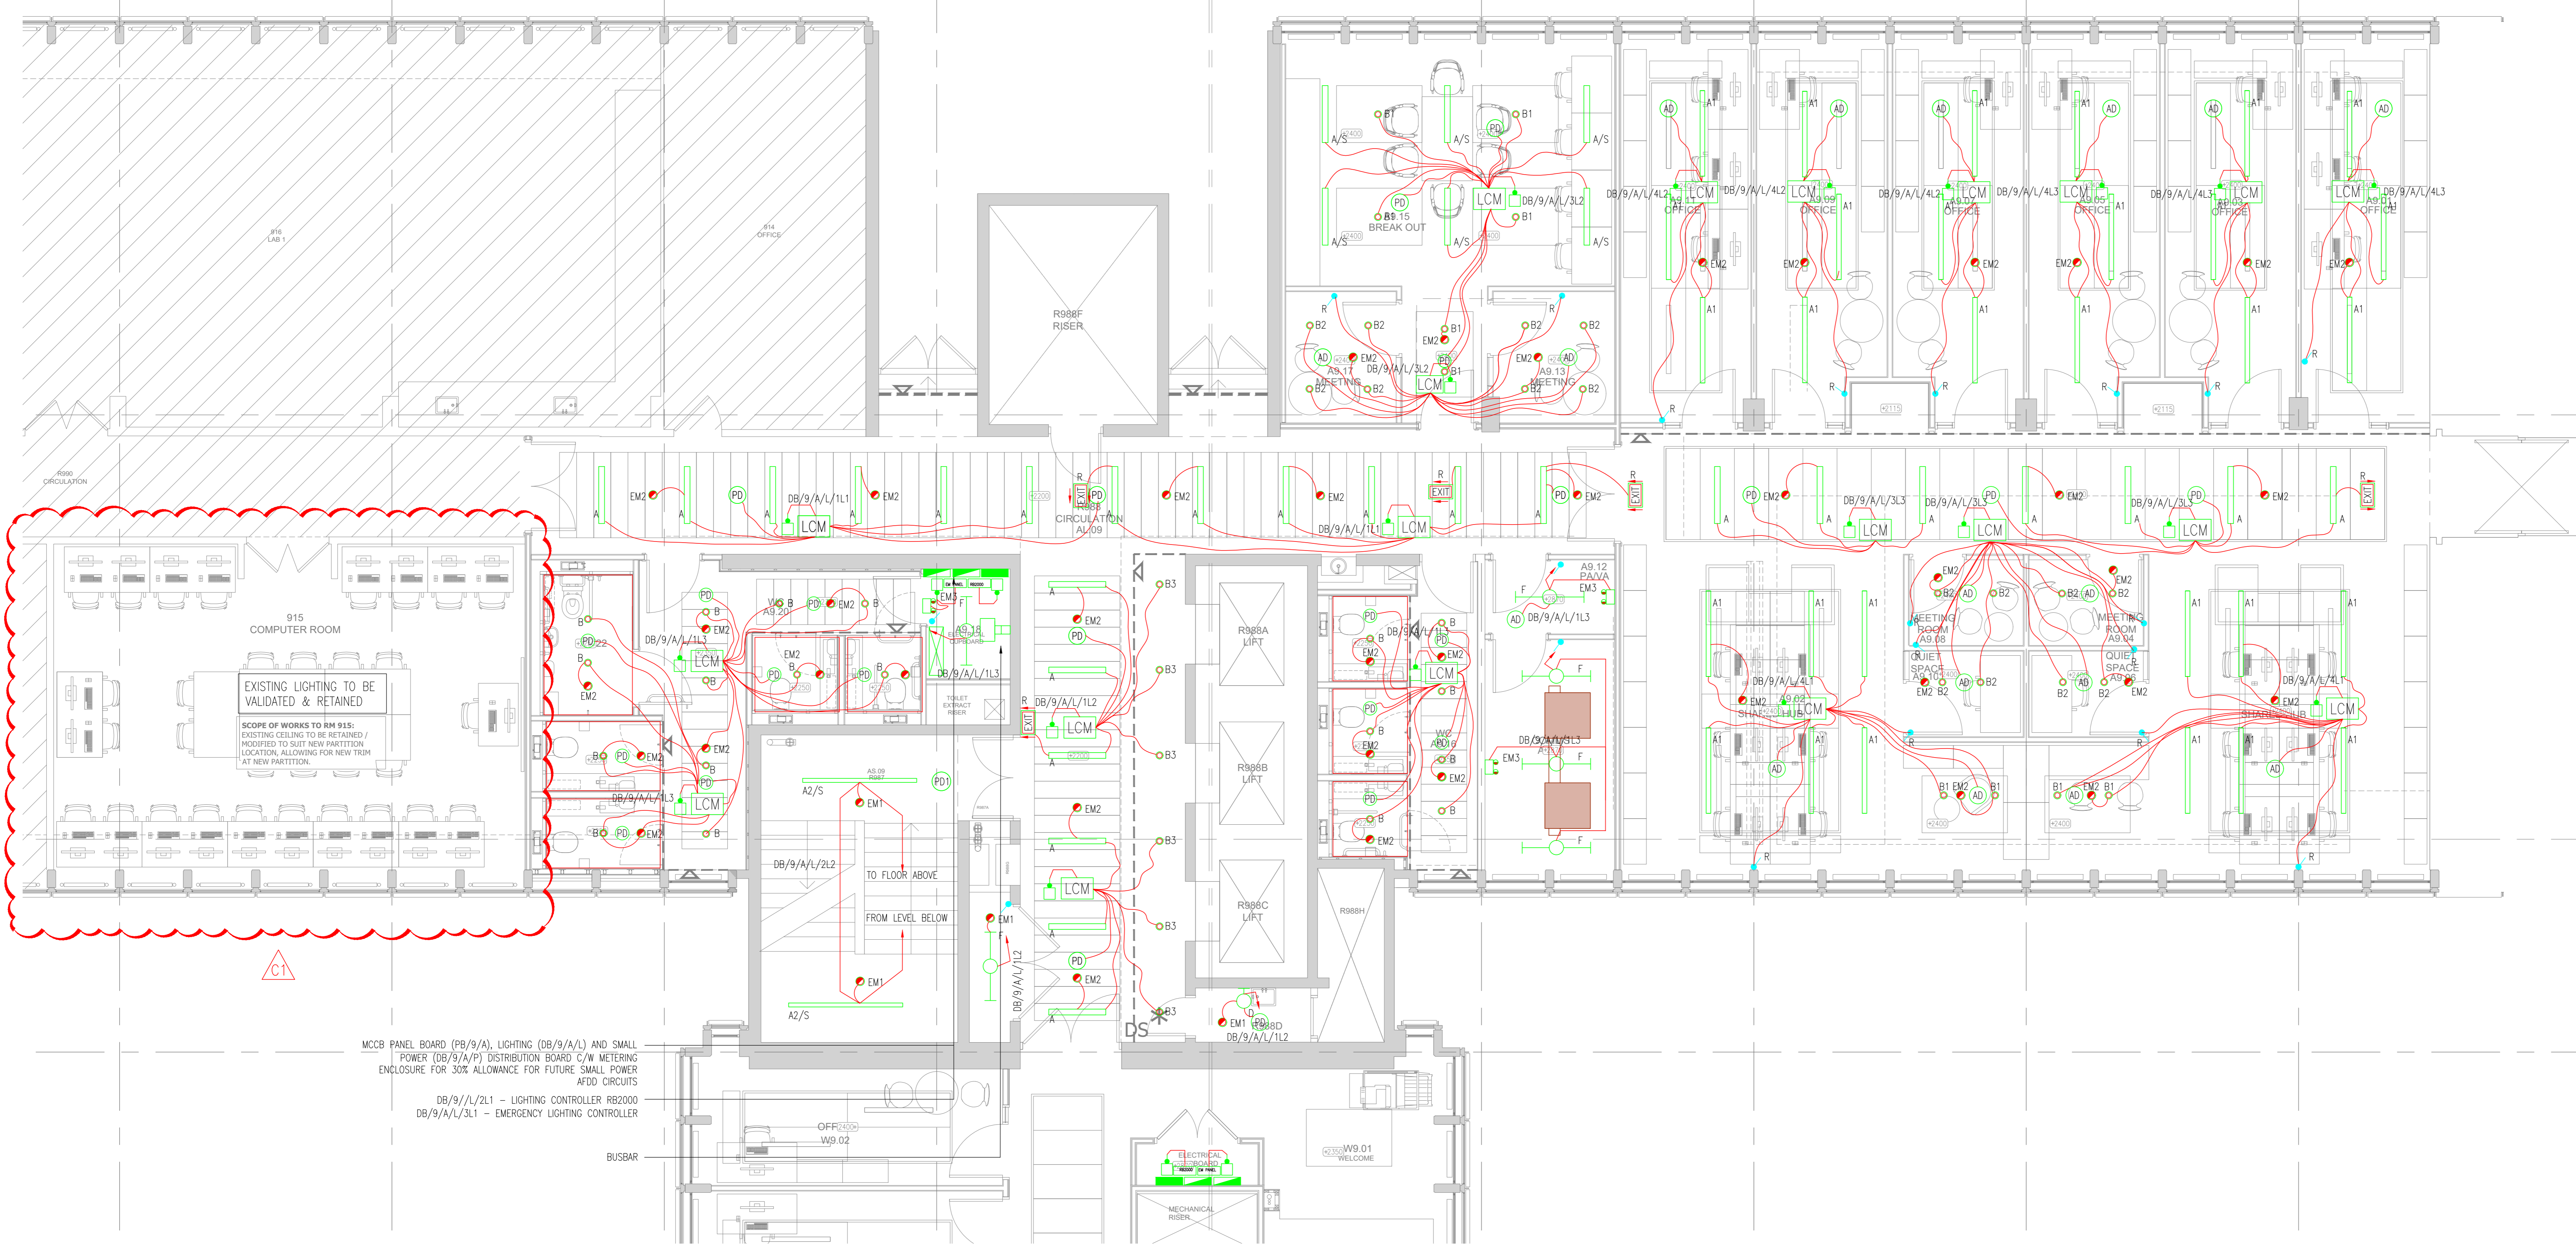

- NOTES**
1. ALL DRAWINGS SHALL BE READ IN CONJUNCTION WITH LONG & PARTNERS DRAWINGS, SCHEDULES & SPECIFICATION.
 2. FOR DETAILS, ELEVATIONS & EXACT SETTING OUT OF WALL MOUNTED ACCESSORIES, REFER TO THE ARCHITECTS LAYOUT.
 3. THE ELECTRICAL SERVICES WORKS SHALL BE CARRIED OUT IN ACCORDANCE WITH THE LONG & PARTNER'S SPECIFICATION.
 4. ALL EMERGENCY LUMINAIRES TO BE CONNECTED TO KLIK MODULE LOCATED WITHIN THE CEILING VOID. THE CIRCUIT TO BE DERIVED FROM THE LOCAL LIGHTING CIRCUIT.
 5. ALL LIGHTING CONTROL LOCATIONS ARE INDICATIVE AND THE MANUFACTURES INSTALLATION INSTRUCTIONS SHOULD ALWAYS BE CHECKED

- LEGEND**
- 1000mm LINEAR RECESSED LED LUMINAIRE
 - A 1500mm LINEAR RECESSED LED LUMINAIRE
 - A1/S 1500mm SUSPENDED LINEAR LED LUMINAIRE
 - A2 2000mm LINEAR RECESSED LED LUMINAIRE
 - A2/S 3000mm LINEAR SURFACE MOUNTED LED LUMINAIRE
 - A3 1200mm SUSPENDED MOUNTED LED LUMINAIRE
 - A4 2274mm SUSPENDED MOUNTED LED LUMINAIRE TUNABLE BALLAST

- OB RECESSED CIRCULAR LED DOWNLIGHT
- OB1 RECESSED CIRCULAR LED DOWNLIGHT
- OB2 RECESSED CIRCULAR LED DOWNLIGHT
- OB3 RECESSED CIRCULAR LED DOWNLIGHT
- OB4 RECESSED CIRCULAR LED DOWNLIGHT
- OC RECESSED CIRCULAR LED DOWNLIGHT
- OC1 SUSPENDED CIRCULAR LED DOWNLIGHT
- OC2 SUSPENDED LED PENDANT
- OC3 SUSPENDED LED PENDANT
- OD IP65 RATED WALL MOUNTED LUMINAIRE
- LI & LP IP65 LINEAR SURFACE MOUNTED LED LUMINAIRE
- EM1 SURFACE MOUNTED NON MAINTAINED EMERGENCY DOWNLIGHT (EXTG DENOTES EXISTING)
- EM2 RECESSED CIRCULAR NON MAINTAINED EMERGENCY DOWNLIGHT
- EM3 WALL MOUNTED NON MAINTAINED TWIN SPOTLIGHT EMERGENCY LUMINAIRE
- EXIT R RECESSED MAINTAINED ILLUMINATED LED EMERGENCY EXIT SIGN C/W RUNNING MAN PICTOGRAM
- EXIT SS SURFACE MOUNTED MAINTAINED ILLUMINATED LED EMERGENCY EXIT SIGN C/W RUNNING MAN PICTOGRAM
- EXIT S IP RATED SURFACE MOUNTED MAINTAINED ILLUMINATED LED EMERGENCY EXIT SIGN C/W RUNNING MAN PICTOGRAM
- IP65 RATED SURFACE MOUNTED LINEAR LED LUMINAIRE
- OH RECESSED CIRCULAR LED DOWNLIGHT
- EXT IP65 EXTERNAL WALL MOUNTED LUMINAIRE
- AD COMBINED MOUNTED ABSENCE DETECTOR COMBINED WITH DAYLIGHT LINK
- PD COMBINED MOUNTED PRESENCE DETECTOR COMBINED WITH DAYLIGHT LINK
- PD1 SURFACE MOUNTED PRESENCE DETECTOR
- PD2 SURFACE MOUNTED HIGH BAY PRESENCE DETECTOR COMBINED WITH DAYLIGHT LINK
- PD3 WALL MOUNTED MICROWAVE PRESENCE DETECTOR
- IP65 EXTERNAL WALL MOUNTED PHOTOCELL SENSOR
- LCM PLUGGABLE DALI LIGHTING CONTROL MODULE WITH FUSED CONNECTION UNIT MOUNTED ADJACENT
- RB000 EXOR LIGHTING CONTROL POWER SUPPLY UNIT
- EM PANEL ZUMTOBEL EMERGENCY LIGHTING CONTROL PANEL
- SW LIGHT SWITCH
- R RETRACTABLE LIGHT SWITCH ('X' DENOTES NO. OF GANGS)
- INT INTERMEDIATE LIGHT SWITCH
- SS WALL MOUNTED LIGHTING CONTROL SCENE SELECT PLATE
- 'CV' DENOTES ITEM LOCATED WITHIN CEILING VOID
- 'WP' DENOTES WEATHERPROOF ITEMS
- LIGHTING CIRCUIT

MCCB PANEL BOARD (P9/9/A), LIGHTING (08/9/A/L) AND SMALL POWER (08/9/A/P) DISTRIBUTION BOARD C/W METERING ENCLOSURE FOR 30% ALLOWANCE FOR FUTURE SMALL POWER AFCD CIRCUITS
 DB/9/A/L/2/L1 - LIGHTING CONTROLLER RB0000
 DB/9/A/L/3/L1 - EMERGENCY LIGHTING CONTROLLER

FOR CONTINUATION REFER TO DRAWING 20BW-LP-CA-09-DR-E-3009-2

Rev	Date	Description	Drawn
C1	04.10.22	MINOR AMENDMENTS INCORPORATED	CAD
C1	21.07.22	CONTRACT ISSUE	CAD
CD	06.05.22	CONTRACT ISSUE	CAD
9	06.04.22	STAGE 4 RE-START	CAD
8	21.12.21	REVISED TO SUIT EA26	CAD
7	15.03.21	REVISED TO SUIT EA28	CAD
6	15.01.21	REVISED TO SUIT EA20	CAD
5	01.07.2020	STAGE 4 FINAL ISSUE INCORPORATING COMMENTS	CAD
4	15.05.2020	STAGE 4 ISSUE COMMENTS	CAD
3	02.04.2020	STAGE 4 ISSUE	CAD
2	13.03.2020	DRAFT STAGE 4 ISSUE	CAD
1	13.12.19	STAGE 3 ISSUE	CAD
0	22.11.19	DRAFT STAGE 3 ISSUE	CAD

Based on architects drawing
 20BW-ALP-ZZ-09-DR-A-2905-L9 PLAN
CONTRACT ISSUE
 Project UCL IOE, 20 BEDFORD WAY PHASE 2
 Title LEVEL 9 CORE A LIGHTING LAYOUT
 Scale 1:500A0
 Designed By SN
 Checked by PEC
 Date NOV 19

