


1 EXISTING REFLECTED CEILING PLAN - GROUND FLOOR

scale 1:100

No. 37 FLASK WALK

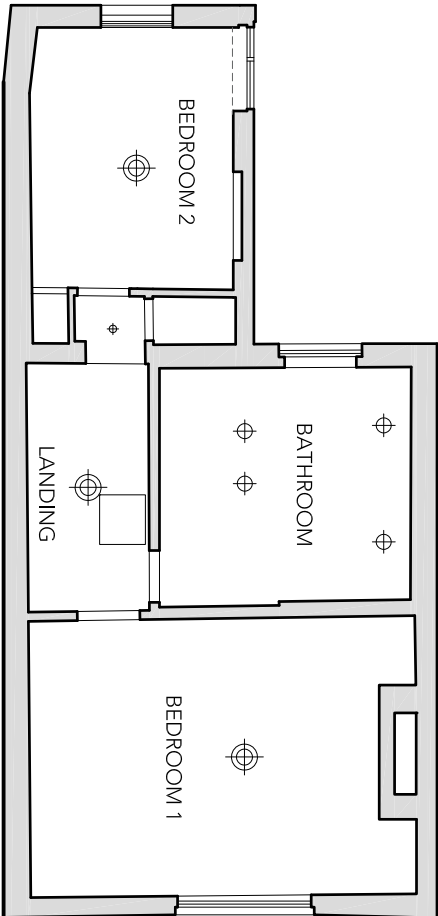

2 EXISTING REFLECTED CEILING PLAN - FIRST FLOOR

scale 1:100

No. 37 FLASK WALK

LEGEND

	SMALL RECESSED DOWN LIGHT
	BIG RECESSED DOWN LIGHT
	SUSPENDED / PENDANT LIGHT
	RECESSED DOUBLE DOWN LIGHT NON TRIMLESS
	RECESSED ADJUSTABLE DOWN LIGHT



This drawing is protected under Copyright and at no time should any portion of this drawing be reproduced or copied without the permission of the Architect.  
(Design Copyright Act 1968)

This drawing must not be used for purposes other than that for which it is provided. It is supplied without liability for any errors or omissions.

Drawings only to be scaled for planning application purposes, all dimensions to be checked on site. All drawings subject to Statutory Authority Approval.

Notes

1 Planning	06.12.22
No Rev	Date

PLANNING

Status



ARCHITECTS + INTERIOR DESIGNERS

91A - 91B HEATH STREET  
LONDON NW3 6SS  
Tel 020 7636 3838  
INFO WWW.TG-STUDIO.CO.UK

39 FLASK WALK  
LONDON NW3 1HH

Date	05.12.12
Scale @ A3	1:100

GROUND FLOOR  
AND FIRST FLOOR EXISTING  
REFLECTED CEILING PLAN

Job No.	258	Drawn by	JG	Dwg No.	P-250	Rev	A
Checked by	LG						