


1 PROPOSED REFLECTED CEILING PLAN - GROUND FLOOR

scale 1:100

LEGEND	
LIGHTING PLAN	
SYMBOL	CODE
DESCRIPTION	
⬢	LT-01
RECESSED DOWN LIGHT	
⬢	LT-03
RECESSED DOWN LIGHT FOR BATHROOM	
⬢	LT-04
RECESSED DOUBLE DOWN LIGHT NON TRIMLESS	
⬢	LT-05
RECESSED ADJUSTABLE DOWN LIGHT	
⬢	LT-06
LED STRIP	
⬢	LT-07
LED STRIP FOR BATHROOM	
⬢	LT-08/09
WALL LIGHT	
⬢	LT-08/09
EXTERNAL WALL LIGHT	
⬢	LT-10
SUSPENDED / PENDANT LIGHT	
⬢	PR
GARDEN SPIKE LIGHTS	

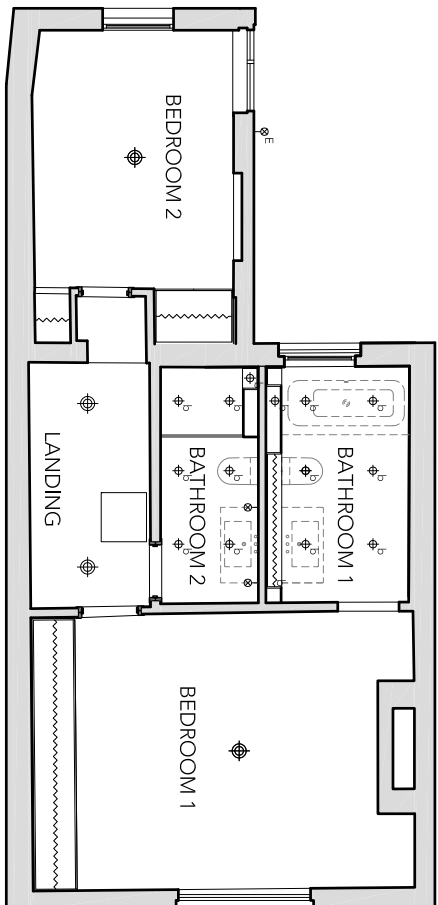

2 PROPOSED REFLECTED CEILING PLAN - FIRST FLOOR

scale 1:100

This drawing is protected under Copyright and at no time should any portion of this drawing be reproduced or copied without the permission of the Architect.
(Design Copyright Act 1968)

This drawing must not be used for purposes other than that for which it is provided. It is supplied without liability for any errors or omissions.

Drawings only to be scaled for planning application purposes, all dimensions to be checked on site. All drawings subject to Statutory Authority Approval.

Notes	
1	Planning
No Rev	Date
1	06.12.22

Status
PLANNING



ARCHITECTS + INTERIOR DESIGNERS

91A - 91B HEATH STREET
LONDON NW3 6SS
Tel 020 7 633 6338
INFO WWW.TG-STUDIO.CO.UK

Project	Date	Drawing	Drawn by	Job No.
39 FLASK WALK LONDON NW3 1HH	30.11.12	GROUND FLOOR AND FIRST FLOOR PROPOSED REFLECTED CEILING PLAN	JG	258
	Scale @ A3 1:100		Checked by LG	Dwg No. P-350
				Rev