


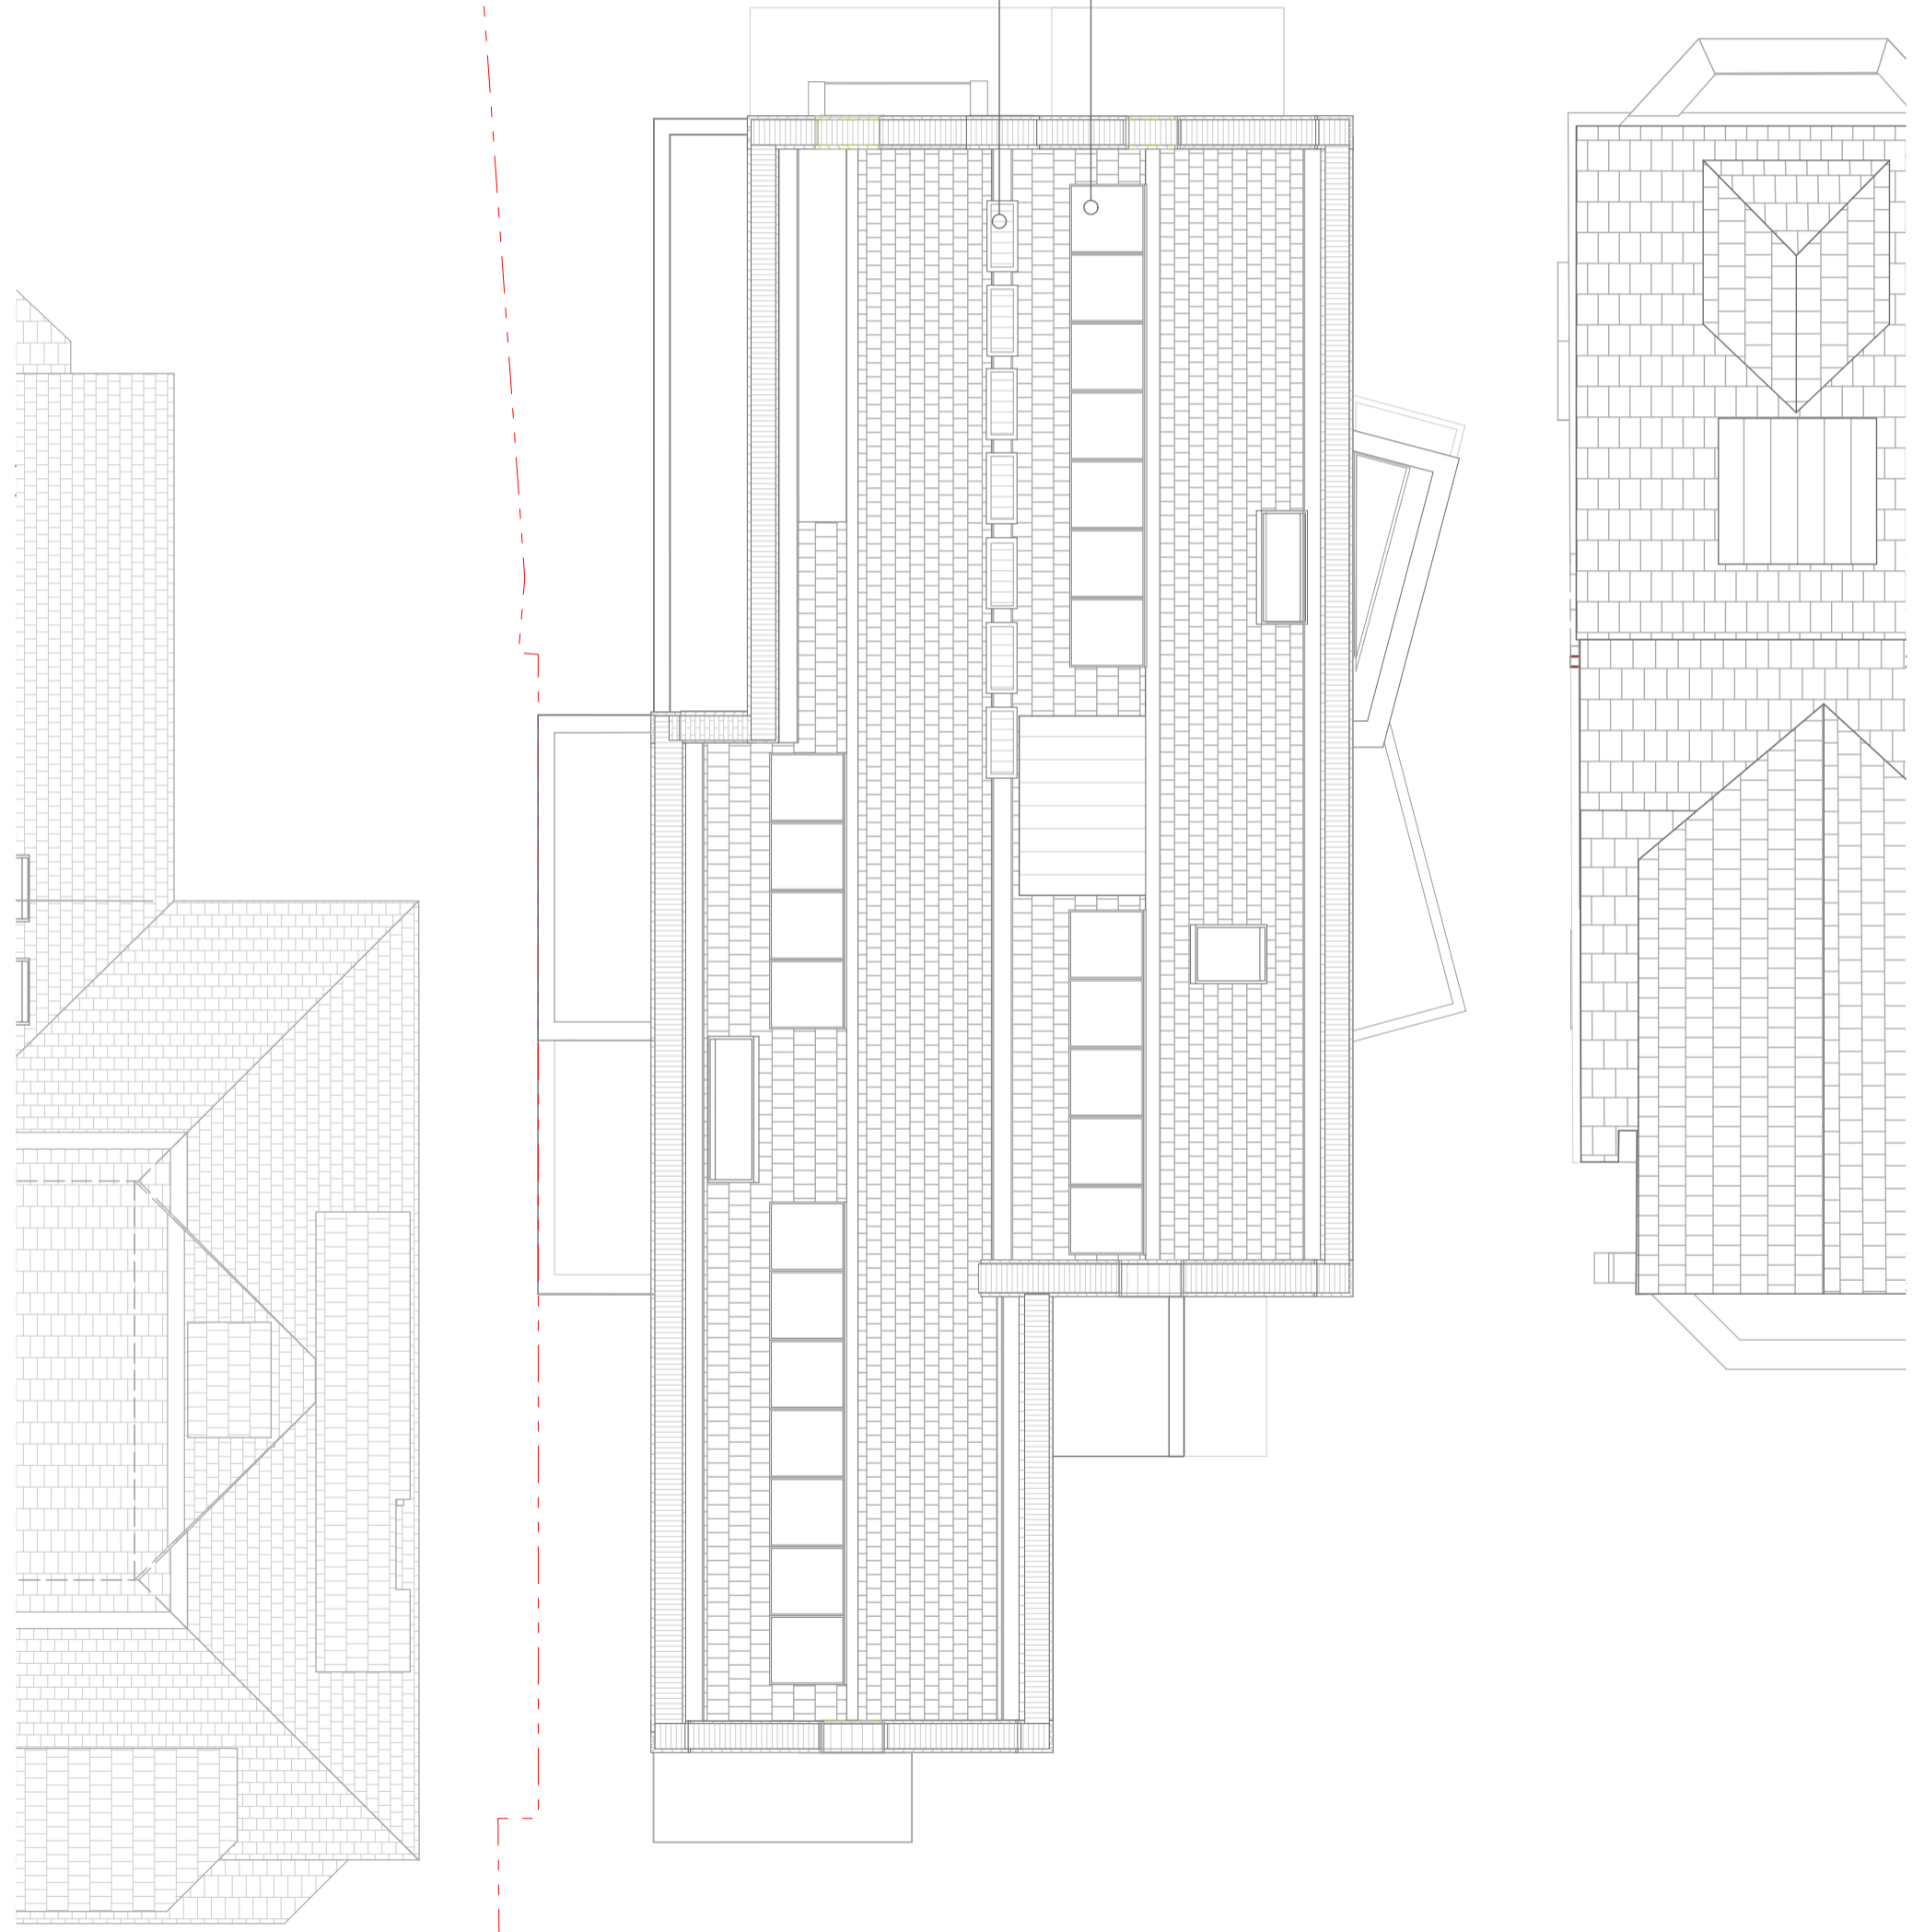

Air Source Heat Pumps

PV Panels



**Project**  
13 Netherhall Gardens NW3 5RN

**Phase 4**  
Issue Date  
16/11/2022

**Drawing Title**  
Proposed Roof Plan

**Drawing Status**  
PLANNING

**Revision Description**  
Final Revision

**Scale** 1:100 @ (A3)

**Drawing No.**  
AL.102.06 P

195-199 Grays Inn Road,  
London, WC1X 8UL  
Tel: +44 (0)2072500090  
www.re-creo.eu

