


NO HTG INSTALLATION WORKS TO BE CARRIED OUT ON THIS FLOOR.

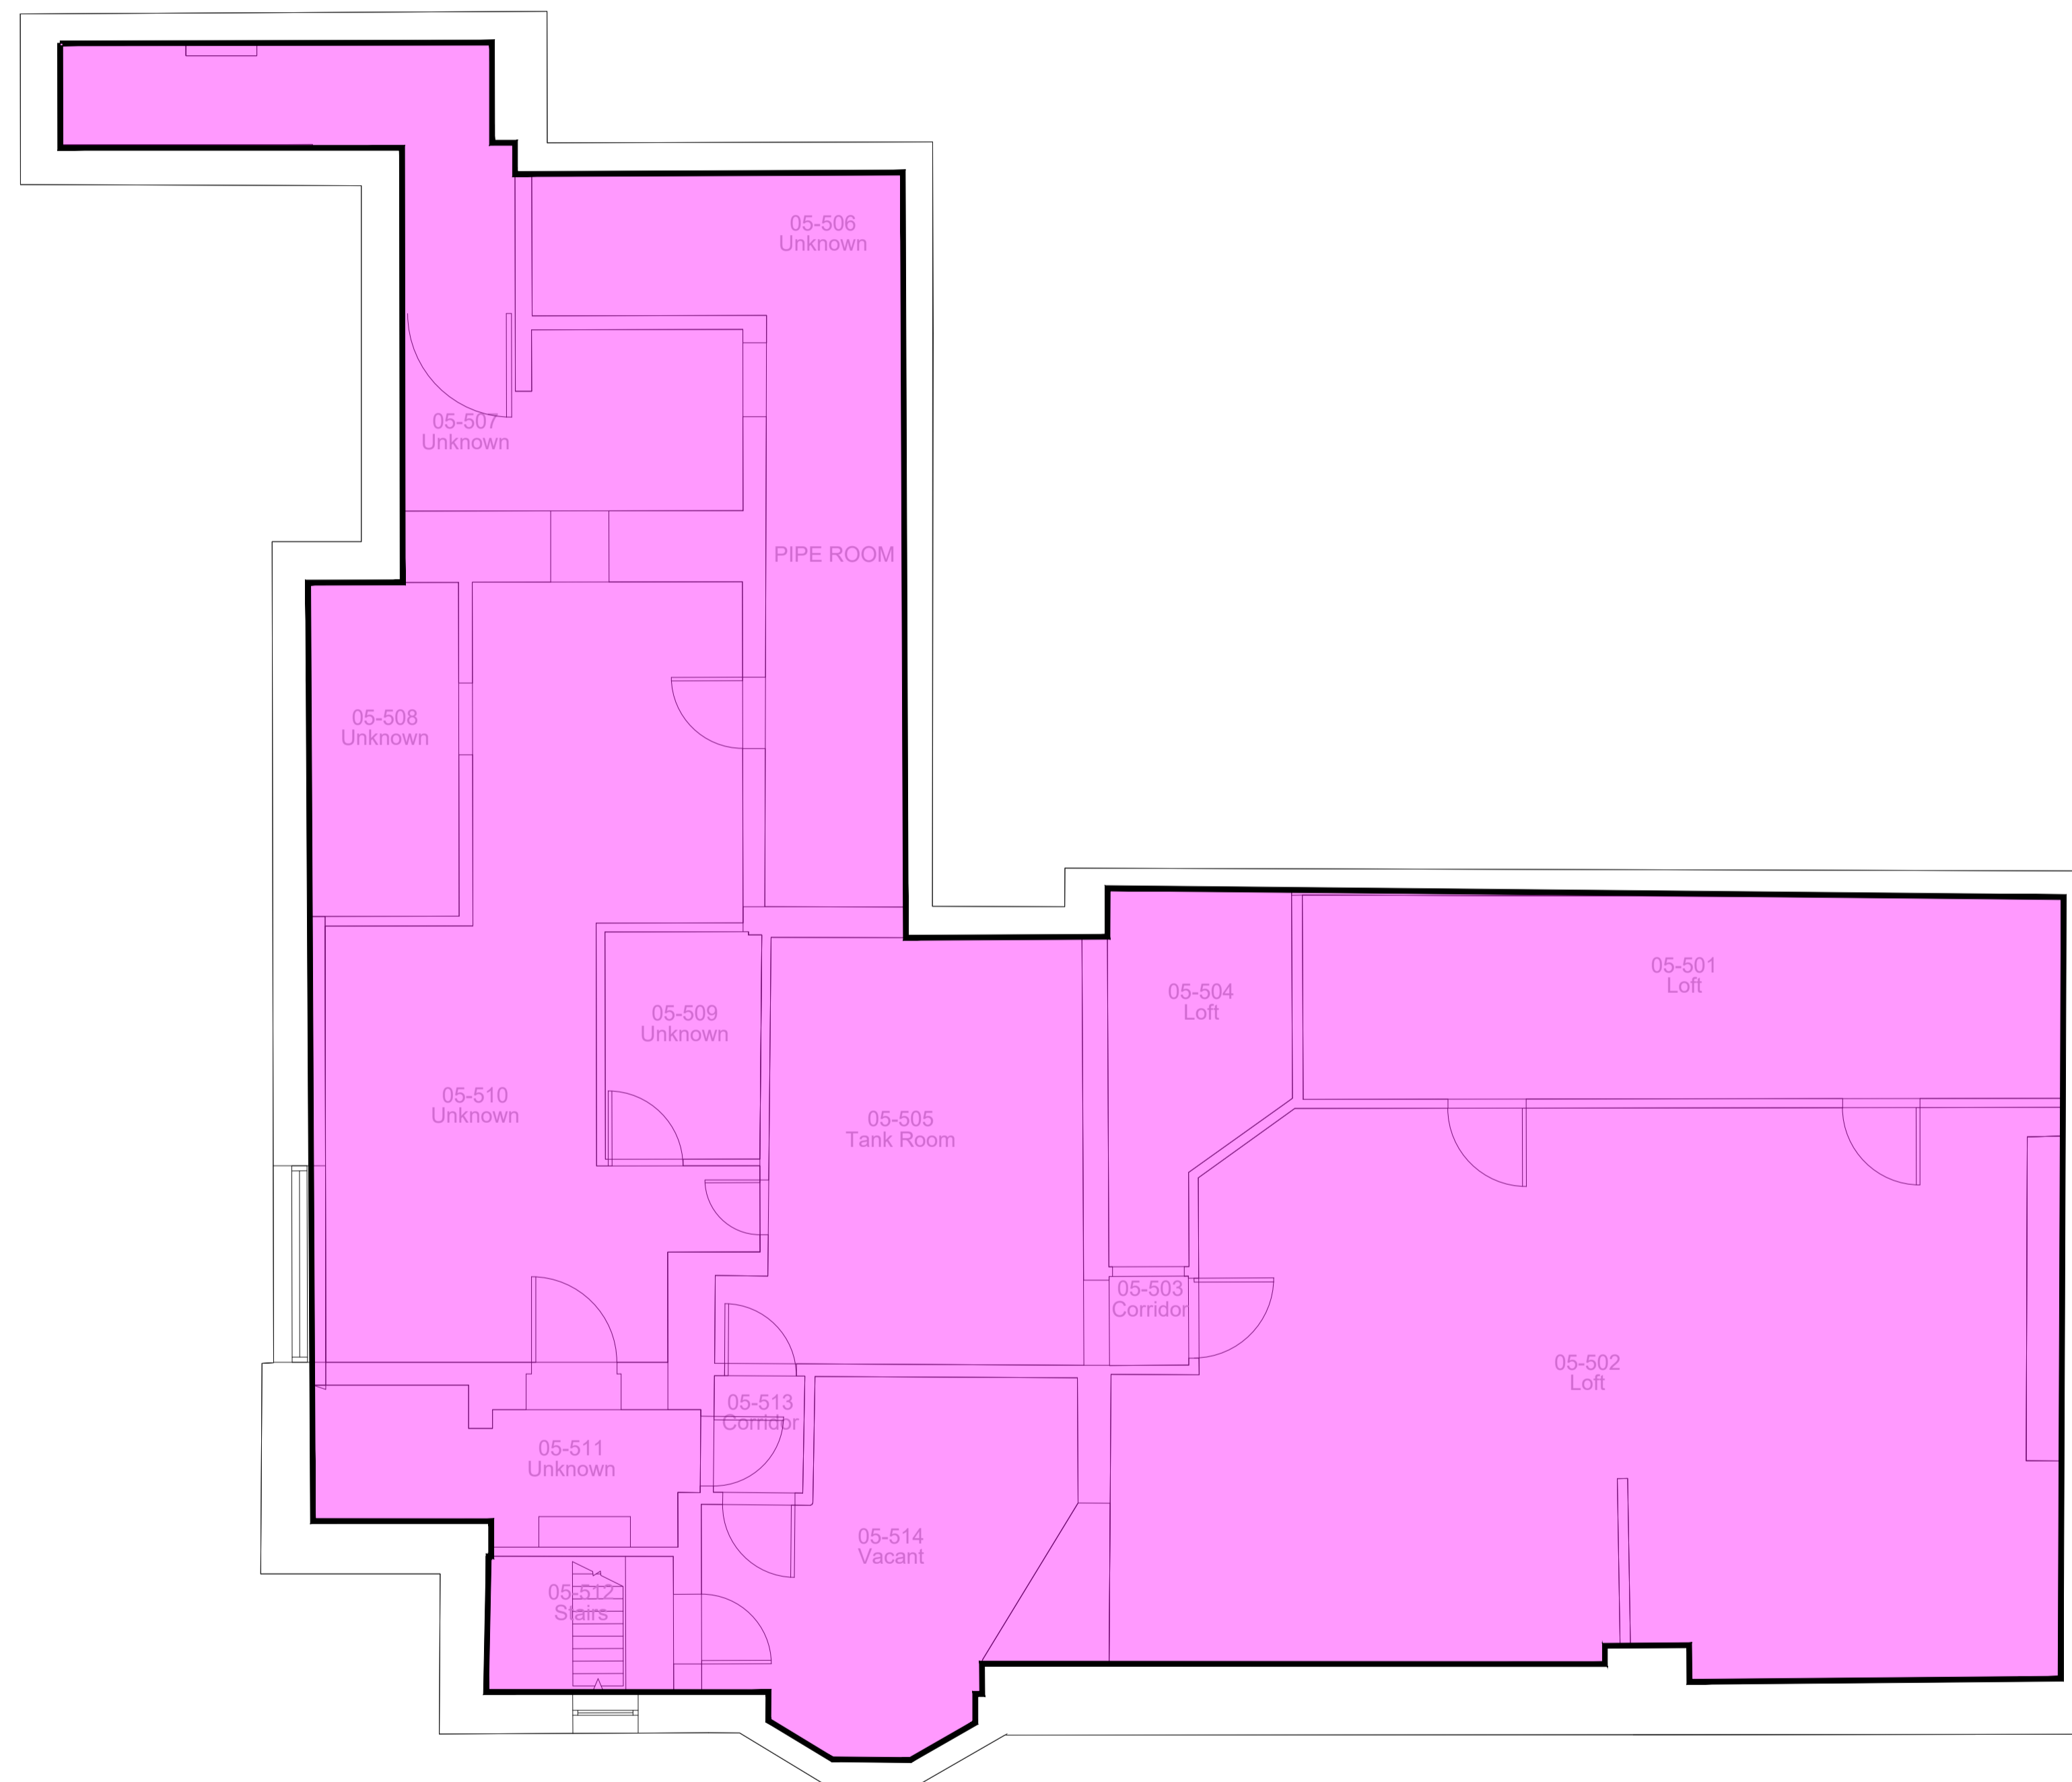

ALL DIMENSIONS, LEVELS AND CLEARANCES TO BE CHECKED ON SITE PRIOR TO WORKS COMMENCING

THIS DRAWING SHOULD BE READ IN CONJUNCTION WITH ALL OTHER PROJECT RELATED DRAWINGS, SPECIFICATIONS AND DOCUMENTS AS PART OF A SINGLE PROJECT PACKAGE.

ANY DISCREPANCY BETWEEN THIS DRAWING, OTHER DRAWINGS FORMING PART OF THIS CONTRACT, OR THE SPECIFICATION / BILLS OF QUANTITIES MUST BE CLARIFIED BEFORE COMMENCEMENT OF ANY WORK OR ORDERING OF ANY MATERIALS.

PLEASE CONSULT THE AUTHOR OR PROJECT MANAGER SHOULD THE READER REQUIRE CLARIFICATION ON ANY PART OF THIS DRAWING.

THE COPYRIGHT OF THE DRAWING AND DESIGN IS THE PROPERTY OF THE COMPANY. THIS INFORMATION HAS BEEN ISSUED UNDER SPECIFIC TERMS FOR THIS PROJECT AND MAY ONLY BE USED AND REPRODUCED ACCORDINGLY.

- NOTES**
- ALL PIPEWORK ROUTES SHOWN ARE INDICATIVE & SUBJECT TO VALIDATION BY THE CONTRACTOR.
 - FOR PIPE SIZES REFER TO DWG No. 522223-FCG-MB-SC-DR-M-5000 & 522223-FCG-MB-SC-DR-M-5600

- LEGEND:**
- — PIPE DROPPING TO BELOW
 - — PIPE RISING TO ABOVE
 - PIPEWORK BELOW FLOOR
 - PIPEWORK AT LOW LEVEL
 - - - PIPEWORK AT HIGH LEVEL
 - · - · - PIPEWORK WITHIN CEILING VOID SPACE
 - ▢ PROPOSED RADIATOR
 - ▢ ROOM THERMOSTAT
 - EXTENT OF UN-HEATED 5th FLOOR

- ABBREVIATIONS:**
- HTG-F — HEATING FLOW
 - HTG-R — HEATING RETURN
 - F.A. — FROM ABOVE
 - F.B. — FROM BELOW
 - T.A. — TO ABOVE
 - T.B. — TO BELOW
 - DTLL — DROP TO LOW LEVEL
 - H/L — HIGH LEVEL
 - L/L — LOW LEVEL
 - C/V — CEILING VOID

Rev	Date	By	Chk	App	Comment
C01	29.11.22	DJ	AM	BP	Tender Issue
P01	27.10.22	DJ	AM	BP	Preliminary Issue

BRANDING IDEAS TO LIFE



FRANKHAM
Frankham Consultancy Group Limited
E: enquire@frankham.com
www.frankham.com

SIDCUP OFFICE Irene House Five Arches Business Park Medstone Road Sidcup, Kent DA14 5AE T: 020 8309 7777	OXFORD OFFICE Woodton Business Park Beesley Road Woodton, Abingdon Oxfordshire OX13 6FD T: 01865 322500
LONDON OFFICE Third Floor Bard House 15-17 St Cross Street London EC1N 8JW T: 020 7651 0790	STEVENAGE OFFICE Suite 237, Second Floor Kings Court Business Centre London Road, Stevenage Hertfordshire SG1 2NG T: 020 3748 7063

Client:



LFB
LONDON FIRE BRIGADE

Project Title:

Euston Fire Station

Drawing Title:

**Fifth Floor
Mechanical Services
Proposed Heating Layout**

Status:

TENDER ISSUE

Drawn By:	Designed By:	Checked By:	Approved By:
DK	DJ	AM	BP
Original Issue Date:	Scale @ A1:		
27/10/2022	1:50		

Job No/ File Ref	Originator	Zone	Level
522223	FCG	MB	05
Type	Discipline	Number	Suitability
DR	M	5607	D2
			Revision
			C01