

NOTES

Copyright Carbogno Ceneda Architects.


No implied license exists. This drawing should not be used to calculate areas for the purposes of valuation. All dimensions to be checked on site by the contractor and such dimensions to be their responsibility.

This drawing is to be read in conjunction with all other contract documents and specifications and all other consultants drawings. All levels and dimensions should be checked on site

All work must comply with relevant British Standards and Building Regulations requirements. Drawing errors and omissions to be reported to the architect

LANDSCAPE LIGHT FITTINGS (KEY)

- R** RECESSED CEILING LIGHT IP RATED (2700K WARM WHITE)
- F** EXTERNAL RECESSED FLOOR MOUNTED LIGHT WITH WALL WASH DIRECTION OPTION (2700K WARM WHITE)
- B** EXTERNAL BOLLARD WITH DOWNWARDS DIRECTION LIGHT (2700K WARM WHITE)
- W** EXTERNAL WALL LIGHT WITH DOWNWARDS DIRECTION LIGHT (2700K WARM WHITE)

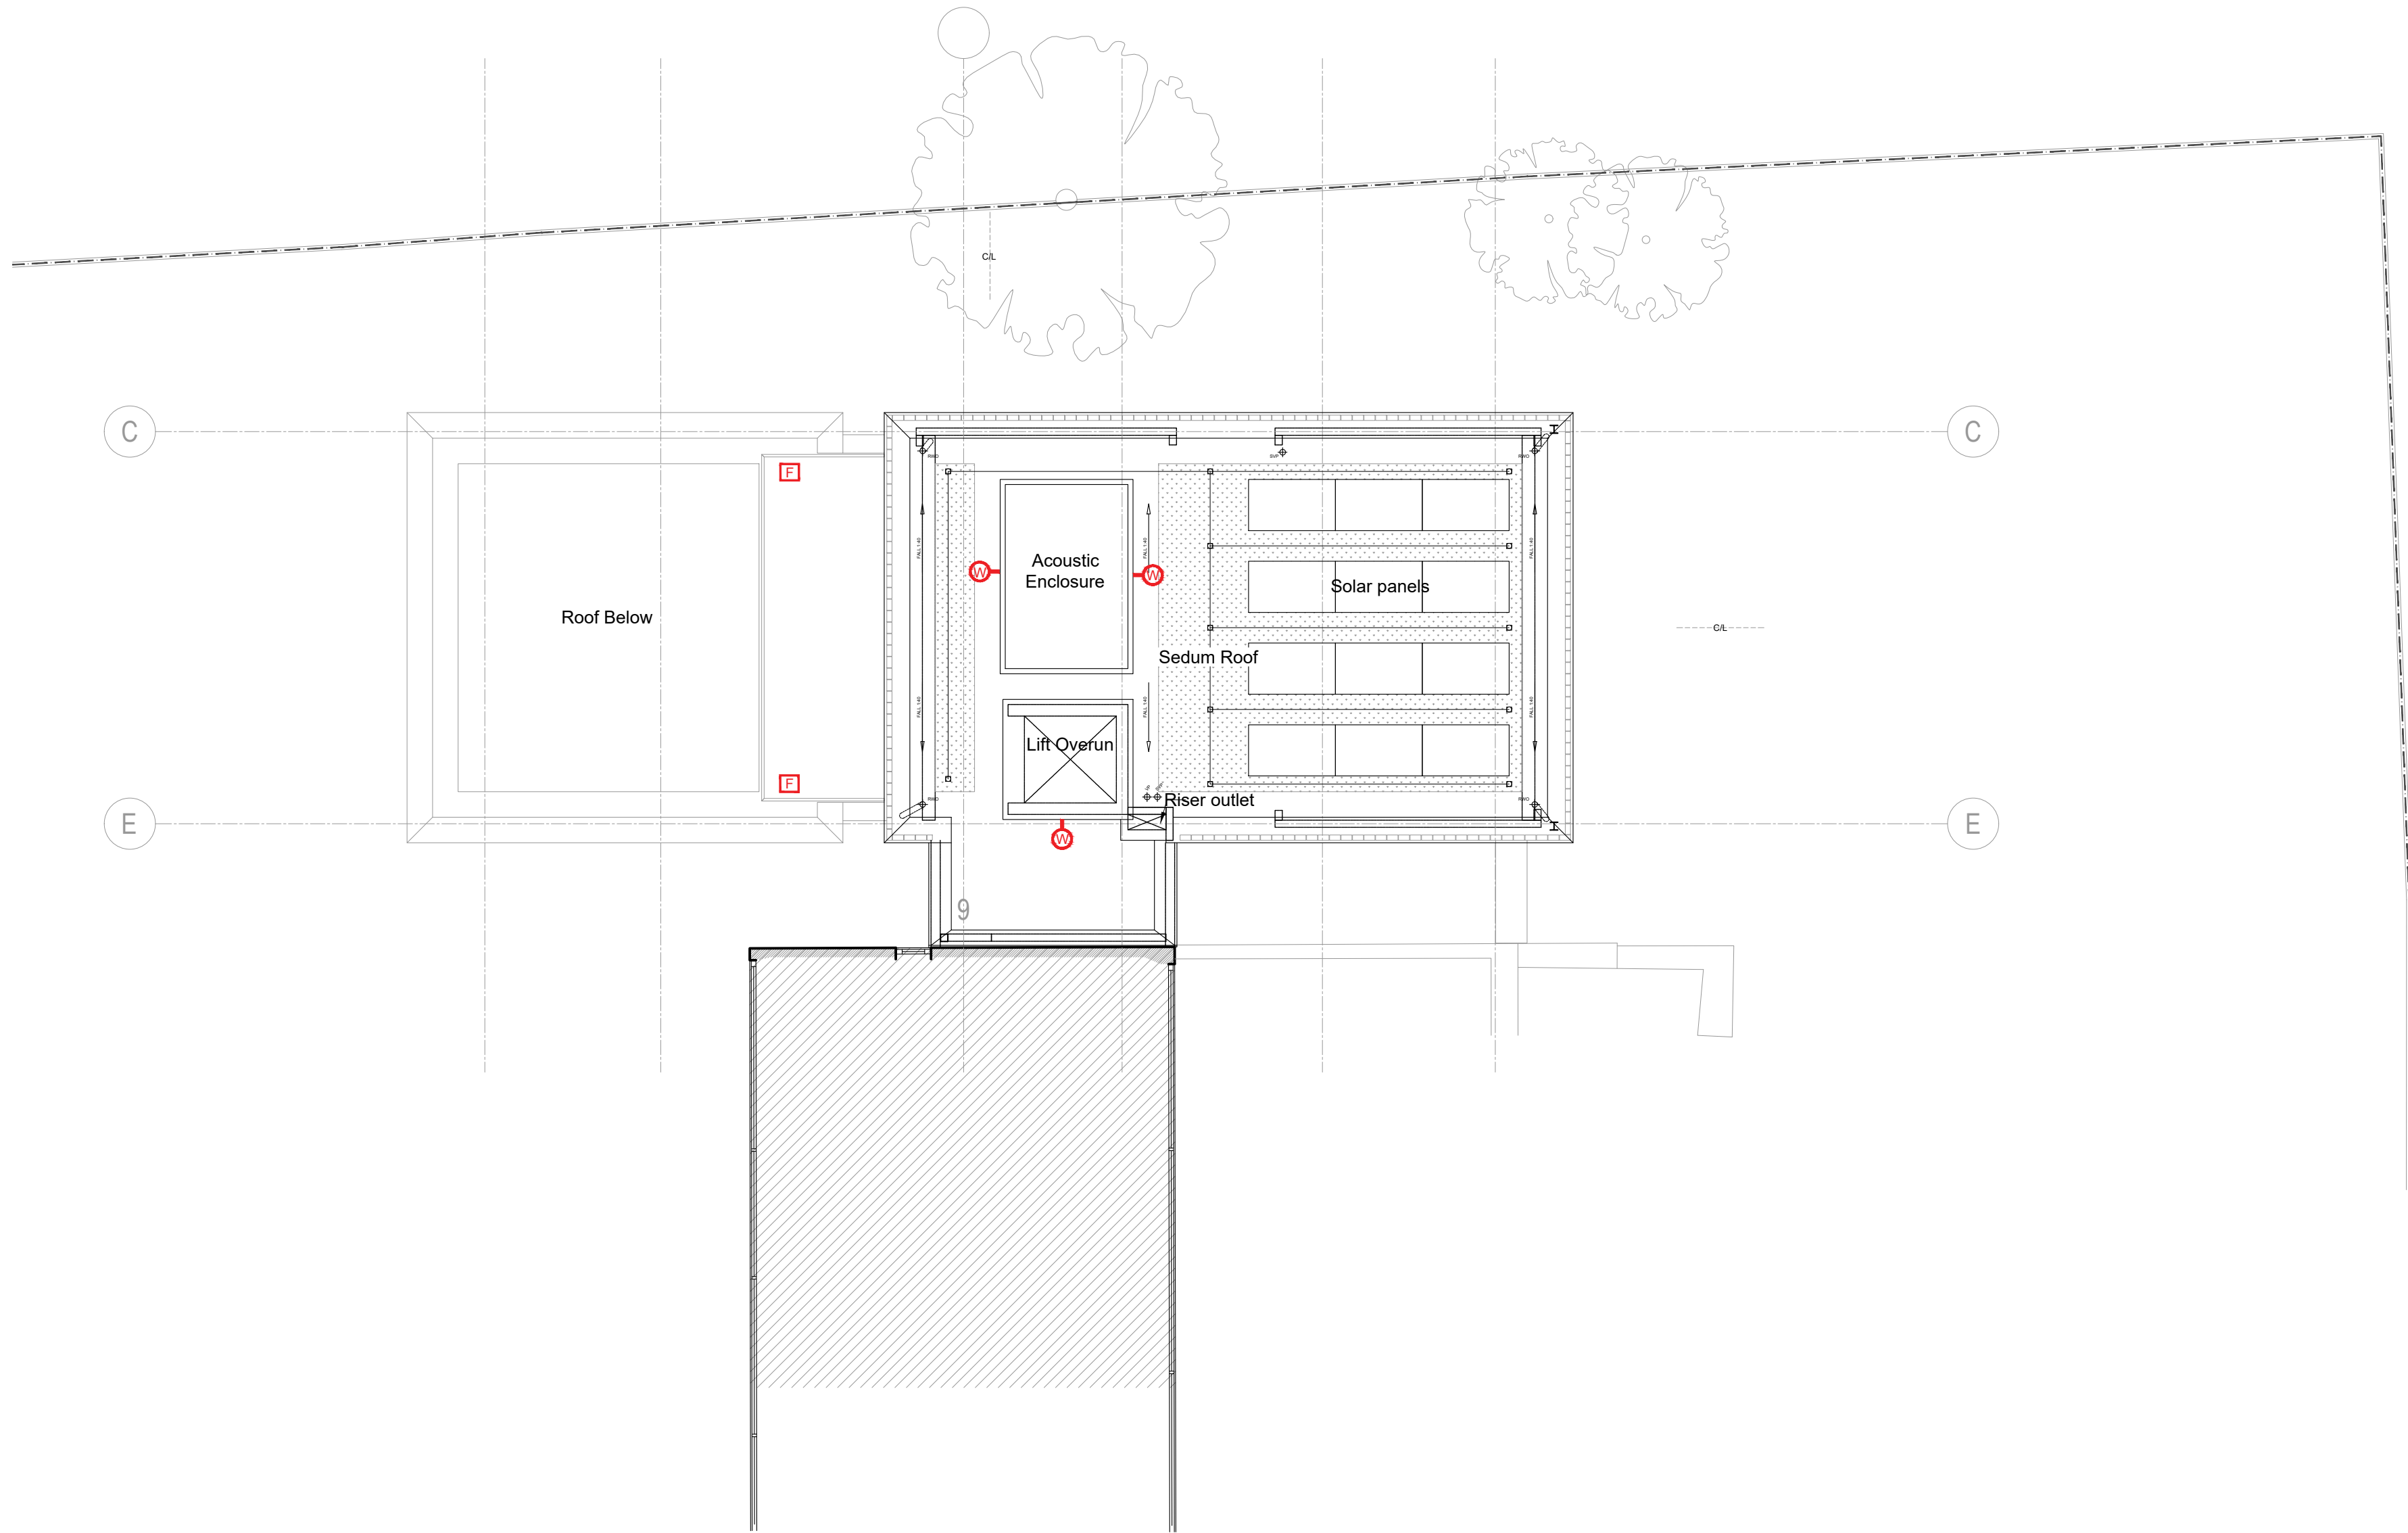

Project Ref. No.	2113		
Client	BROXWOOD VIEW LIMITED		
Date	NOVEMBER 2022		
Scale	1:100 @ A1		
Project	BROXWOOD VIEW, 29 ST EDMUNDS TERRACE, LONDON NW8 7QH		
Drawing Name	PROPOSED ROOF LIGHTING PLAN		
Drawing No.	EL102	Rev.	-
Drawn	CF	Approved	AC Signed