
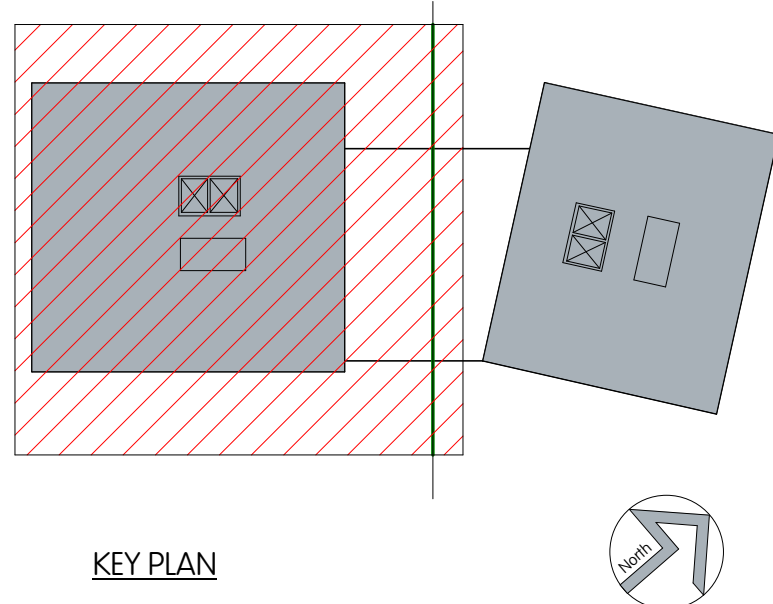



NOTES

NOTES

- This drawing is for engineering services only and is to be read in conjunction with all relevant MTT drawings and the Contract specification and the Contract specification.
- THIS IS NOT AN INSTALLATION DRAWING. IT IS A DESIGN DRAWING.
- All services routes and equipment locations are indicative, actual location and configuration to be determined by contractor following completion of contractor design and coordination of construction.
- This drawing will only be issued in PDF format.

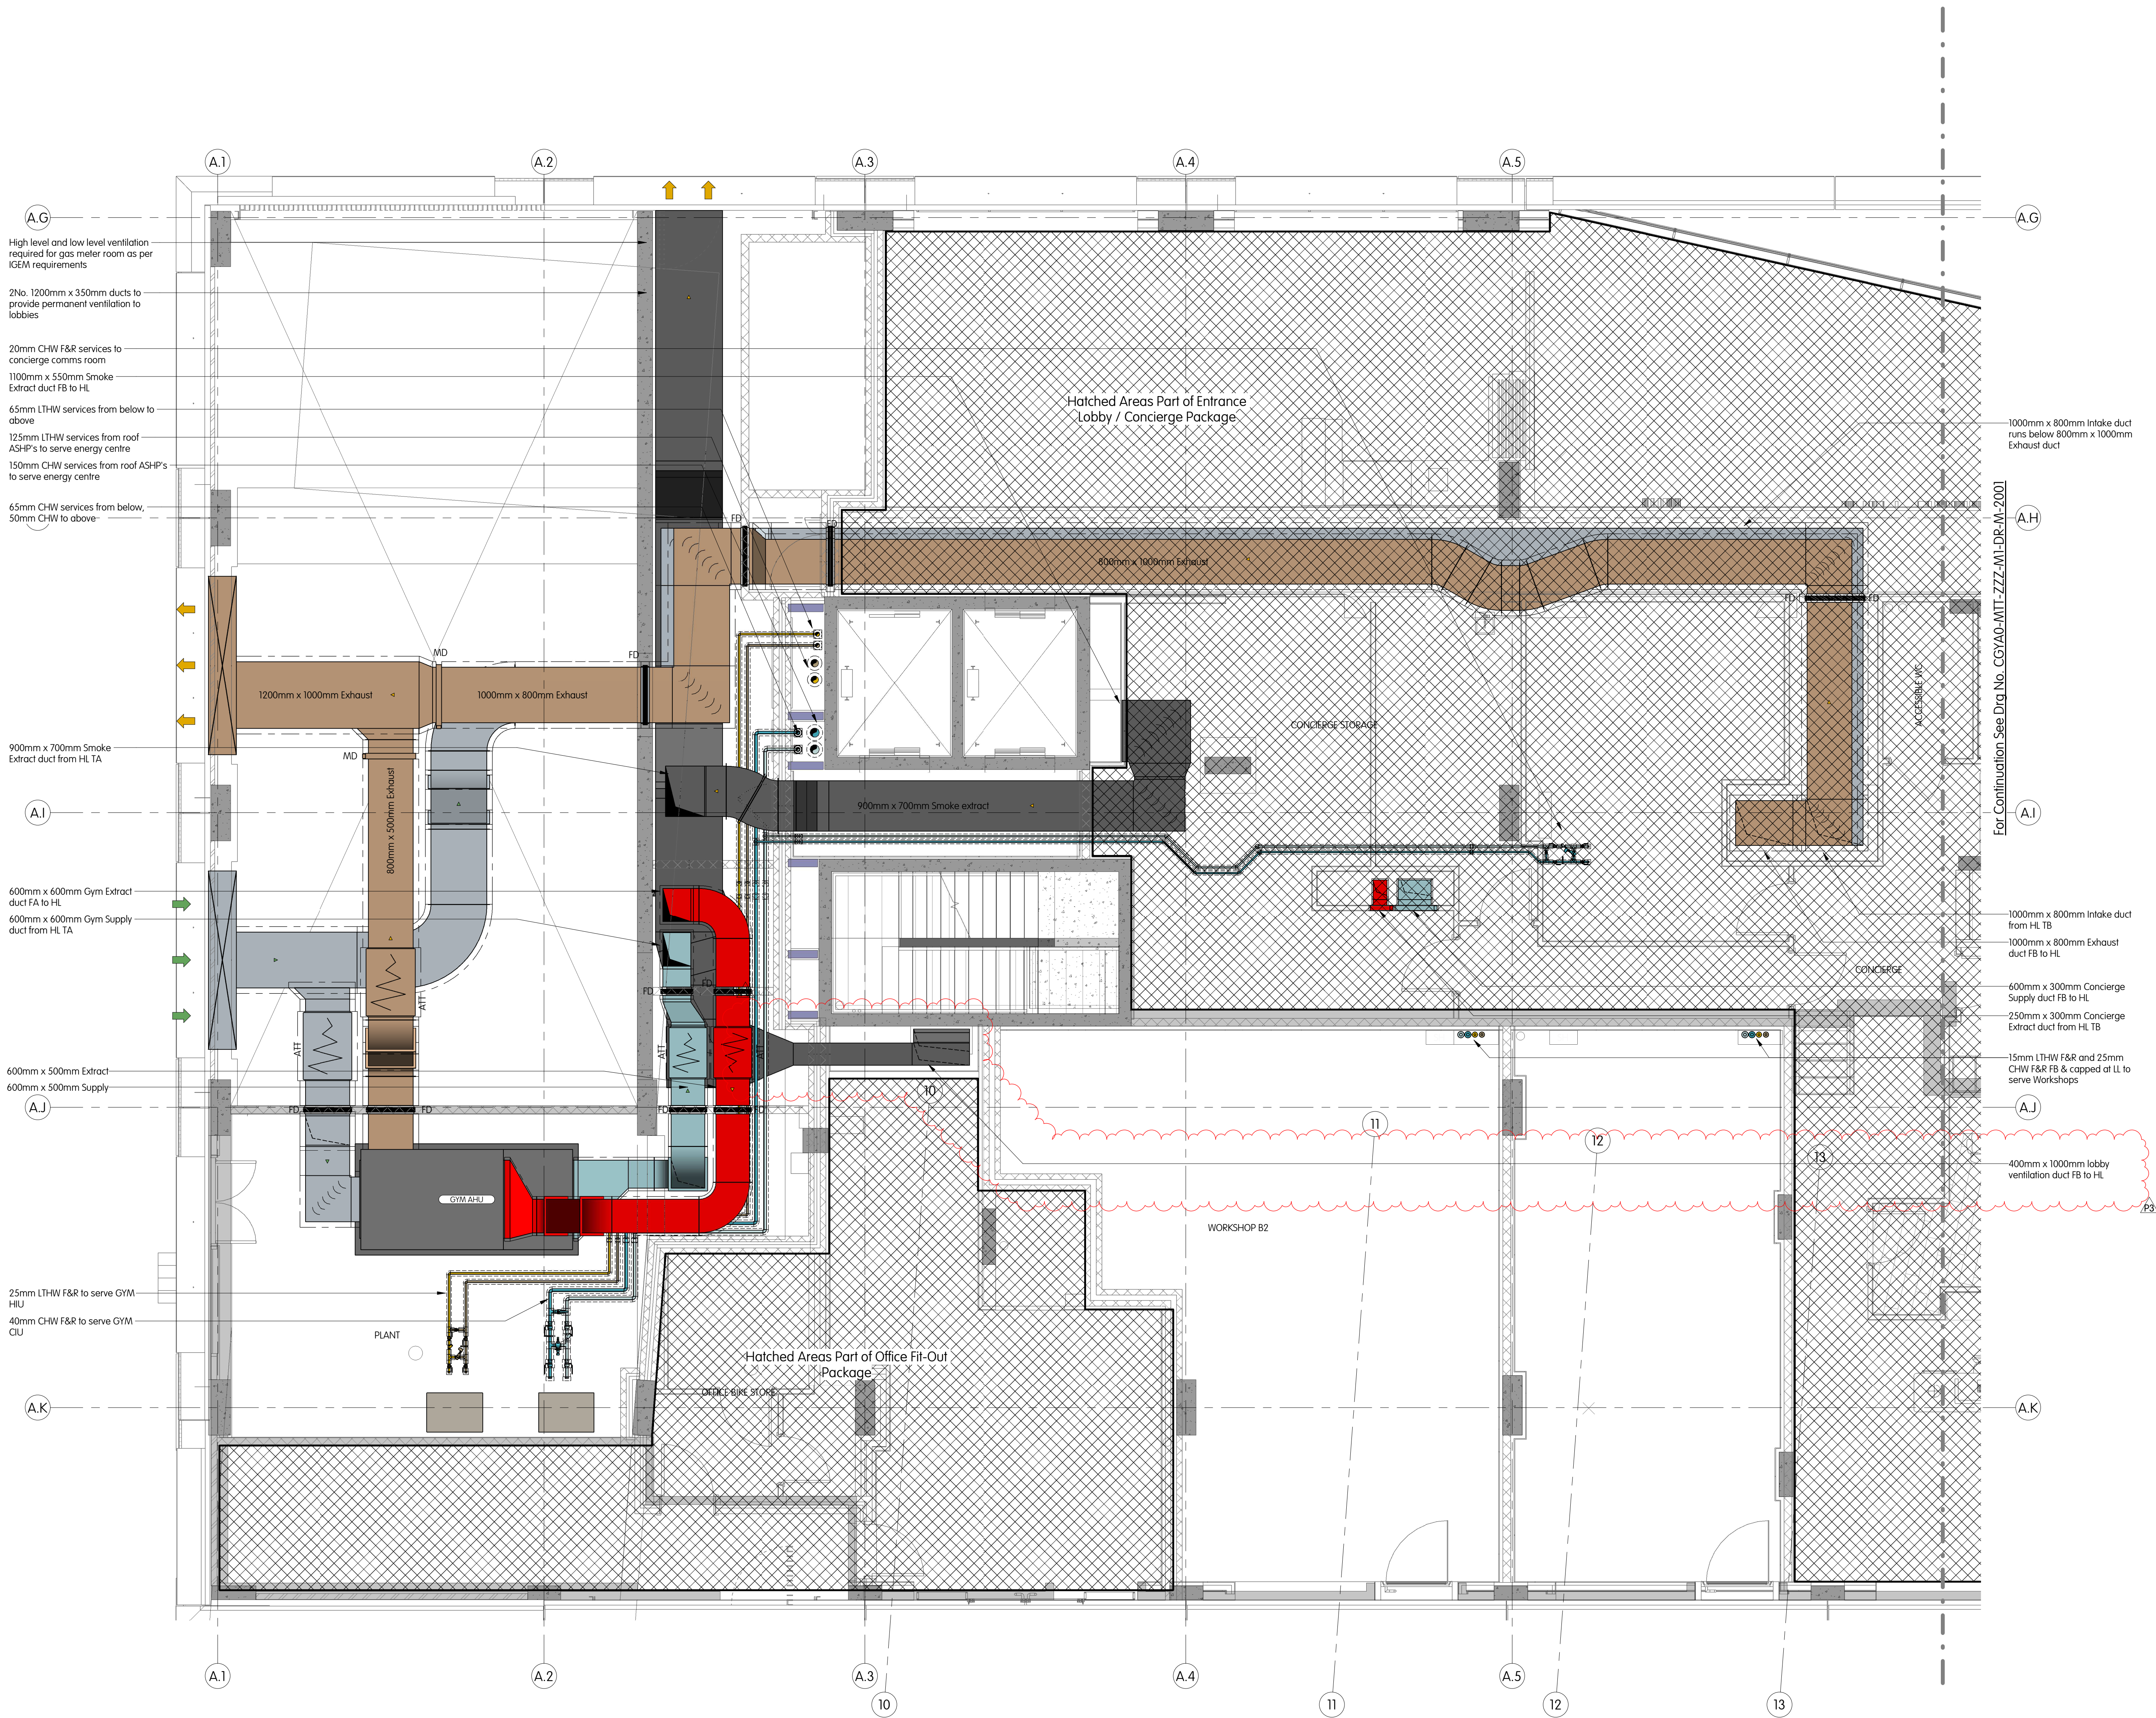

Copyright by MTT. No copies of this drawing, however produced and/or transmitted may be made or undertaken, without the express permission of MTT.					
This drawing should not be scaled. All dimensions to be checked on site. Any discrepancies to be notified to MTT.	P3	12.04.2022	Stage 4 Issue	NK	JM
Based on architectural input: CGYA-M1-ZZZ-22-03-08-0001-v01 Date: 02.04.2022	P2	08.04.2022	Stage 4 Issue	NK	JM
Comments incorporated: CGYA-M1-ZZZ-22-03-05-0001-v01 Date: 02.04.2022	P1	08.02.2022	Stage 4 Issue	NK	BC
Rev.	Date	Description	Drawn	Checked	

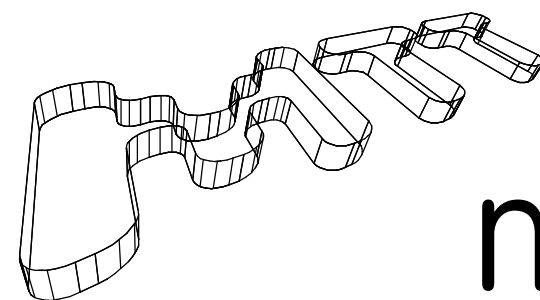

MTT/DRAWING

A 9 KINGSWAY  
LONDON  
WC2B 6NF  
T +44 (0)20 7836 1133  
F +44 (0)20 7836 1153  
E info@mtt-limited.com  
W mtt-limited.com

PM T Ward  
Cof N Keyser  
Date February 2022  
Scale 1:50 @ A0  
Status **STAGE 4**

Camden Goods Yard  
Mechanical Layout  
Building A - Level M1  
Sheet 1 of 2

Dwg No: CGYA0-MTT-ZZZ-M1-DR-M-2000

Revision P3

