

Note:


 
Do not scale from this drawing. All dimensions to be checked on site.

This drawing is protected under Copyright and cannot be reproduced or copied without permission.


Revisions

A	Initial Issue	am	6.1.23

- CONSTRUCTION NOTES:
- PT - 01
FULL HEIGHT PARTITION CONSISTS AND LAYERS 12.5MM THK GYPROC WALLBOARD ON 48MM GYPROC METAL STUDS @ 600MM CTS WITH ISOVER 1200 INSULATION BATTS TO VOID. PLANTED ON 100 X 12MM SQUARE EDGE SHIRT.
- PT - 02
1800 MM HIGH PARTITION CONSISTS AND LAYERS 12.5MM THK GYPROC WALLBOARD ON 48MM GYPROC METAL STUDS @ 600MM CTS WITH PLANTED ON 100 X 12MM SQUARE EDGE SHIRT.
- PT - 03
FULL HEIGHT PARTITION AND DOULGOST CONSISTS AND LAYERS 12.5MM THK GYPROC WALLBOARD ON 75MM GYPROC METAL STUDS @ 600MM CTS WITH ISOVER 1200 INSULATION BATTS TO VOID. PLANTED ON 100 X 12MM SQUARE EDGE SHIRT.
- G - 01
NEW 2400MM HIGH SINGLE GLAZED PARTITION IN BLACK ALUMINIUM FRAMES AND TRACKS WITH FASTERBOARD SOLIDBOARD OVER FOR SERVICES COME AS PER CONSTRUCTION TYPE T-01.
- G
INDICATES GLAZED DOOR WITH IN BLACK ALUMINIUM FRAME 2100MM HIGH TO CO-ORDINATE WITH DOORS IN PAINTED SHED FRAMES.
- ALLOWANCE TO REDECORATE EXISTING PERIMETER TRIMMING AS NECESSARY TO ALLOW FOR MODIFICATIONS AND NEW INSTALLATIONS AS NOTED ON LO-2-004 SMALL POWER & DATA PLAN.

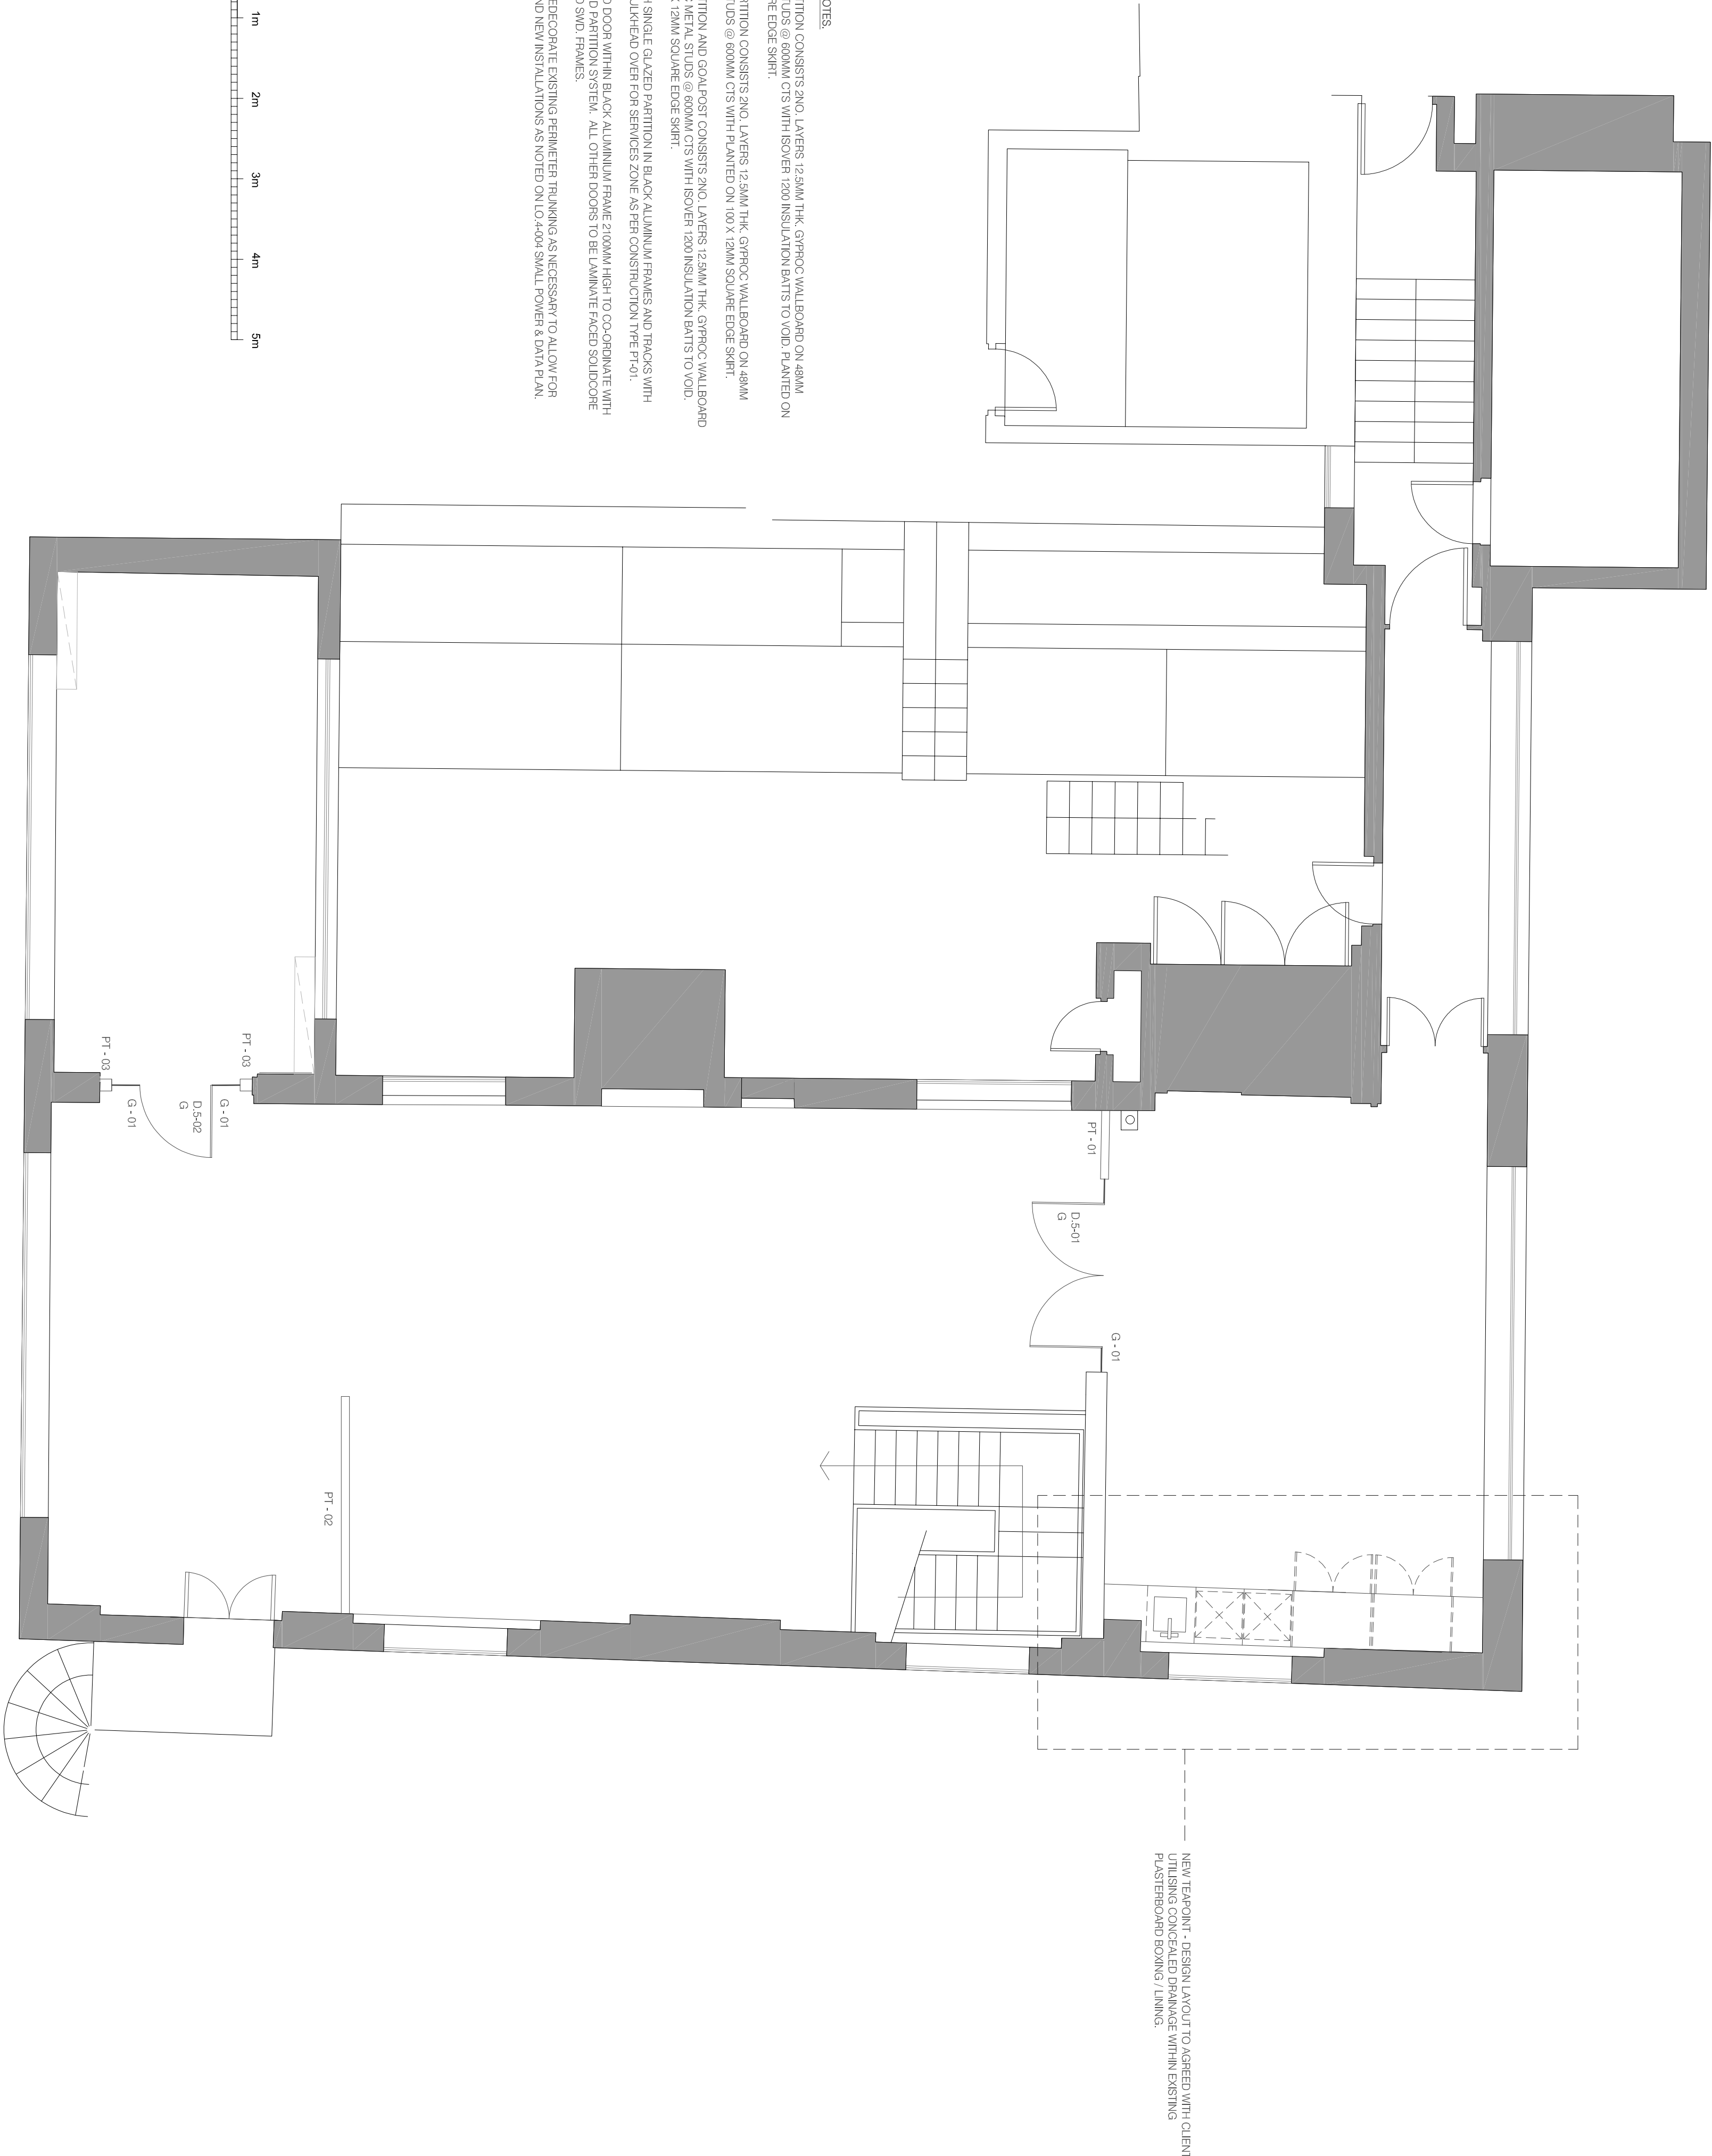

UNIT 5.2 GENERAL ARRANGEMENT PLAN
1:50 @ A1

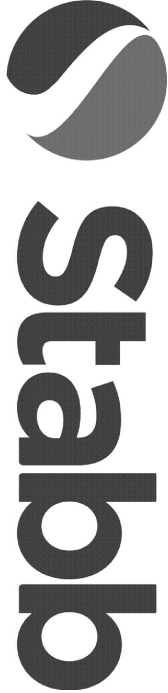

Office Design | Office Fit Out

Stabb Limited,
10 Northington Street
London WC1N 2JG.

t: +44 (0)20 7952 1500

Client
Bordeaux Index
Project
Unit 5.2
Heals Building London

General Arrangement Plan

Scale	Date		
1:50 @ A1	Jan 2023		
Project no.	Status	Dwg no.	Rev
S4918	LO	5-005	A

Size = A1