


EXISTING SECOND FLOOR PLAN

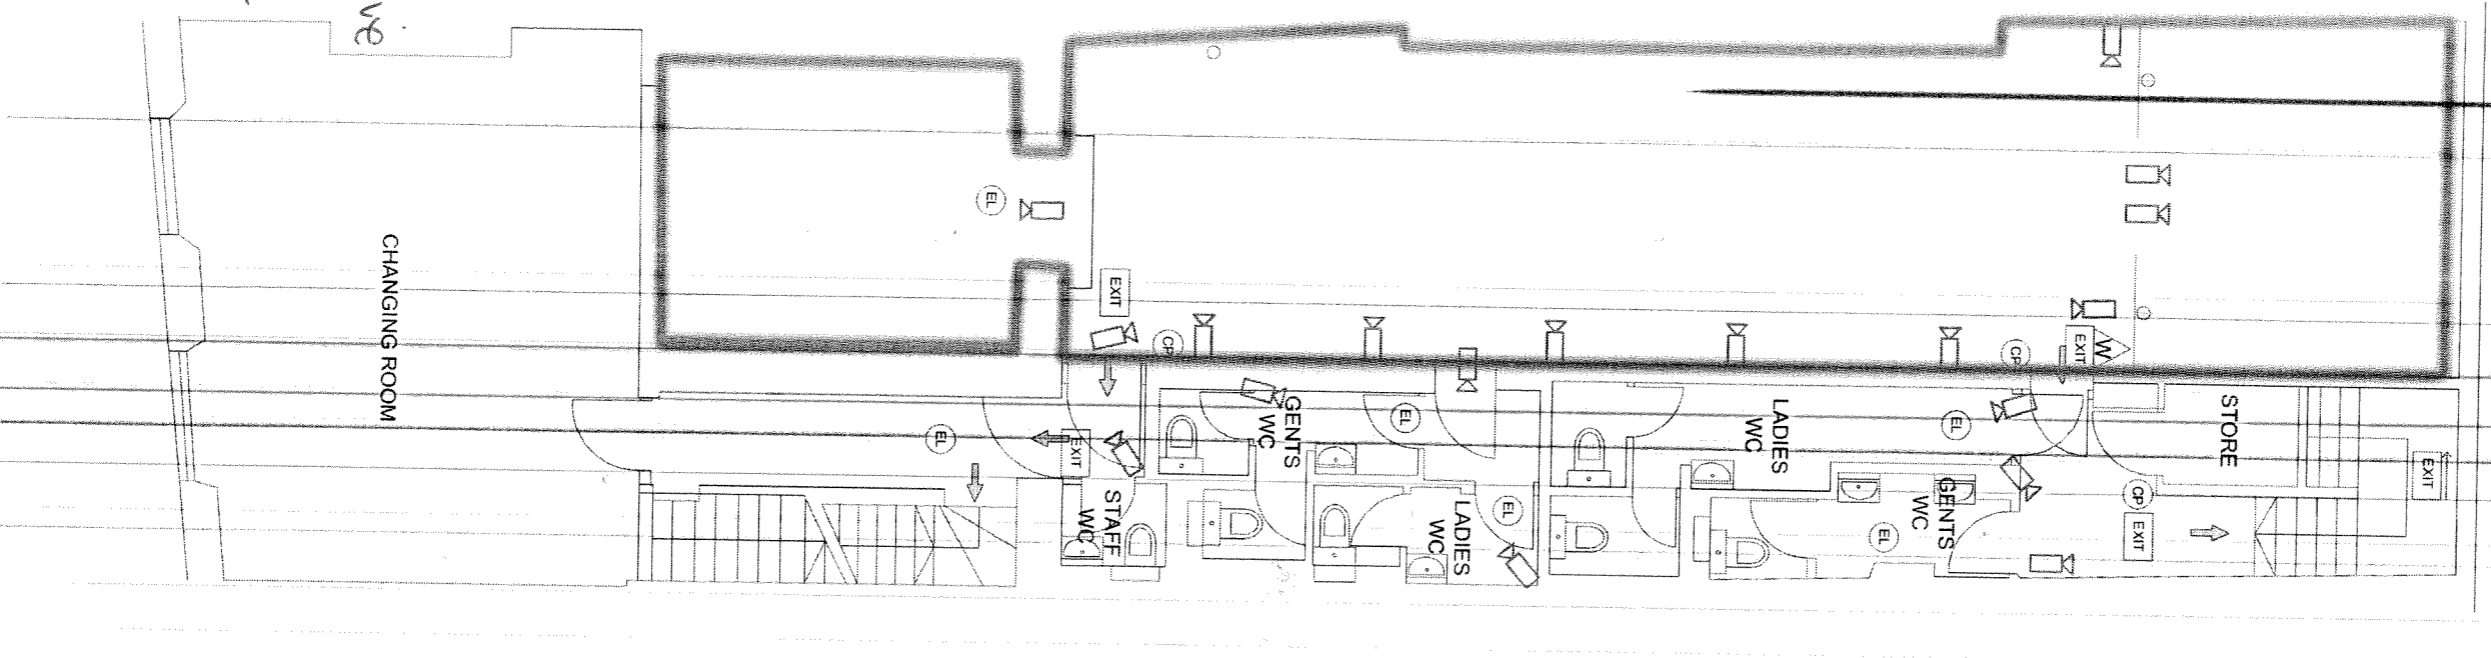

Loose furniture is indicative only.
 Movable activities take place anywhere within the premises

RED ROOMS
 4 GREAT QUEENS ST
 LONDON
 WC2

LEGENDS	
	FIRE ALARM
	FIRE CALL POINT
	RESERVED FOR SIGNING AND INSTALLATION DESIGNATED PERSONS ONLY (MOUNTED WITH BATTERY)
	MANS OPERATED, SELF-CONTAINED, SMOKE DETECTORS TO BS 58W Pt. 1:90
	2.2KGS CARBON DIOXIDE
	FIRE BLANKET IN CONTAINER
	9L WATER EXTINGUISHER
	FIRE EXIT SIGN (WALL MOUNTED)
	FIRE EXIT SIGN
	CCTV
	VIEWING MONITOR
	FIRE EXIT
	DISABLE ACCESS/ EXIT

Drawing Reference: RRSE C1

SCALE: 1:100 @A3

Revision: A002

Rev A002-
 additional CCTV installed

DRAWING BY: