



- Key to Drawing
- Air supply/extract grille
 - Consumer unit
 - Mains powered smoke detector with battery backup.
 - Mains powered heat detector with battery backup.
 - foul drainage connection. Allow for adjacent hot and cold water supply
 - Telescopic ventilator outlet

All dimensions to be confirmed on site

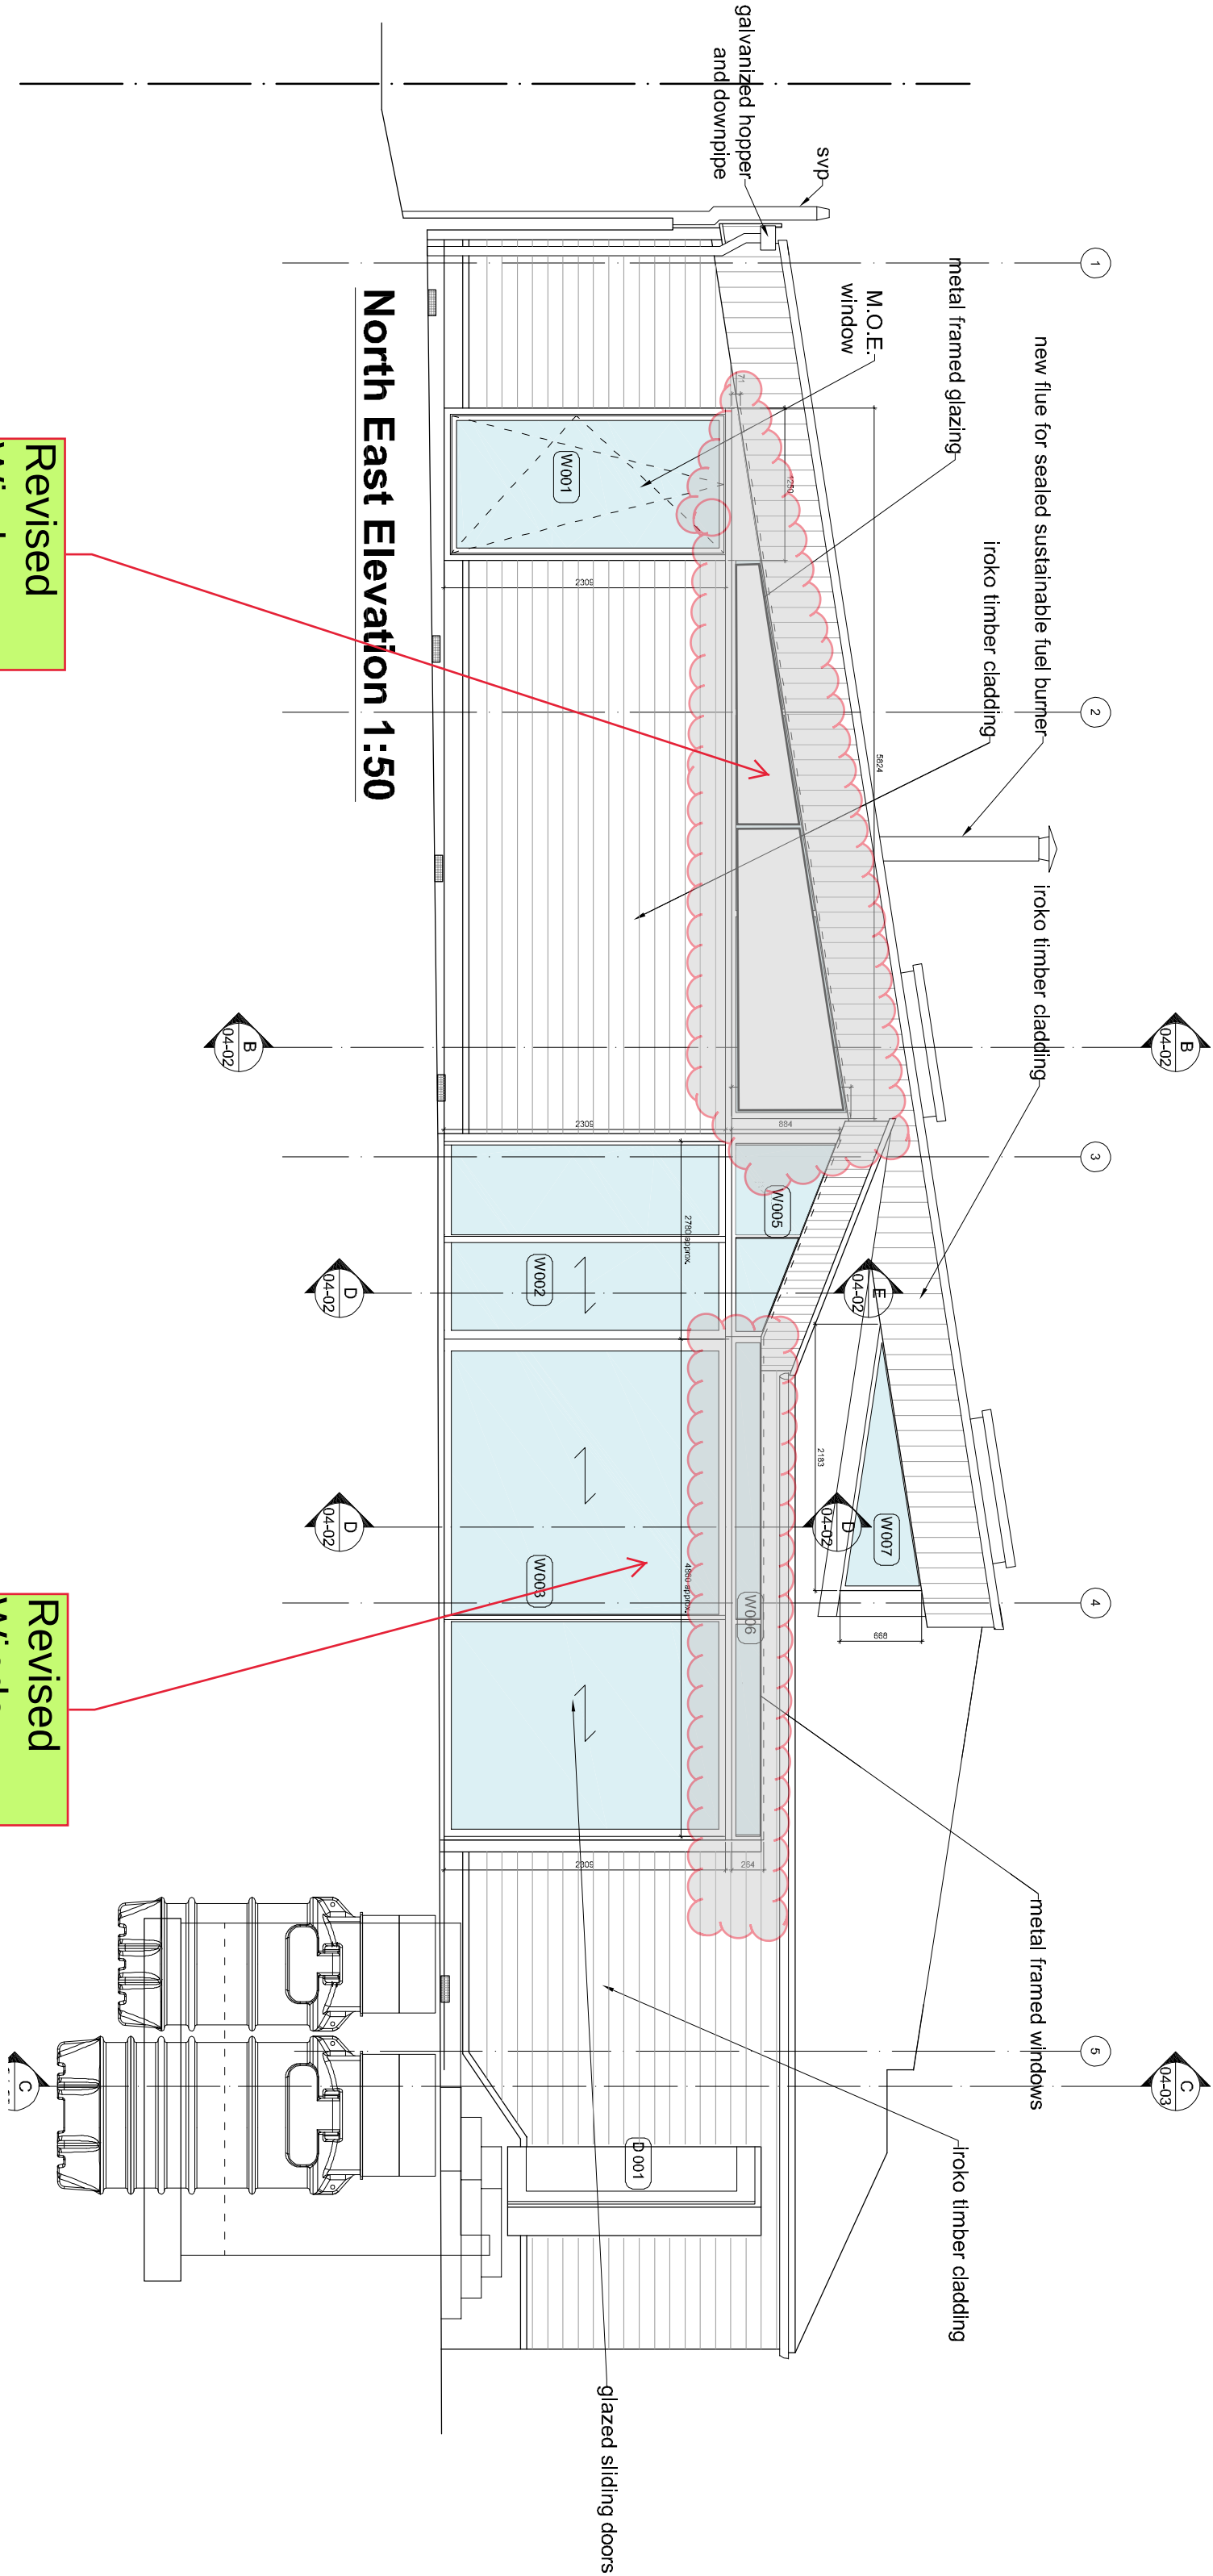


Revised Window details and pattern


Revised Window details and pattern

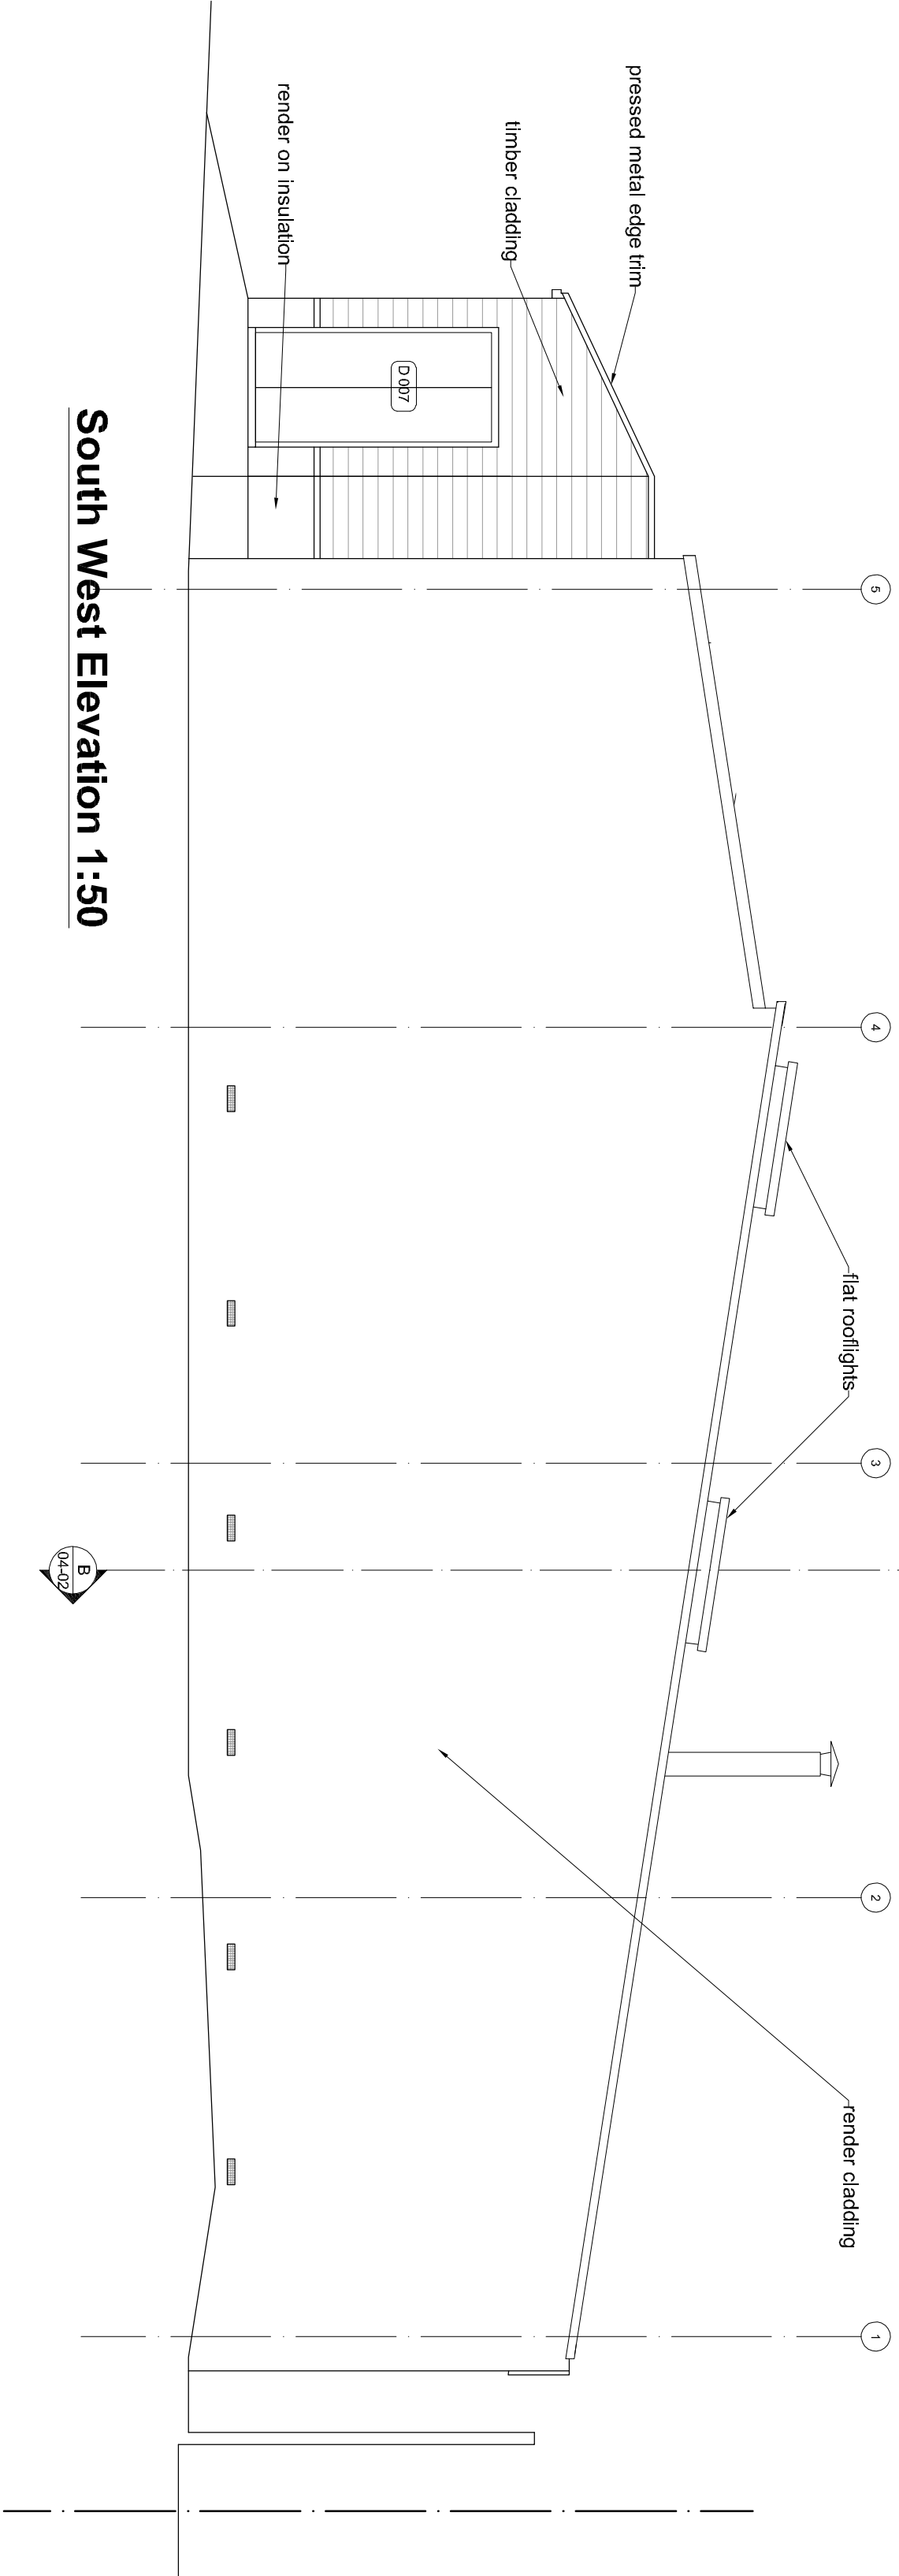

South West Elevation 1:50

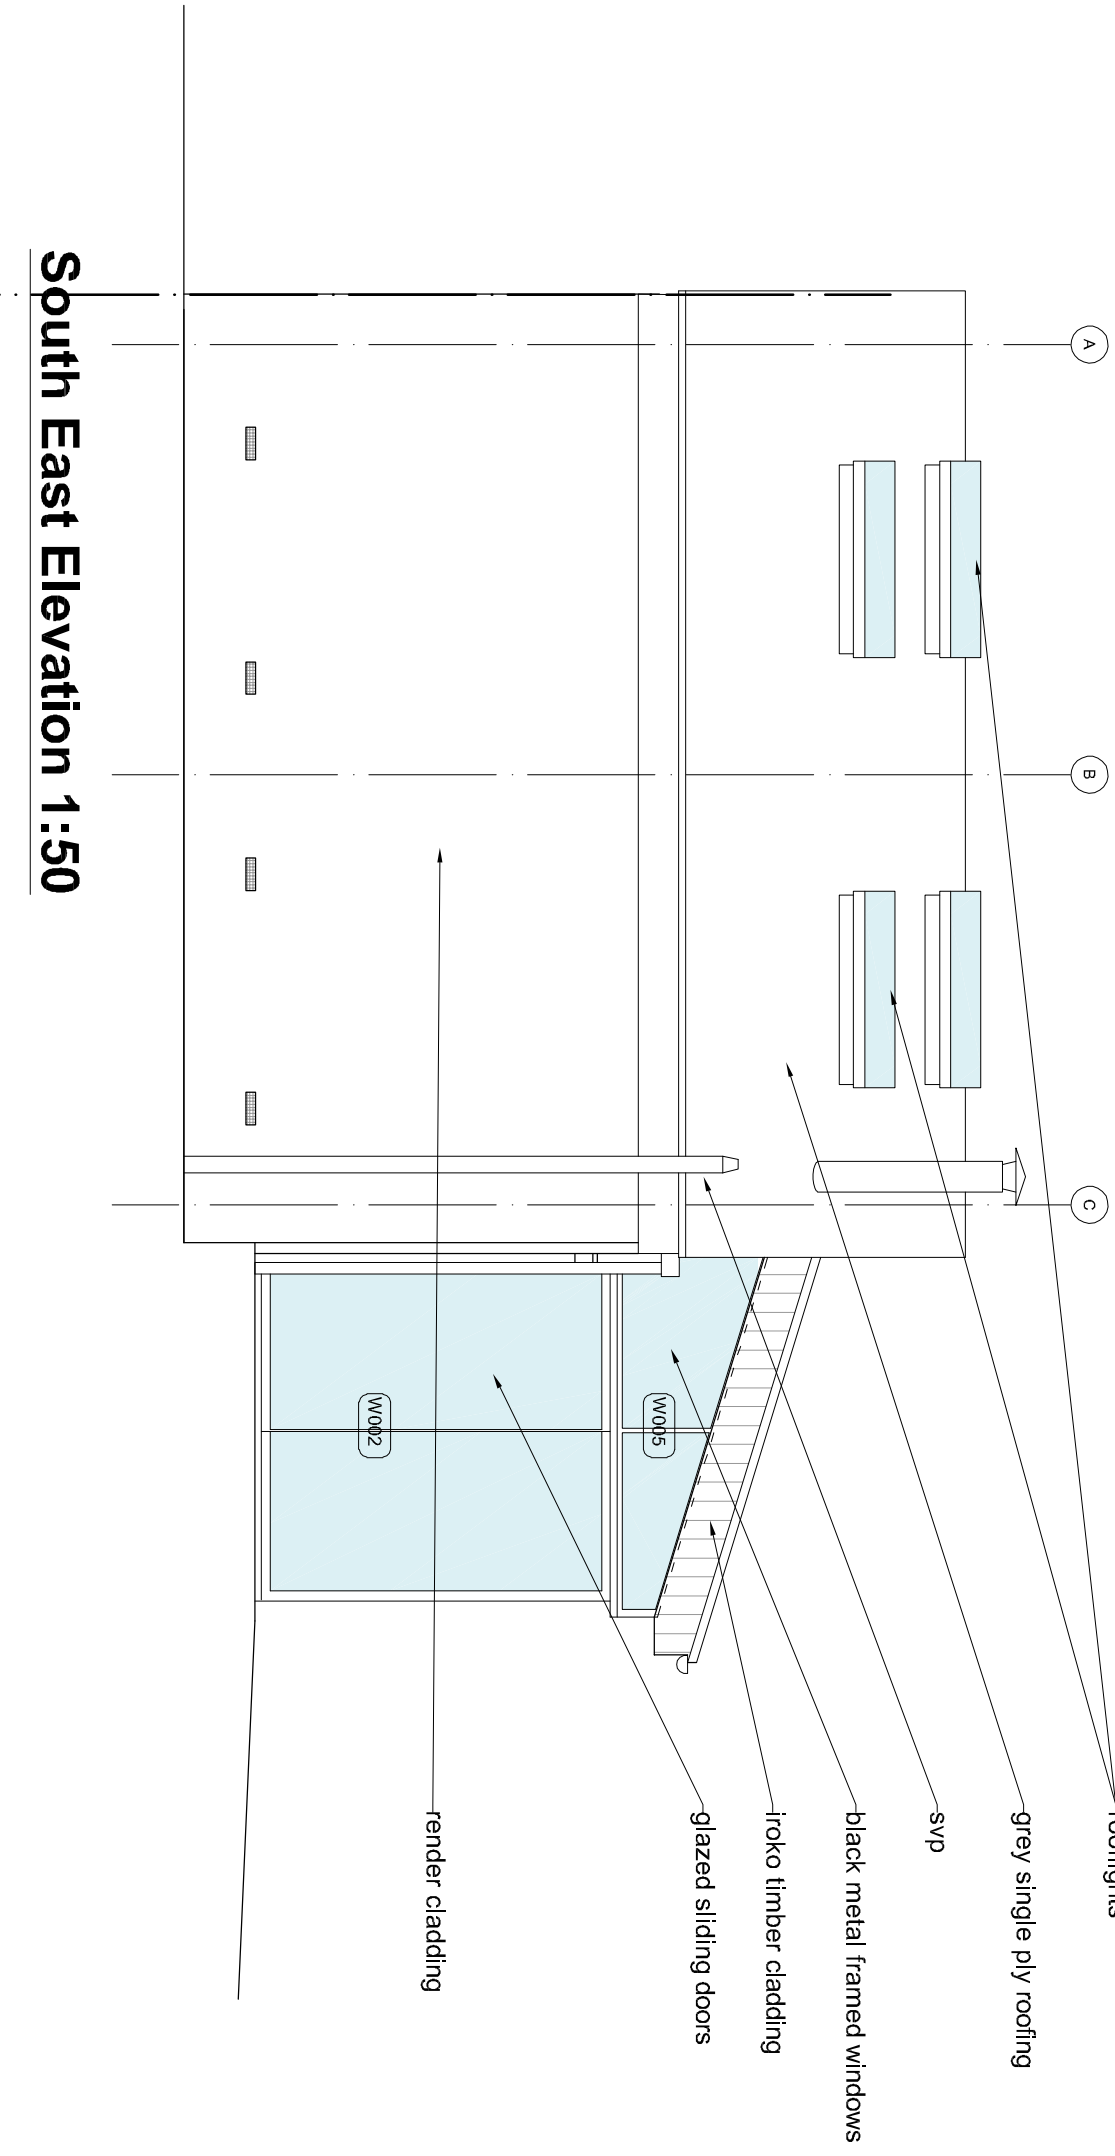

South East Elevation 1:50

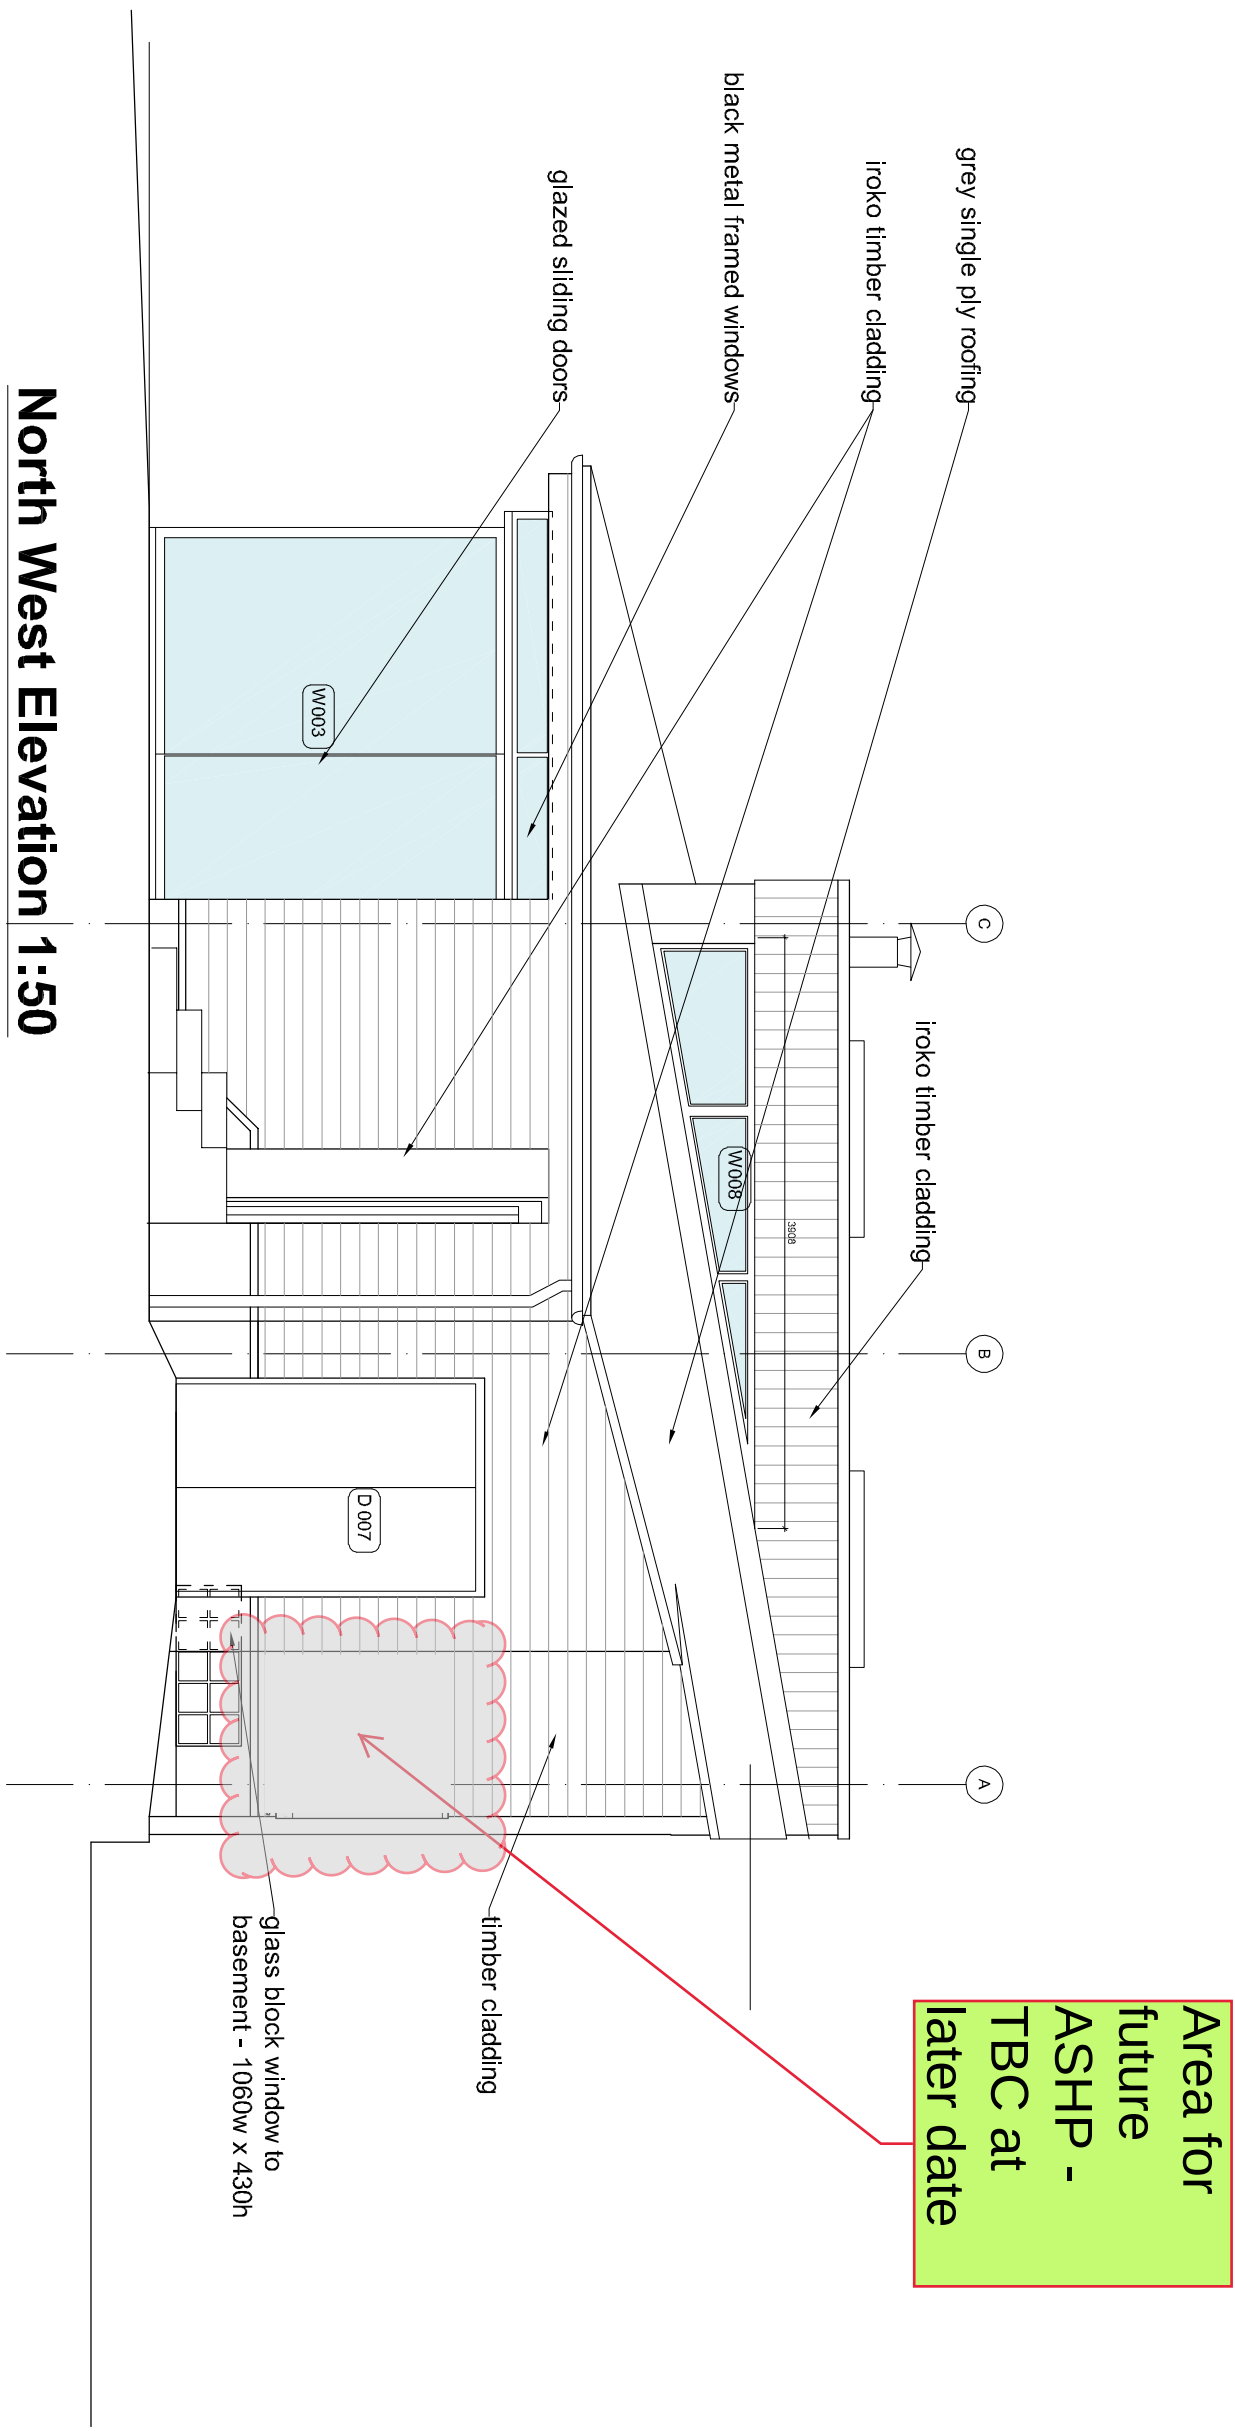

North West Elevation 1:50

Rev	Description	Date
E	General Updates	14/12/2021
D	General Updates	13/10/2021
C	General Updates	08/10/2021
B	Updated to client comments	07/08/2021
A	Updated to client comments	03/08/2021

Do not scale from this drawing

NOADES
architects

4 Penn Way
Cherrywood
Hertfordshire
WD3 5HQ
01923 282360
www.noadesarchitects.com

Client
Barry Blackledge
Project
5 Paisfal Road
Garden Studio
Description
GA Elevations

Scale	Drawn	Date
1:50@A1	MN	Nov'20
Job No.	Drawing No.	Rev
4077	05-01	E