

PROPOSED MEZZANINE FLOOR POWER & DATA LAYOUT
 SCALE 1:50

POWER LEGEND

- | | | | |
|--|--|--|--|
| | Double Switched Socket Outlet with USB socket (DSSOU)
Finish: Brushed Stainless Steel | | Gas |
| | Double Switched Socket Outlet (DSSO)
Finish: Brushed Stainless Steel | | Finger Sign-in Reader
Cat5 Data Cable Required |
| | Double Switched Floor Socket Outlet (DSFSD)
Finish: Brushed Stainless Steel | | Telephone / data RJ45 Point |
| | Single Switched Floor Socket Outlet (SSFSO)
Finish: Brushed Stainless Steel | | Electrical Distribution Board |
| | Single Switched Socket Outlet (SSSO)
Finish: Brushed Stainless Steel | | Fire Alarm Panel |
| | Fused Spur
Finish: Brushed Stainless Steel | | AC Control Panel |
| | Command Socket | | Carbon Dioxide & Water extinguishers |
| | 3ph / 400V Isolator | | Fire Blanket |
| | Isolator switch | | Single Phase for mega flow immersion heater & hot water circulation pump |

DRAWING KEY


- Retain existing power and use for Proposed equipment
- All existing works to be fully check by electrical contractor - TBC
- Proposed new power
- Removed
- Retain existing power for future

*All electrical & equipment specification sheets provide by electrical contractor

PROPOSED MEZZANINE FLOOR POWER & DATA PLAN


1. Dry Storage - Area 29.6 sqm (CH:2100mm)
2. Cold Room - Area 5 sqm (CH:2100mm)
3. Plant Room - Area 2.9 sqm
4. Refuse store - Area 0.9 sqm (CH:2100mm)

Mezzanine Floor Area : 44.5 sqm
 Total Unit Area : 294.9 sqm

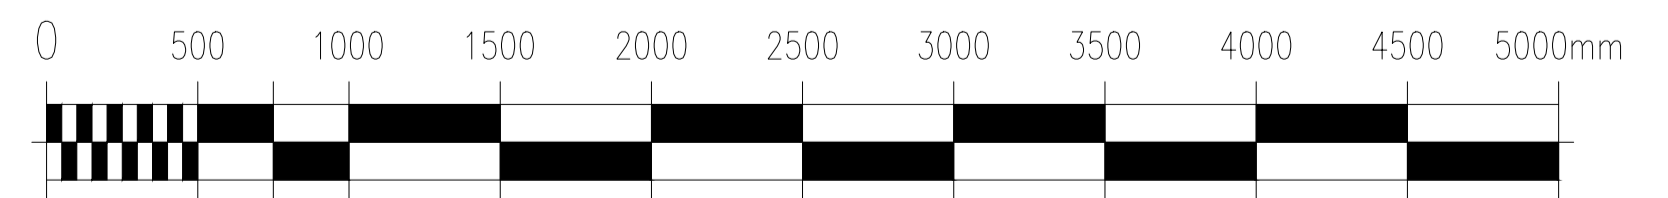

NOTE

All dimensions to be checked on site prior to commencement of any works.
 This drawing represents a performance guide upon which the contractor/subcontractor must base his/her working drawings & details. Include all necessary tolerances prior to manufacture and installation.
 Contractor must undertake a full survey of the area to establish all dimensions & ensure accurate setting out.
 Advise on suitability of all details shown to ensure structural stability, ease and economy of construction.

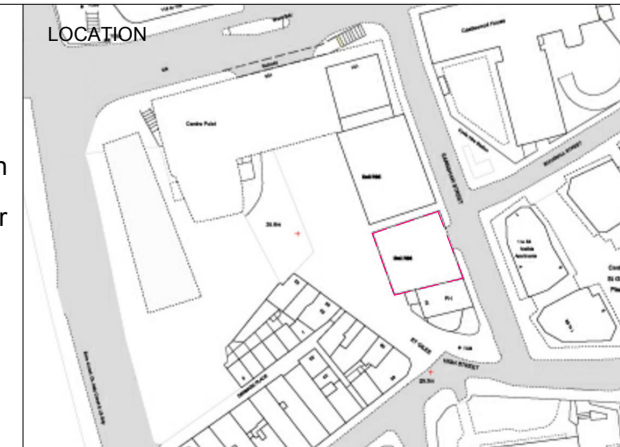

studio penn london
 Architecture & Interior Design

job title	SEOUL PLAZA - UNIT R06 & R08 CENTRE POINT		
drawing title / location	PROPOSED POWER & DATA LAYOUT MEZZANINE FLOOR		
drawn by	checked by	scale	status
JL	YH	1 : 50 @ A1 / 100 @ A3	PLANNING
project	classification / drawing no.	revision	
2205	2205.CP.DE.320		