

 


















KEY

PROGRAMME

Refuse Store, Dry storage, Cold room, Plant Room

Keep existing lights


DRAWING KEY

-  Security Camera : Keep existing ceiling mounted security camera
-  Speaker - Keep existing hanging speaker
-  AC units - Keep existing AC and Existing location
-  Existing Wall Mounted AC - Keep existing AC and location
-  Ventilation : 600mm X 600mm
-  Recessed LED Ceiling Panel Light - Keep existing LED ceiling panel
-  600 x 600mm Hatch(White)
-  Existing Plead G3 recessed circular fixed spot light Colour : White
Total Lumens : 1732
Kelvin : 3000 K
-  Existing Type E recessed emergency LED cat no. spldee3/105/E3/WH+L stand alone recessed LED emergency downlight 105 degree beam complete with 3 hour emergency
-  Existing LED Wall mounted emergency twin spot light - Spec TBC
-  New Modern recessed spot light - TBC
Colour : White
Material : Aluminium
Diameter 16mm, height 9.8mm
Voltage : 220V/230V
Total wattage : 11 Watt
Total Lumens : 820
Kelvin : 3000 K
-  New Emergency Spot Light with a maintained emergency battery pack or similar. spec - TBC
-  Existing flush mounted PIR ceiling recessed flush mounted 360 degree PIR occupancy switch. White finish. 72 dia 68h. ref: CP electronics GEFL flush mounted.
-  Pendant Light
Decorative cylinder shape pendant spec - TBC
-  Existing Smoke Detector
-  New Heat Detector
-  Existing Ventilation Q-150
-  Existing type KIE all BOH areas General compact 56603E + 2 x 81222 cover surface mounted linear IP65 corrosion resistant bulkhead luminaire
-  Existing FAZILLO recessed adjustable LED downlight (White) cat no. FAZI 151.27.35 1220 Lumen 2700K 35° beam

Proposed New lights

-  **New Security Camera :**
Ceiling mounted security camera

Note: Keep using existing ceiling in all mezzanine floor and make good condition

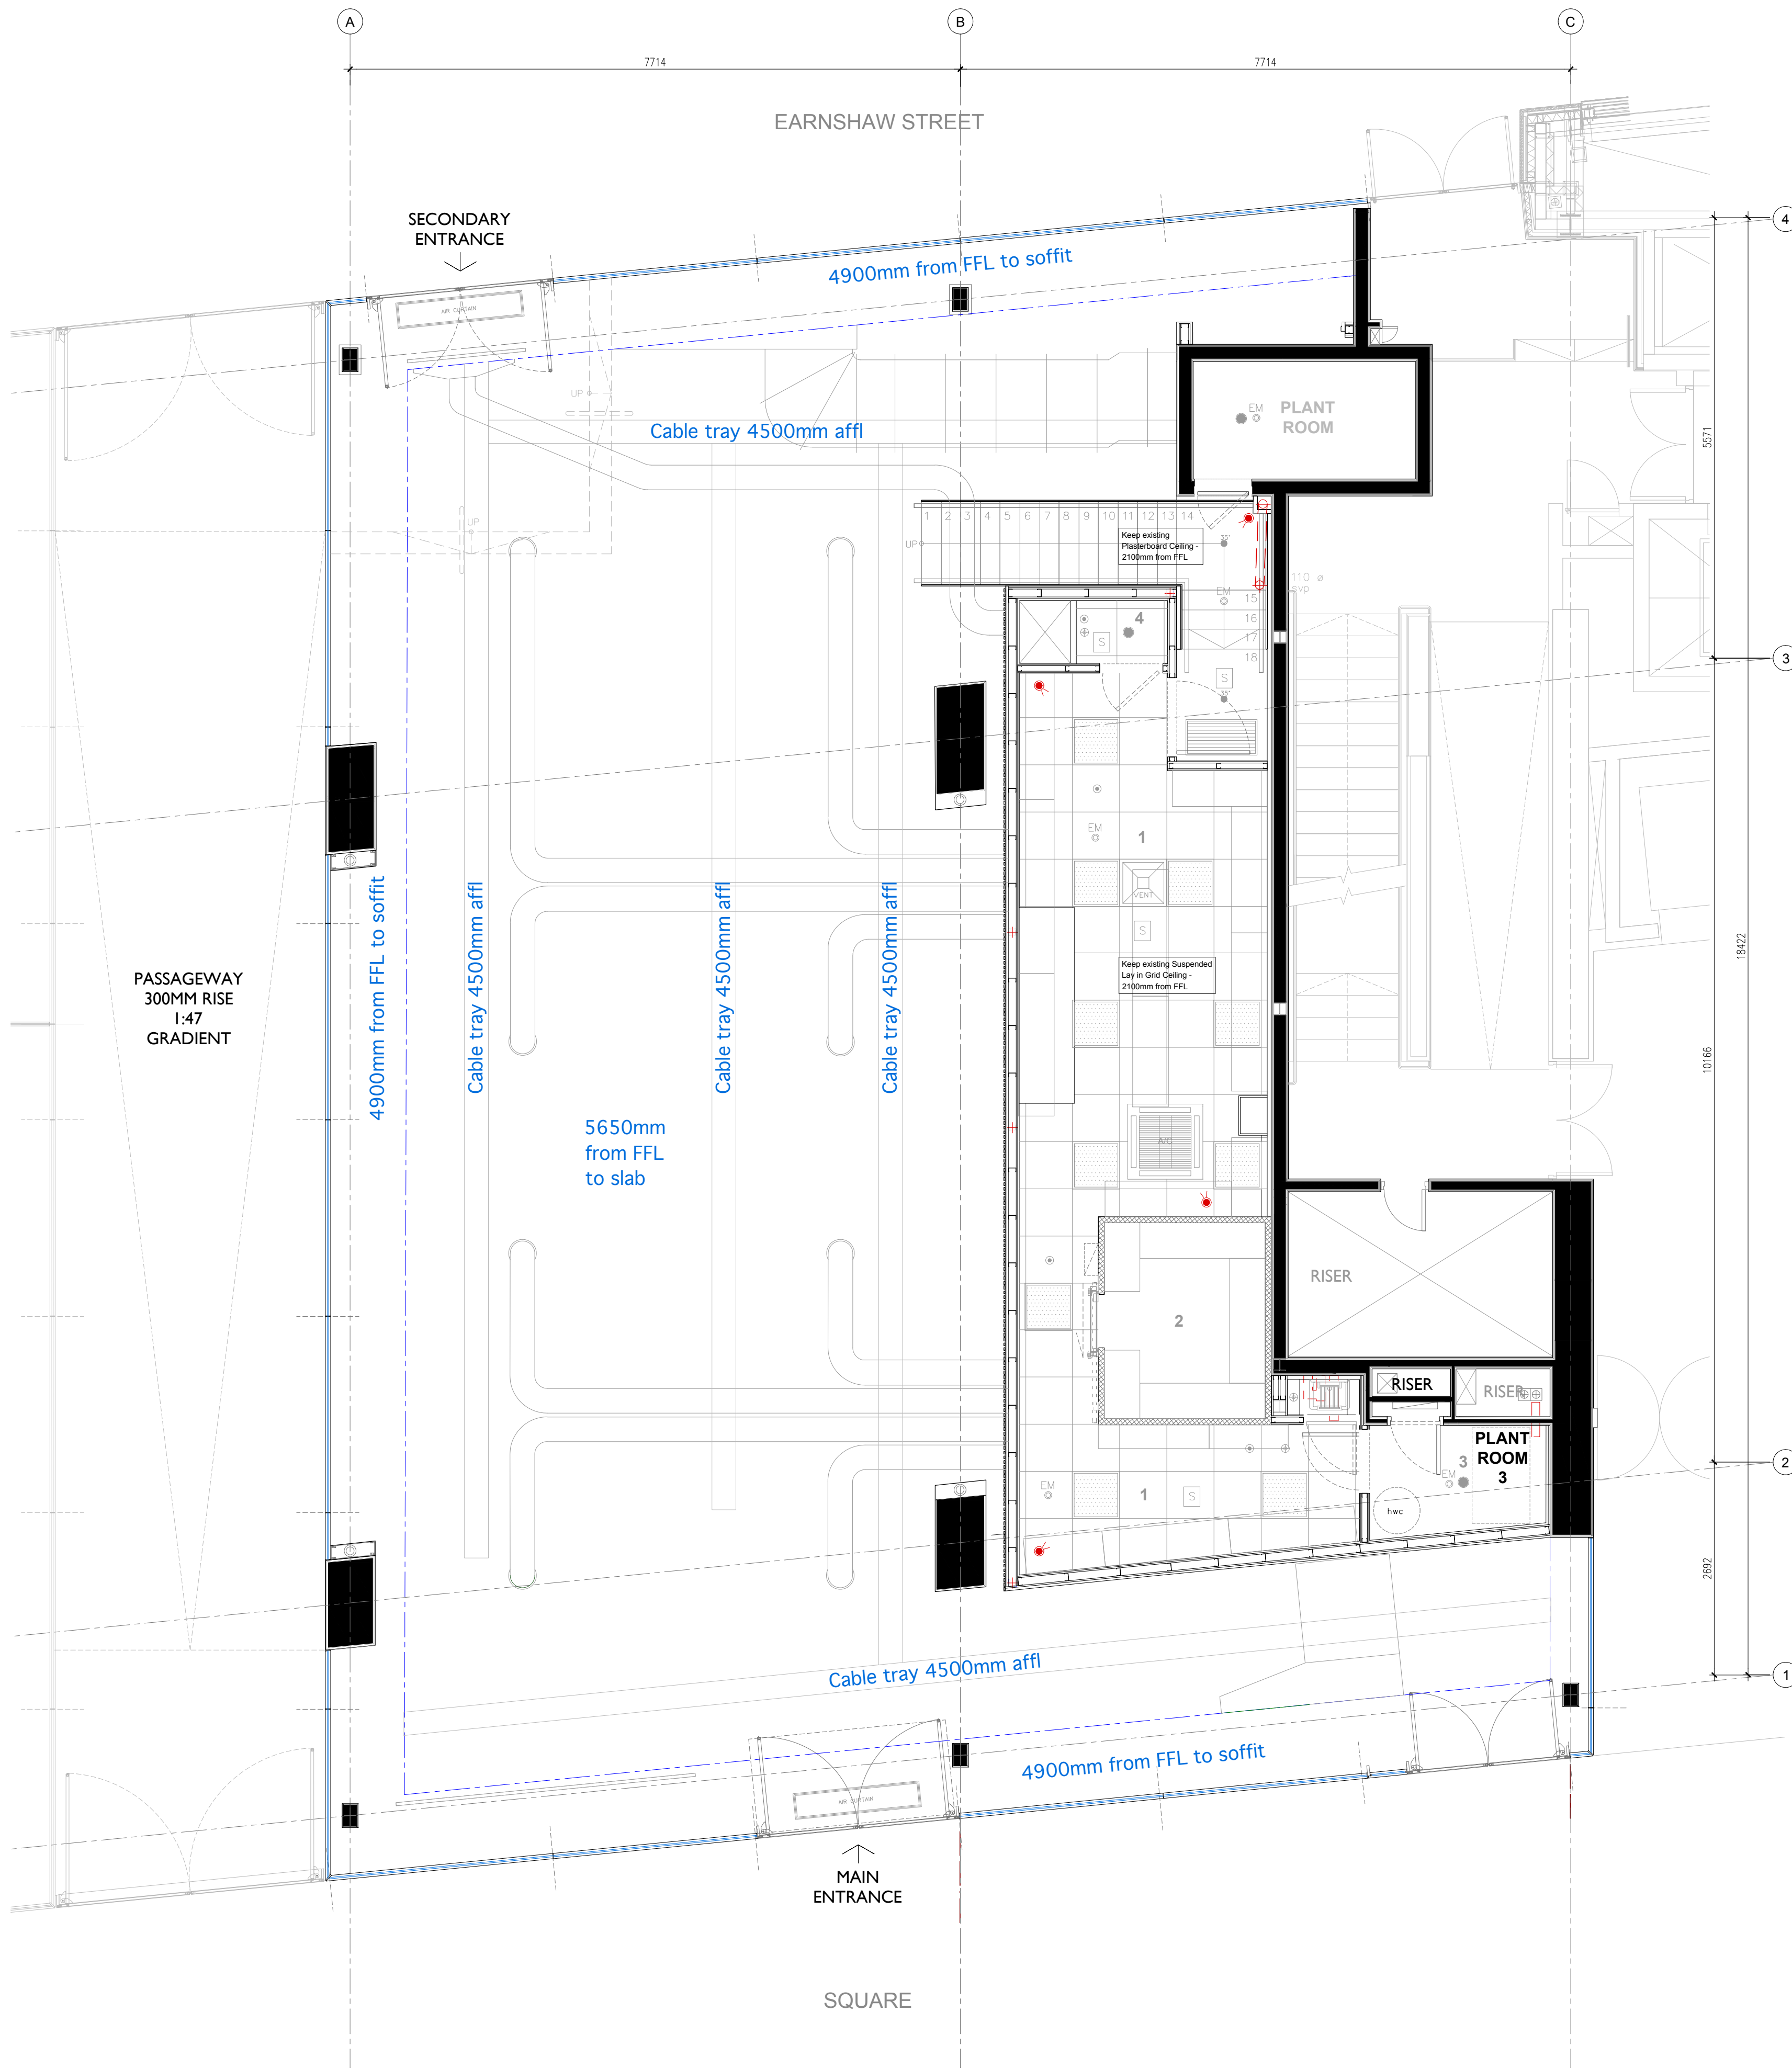


PROPOSED MEZZANINE FLOOR REFLECTED CEILING PLAN
SCALE 1:50

PROPOSED MEZZANINE FLOOR RCP PLAN


- 1. Dry Storage - Area 29.6 sqm (CH:2100mm)
- 2. Cold Room - Area 5 sqm (CH:2100mm)
- 3. Plant Room - Area 2.9 sqm
- 4. Refuse store - Area 0.9 sqm (CH:2100mm)

Mezzanine Floor Area : 44.5 sqm
Total Unit Area : 294.9 sqm

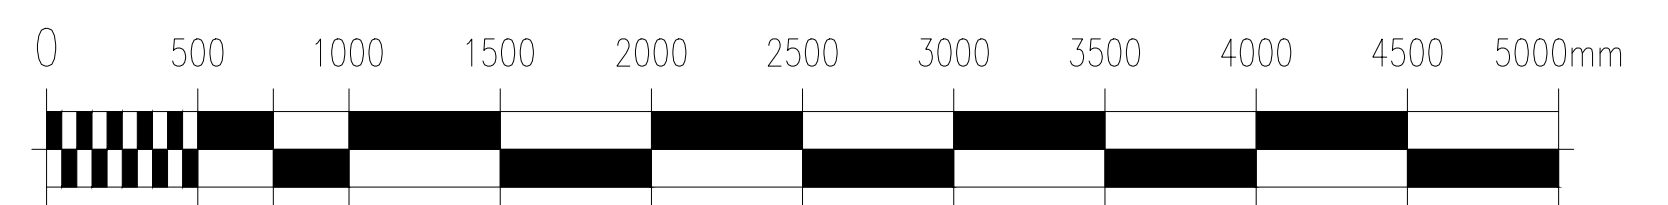

NOTE

All dimensions to be checked on site prior to commencement of any works.
This drawing represents a performance guide upon which the contractor/subcontractor must base his/her working drawings & details. Include all necessary tolerances prior to manufacture and installation.
Contractor must undertake a full survey of the area to establish all dimensions & ensure accurate setting out.
Advise on suitability of all details shown to ensure structural stability, ease and economy of construction.

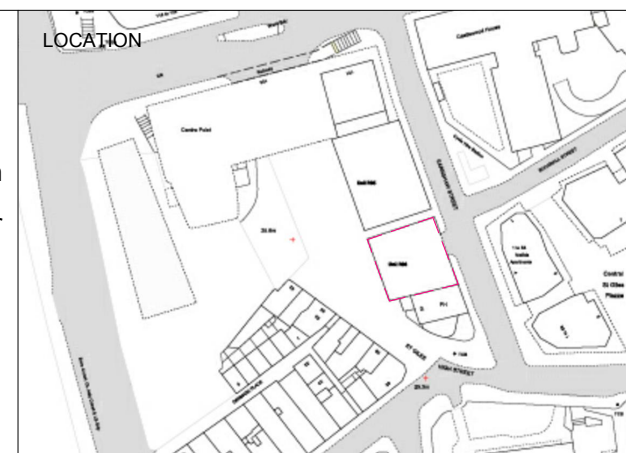

studio penn london
Architecture & Interior Design
studiospace@gmail.com

job title				SEOUL PLAZA - UNIT R06 & R08 CENTRE POINT	
drawing title / location				PROPOSED REFLECTED CEILING PLAN MEZZANINE FLOOR	
drawn by	checked by	scale	status		
JL	YH	1 : 50 @ A1 / 100 @ A3	PLANNING		
project	classification / drawing no.				
2205	2205.CP.DE.240				